


| | | | | |
|---------------------|---------|-----------|------------------|-----------|
| F.A.P. RTE. | SECTION | COUNTY | TOTAL SHEETS | SHEET NO. |
| 322 | 11-13 | CHRISTIAN | 437 | 172 |
| STA. | | TO STA. | | |
| FED. ROAD DIST. NO. | | ILLINOIS | FED. AID PROJECT | |

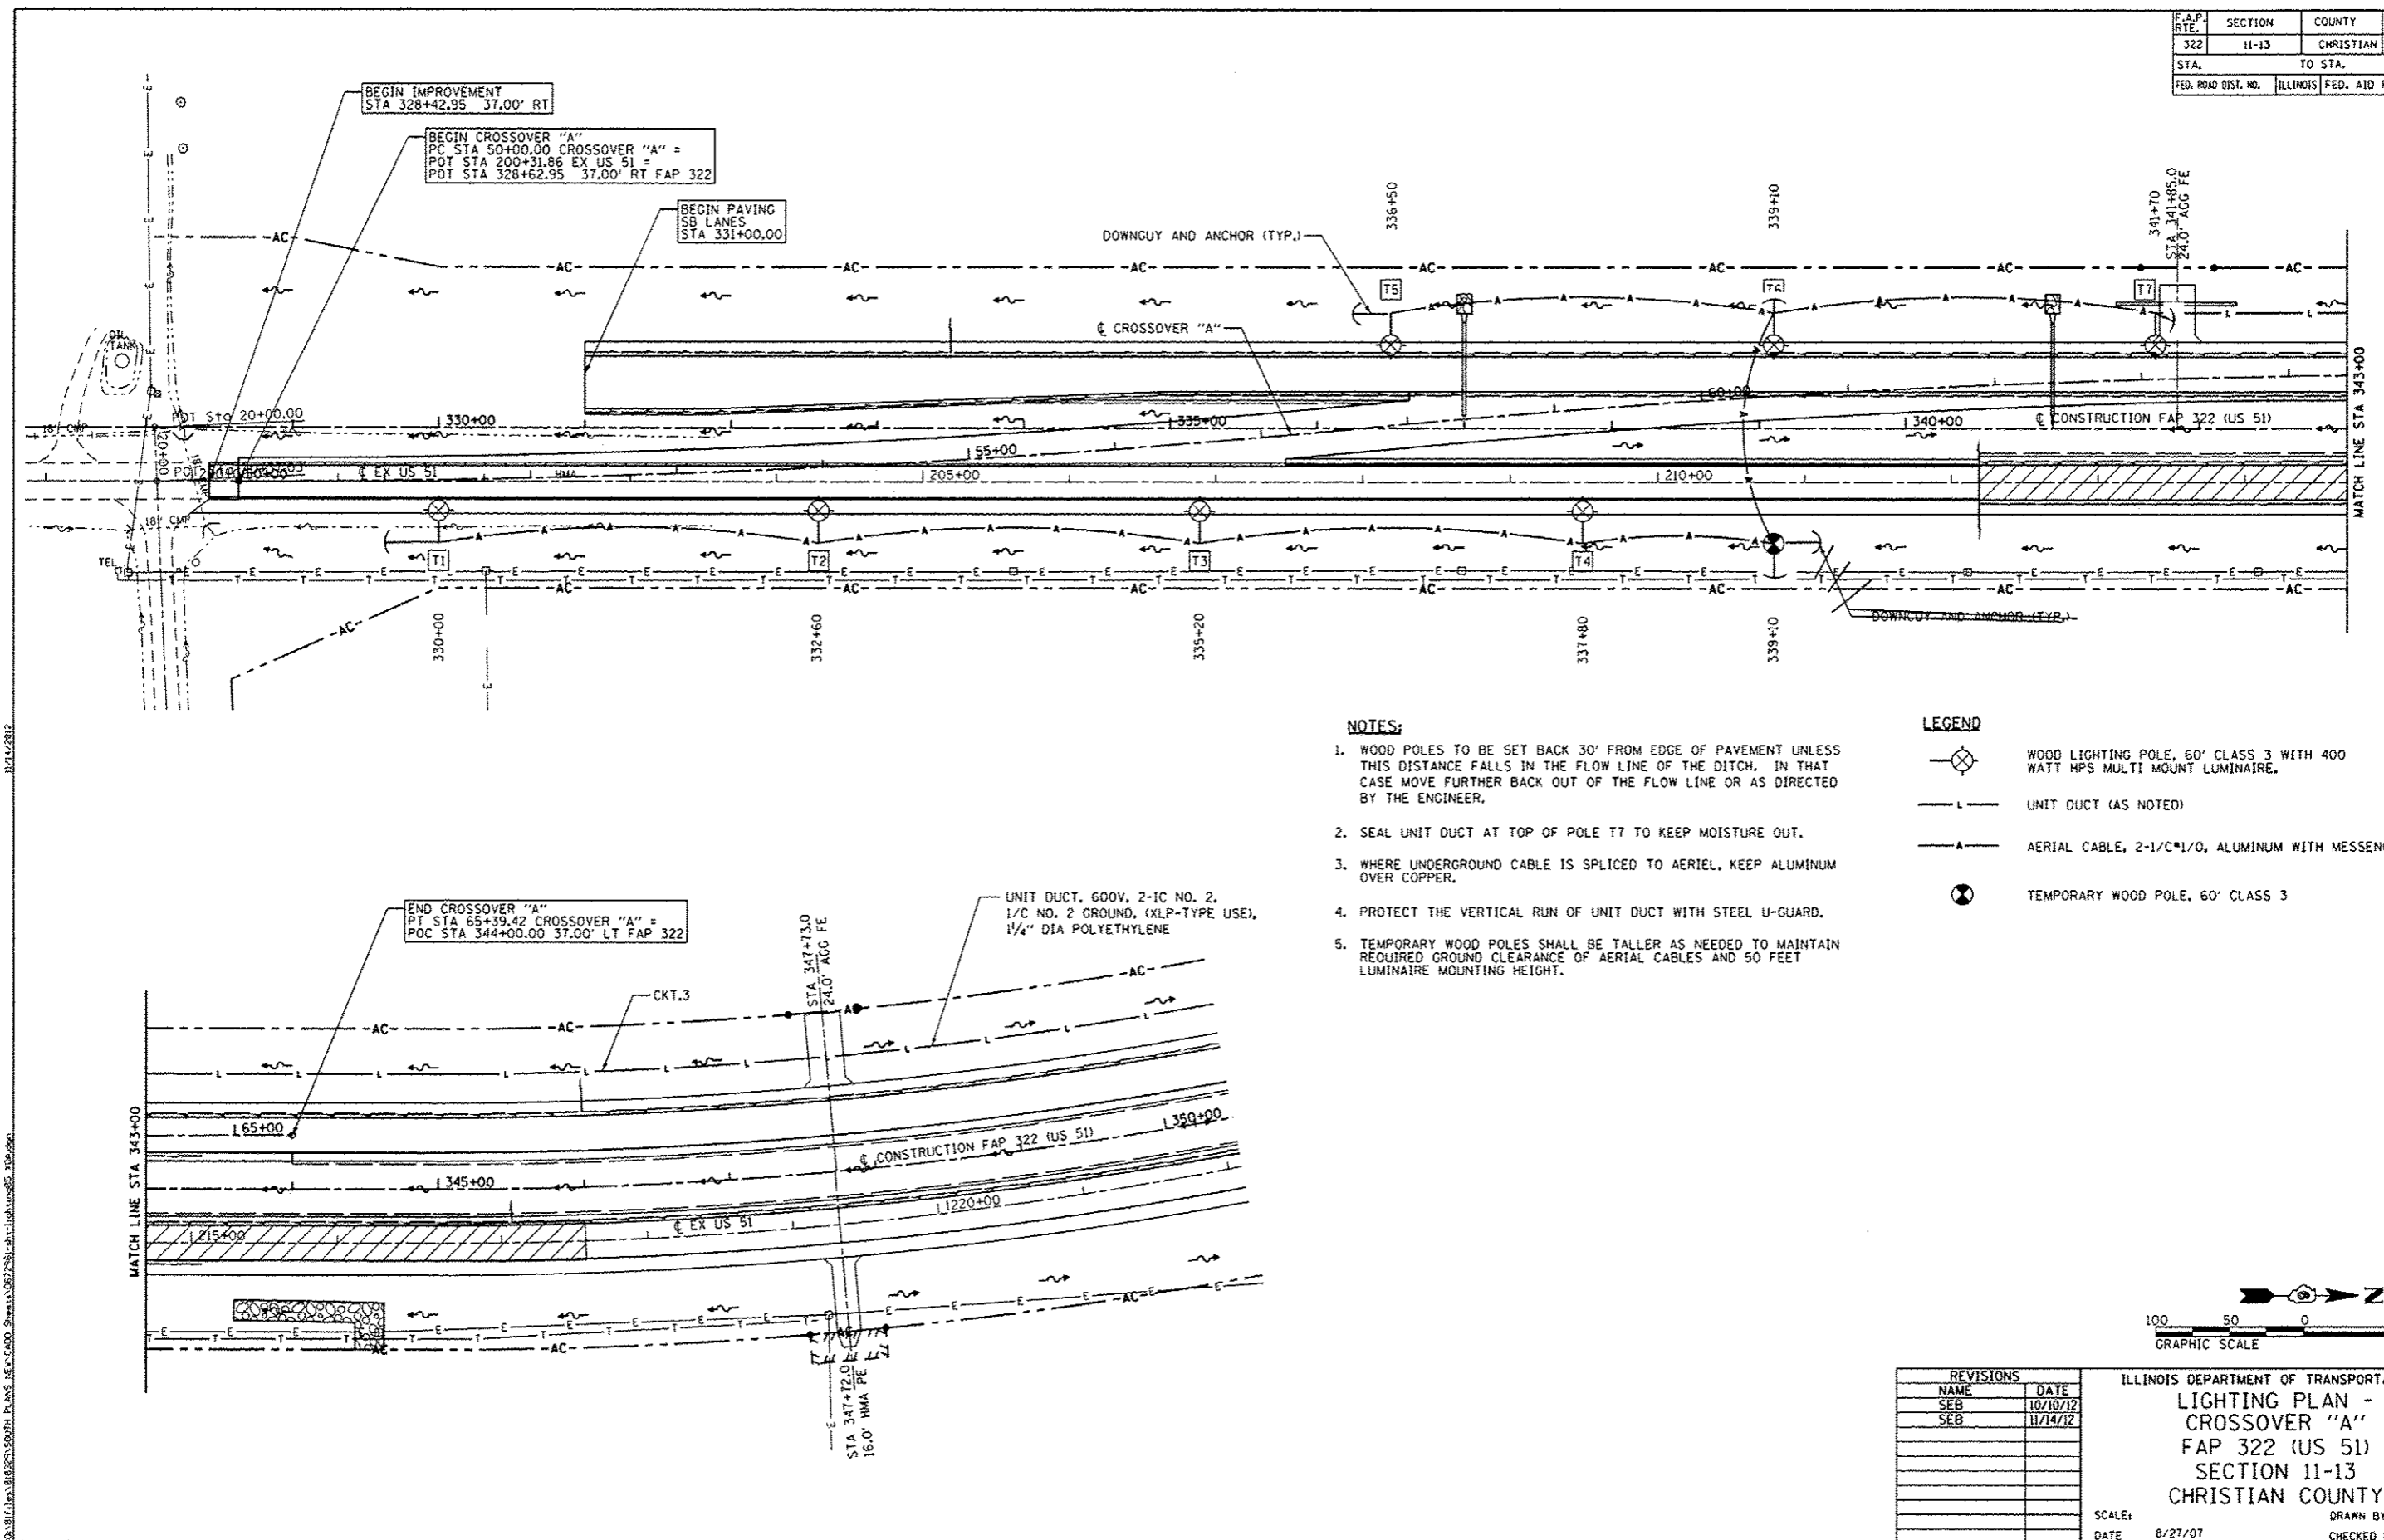 


NOTES:

- WOOD POLES TO BE SET BACK 30' FROM EDGE OF PAVEMENT UNLESS THIS DISTANCE FALLS IN THE FLOW LINE OF THE DITCH. IN THAT CASE MOVE FURTHER BACK OUT OF THE FLOW LINE OR AS DIRECTED BY THE ENGINEER.
- SEAL UNIT DUCT AT TOP OF POLE T7 TO KEEP MOISTURE OUT.
- WHERE UNDERGROUND CABLE IS SPLICED TO AERIAL, KEEP ALUMINUM OVER COPPER.
- PROTECT THE VERTICAL RUN OF UNIT DUCT WITH STEEL U-GUARD.
- TEMPORARY WOOD POLES SHALL BE TALLER AS NEEDED TO MAINTAIN REQUIRED GROUND CLEARANCE OF AERIAL CABLES AND 50 FEET LUMINAIRE MOUNTING HEIGHT.

LEGEND

- WOOD LIGHTING POLE, 60' CLASS 3 WITH 400 WATT HPS MULTI MOUNT LUMINAIRE.
- UNIT DUCT (AS NOTED)
- AERIAL CABLE, 2-1/C#1/0, ALUMINUM WITH MESSENGER WIRE
- TEMPORARY WOOD POLE, 60' CLASS 3



| REVISIONS | |
|-----------|----------|
| NAME | DATE |
| SEB | 10/10/12 |
| SEB | 11/14/12 |
| | |
| | |
ILLINOIS DEPARTMENT OF TRANSPORTATION
LIGHTING PLAN - CROSSOVER "A"
FAP 322 (US 51)
SECTION 11-13
CHRISTIAN COUNTY

SCALE: DRAWN BY EBB
 DATE 8/27/07 CHECKED BY

11/14/2012
 C:\BTL\lra\10\322\350\14_Plan_51_CADD_Sheet\1067281-ah-lighting\51_XP.dwg