


ALL DIMENSIONS IN METERS EXCEPT PAY ITEMS AND UNLESS NOTED OTHERWISE


F.A.I. RTE.	SECTION	COUNTY	TOTAL SHEETS	SHEET NO.
80/94	2626.2-R-2	COOK/LAKE	1207	53
STA.	TO STA.			
FED. ROAD DIST. NO.	ILLINOIS	FED. AID PROJECT		
CONTRACT NO. 62114	INDOT DES. NO. 0100987			

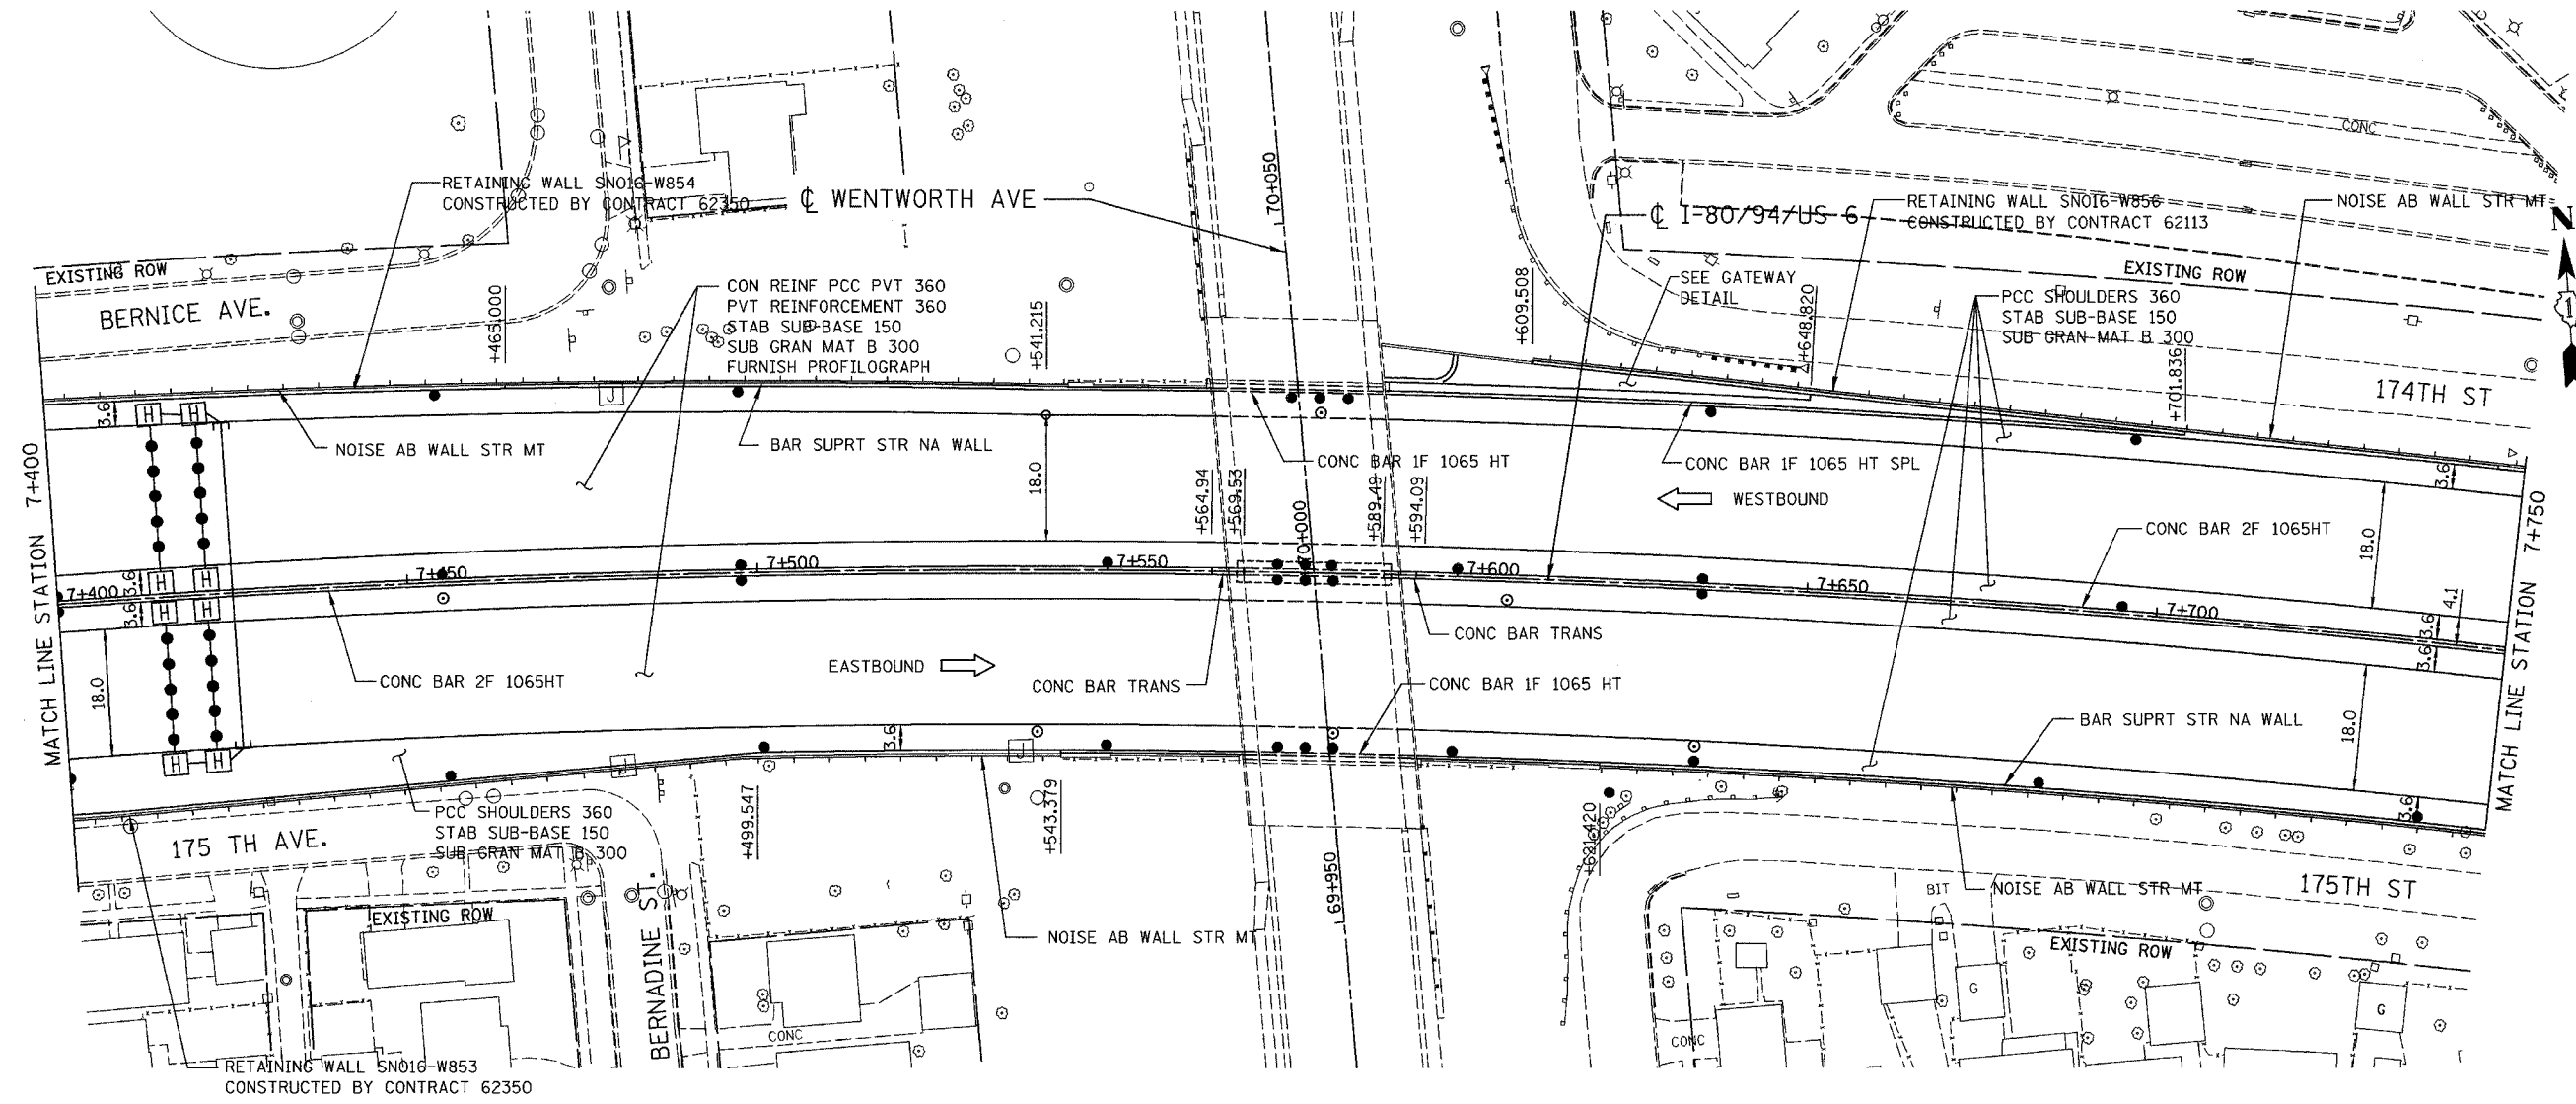

**PROPOSED LEGEND:**

- NOISE ABATEMENT (SOUND) WALL
- QC/OA PCCP 330  
SUBBASE PCCP 225 (IN)  
SUBGRD TRTMT T1A (IN)

NOTE: FOR ELECTRICAL WORK IN CONTRACT, SEE "ELECTRICAL INSTALLATION PLANS".  
FOR ELECTRICAL WORK BY OTHERS, SUBJECT TO CONTRACTOR MODIFICATION,  
SEE "EXISTING LIGHTING PLAN" SHEETS.

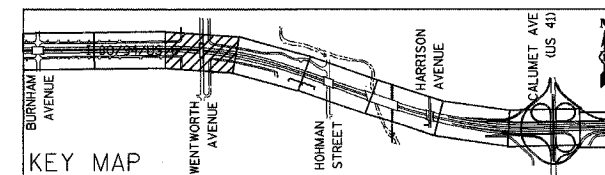

REVISIONS	
NAME	DATE

**ILLINOIS DEPARTMENT OF TRANSPORTATION**  
**I-80/94/US 6**  
**KINGERY-BORMAN EXPRESSWAY**  
**BURNHAM ROAD TO US 41**  
**PROPOSED PLAN**

**STA. 7+400 TO STA. 7+750**  
 SCALE 1:500 DRAWN BY ACE/CAD  
 DATE 07/05 CHECKED BY TAE

**AMERICAN**  
 CONSULTING ENGINEERS