


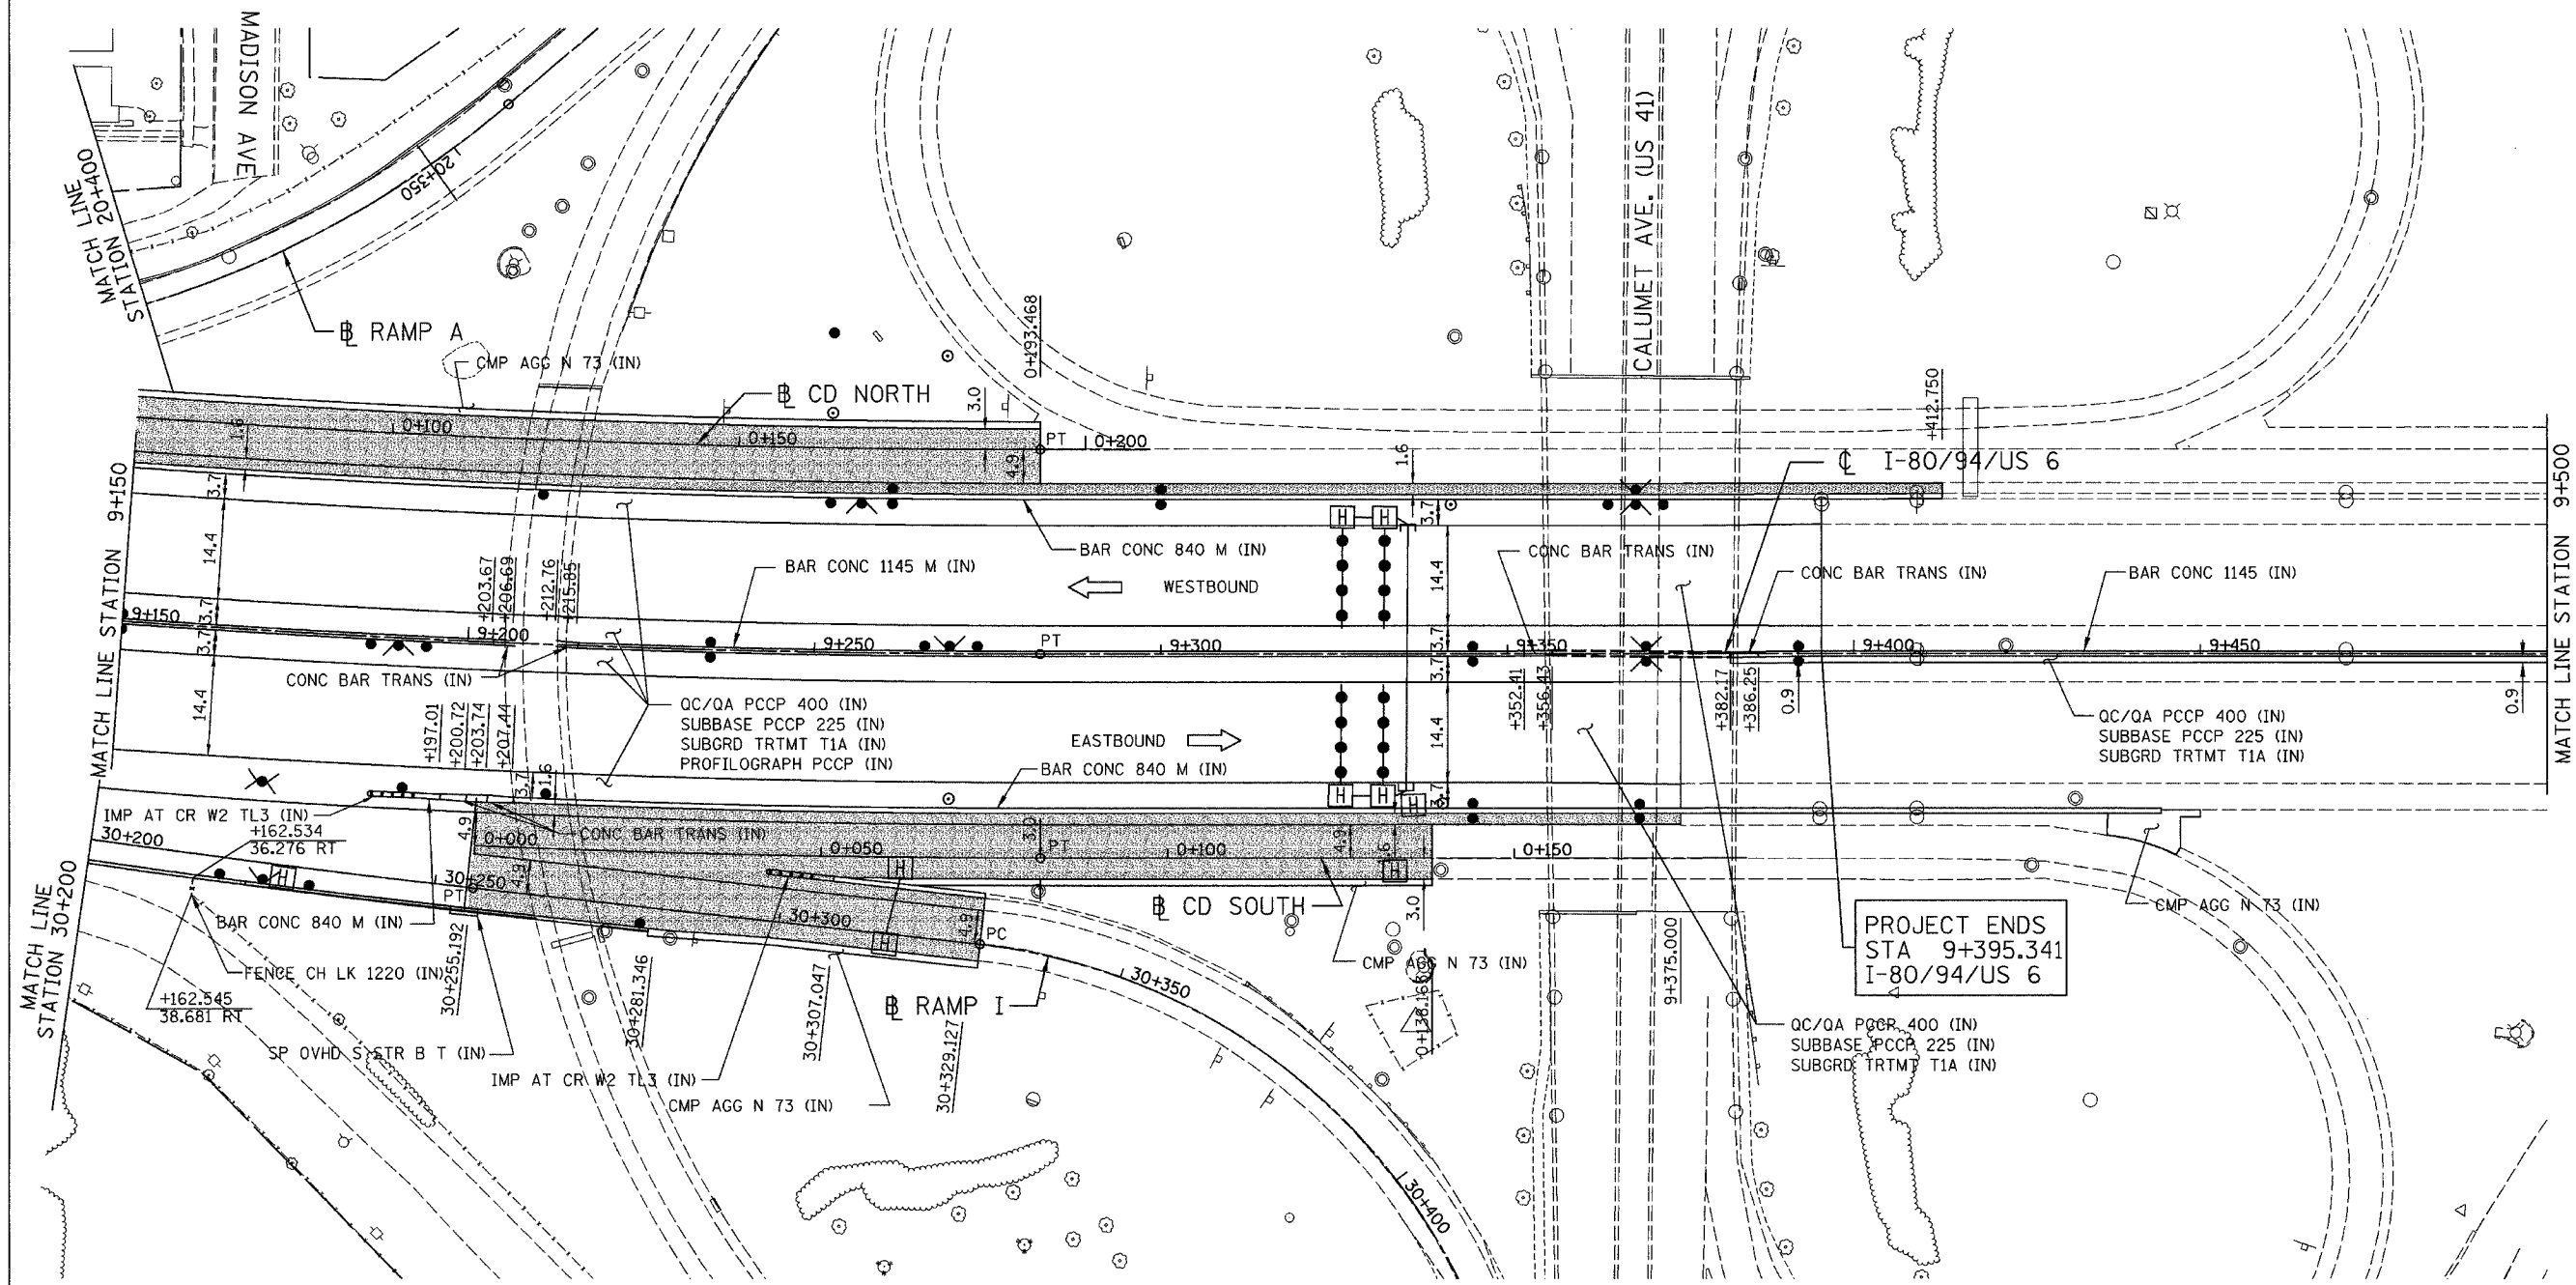



ALL DIMENSIONS IN METERS EXCEPT PAVEMENT ITEMS AND UNLESS NOTED OTHERWISE


F.A.I. RTE.	SECTION	COUNTY	TOTAL SHEETS	SHEET NO.
80/94	2626.2-R-2	COOK/LAKE	1207	63
STA.		TO STA.		
FED. ROAD DIST. NO.		ILLINOIS FED. AID PROJECT		
CONTRACT NO. 62114		INDOT DES. NO. 0100987		



PROPOSED LEGEND:

-  NOISE ABATEMENT (SOUND) WALL
-  QC/QA PCCP 330
-  SUBBASE PCCP 225 (IN)
-  SUBGRD TRTMT T1A (IN)

NOTE: FOR ELECTRICAL WORK IN CONTRACT, SEE "ELECTRICAL INSTALLATION PLANS".
FOR ELECTRICAL WORK BY OTHERS, SUBJECT TO CONTRACTOR MODIFICATION, SEE "EXISTING LIGHTING PLAN" SHEETS.

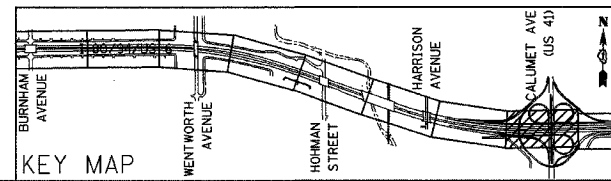

REVISIONS	
NAME	DATE

ILLINOIS DEPARTMENT OF TRANSPORTATION
I-80/94/US 6
KINGERY-BORMAN EXPRESSWAY
BURNHAM ROAD TO US 41
PROPOSED PLAN

STA. 9+150 TO STA. 9+500
SCALE 1:500
DATE 07/05
DRAWN BY ACE/CAD
CHECKED BY TAE

