



ALL DIMENSIONS IN METERS EXCEPT PAVEMENT ITEMS AND UNLESS NOTED OTHERWISE

| | | | | |
|----------------------|-----------------------|------------------------|----------------------|------------------|
| F.A.I. RTE. 80/94 | SECTION 2626.2-R-2 | COUNTY COOK/LAKE | TOTAL SHEETS 1207 | SHEET NO. 257 |
| STA. 9+150 | | TO STA. 9+500 | | |
| FED. ROAD DIST. NO. | ILLINOIS | FED. AID PROJECT | | |
| CONTRACT NO. 62114 | | INDOT DES. NO. 0100987 | | |

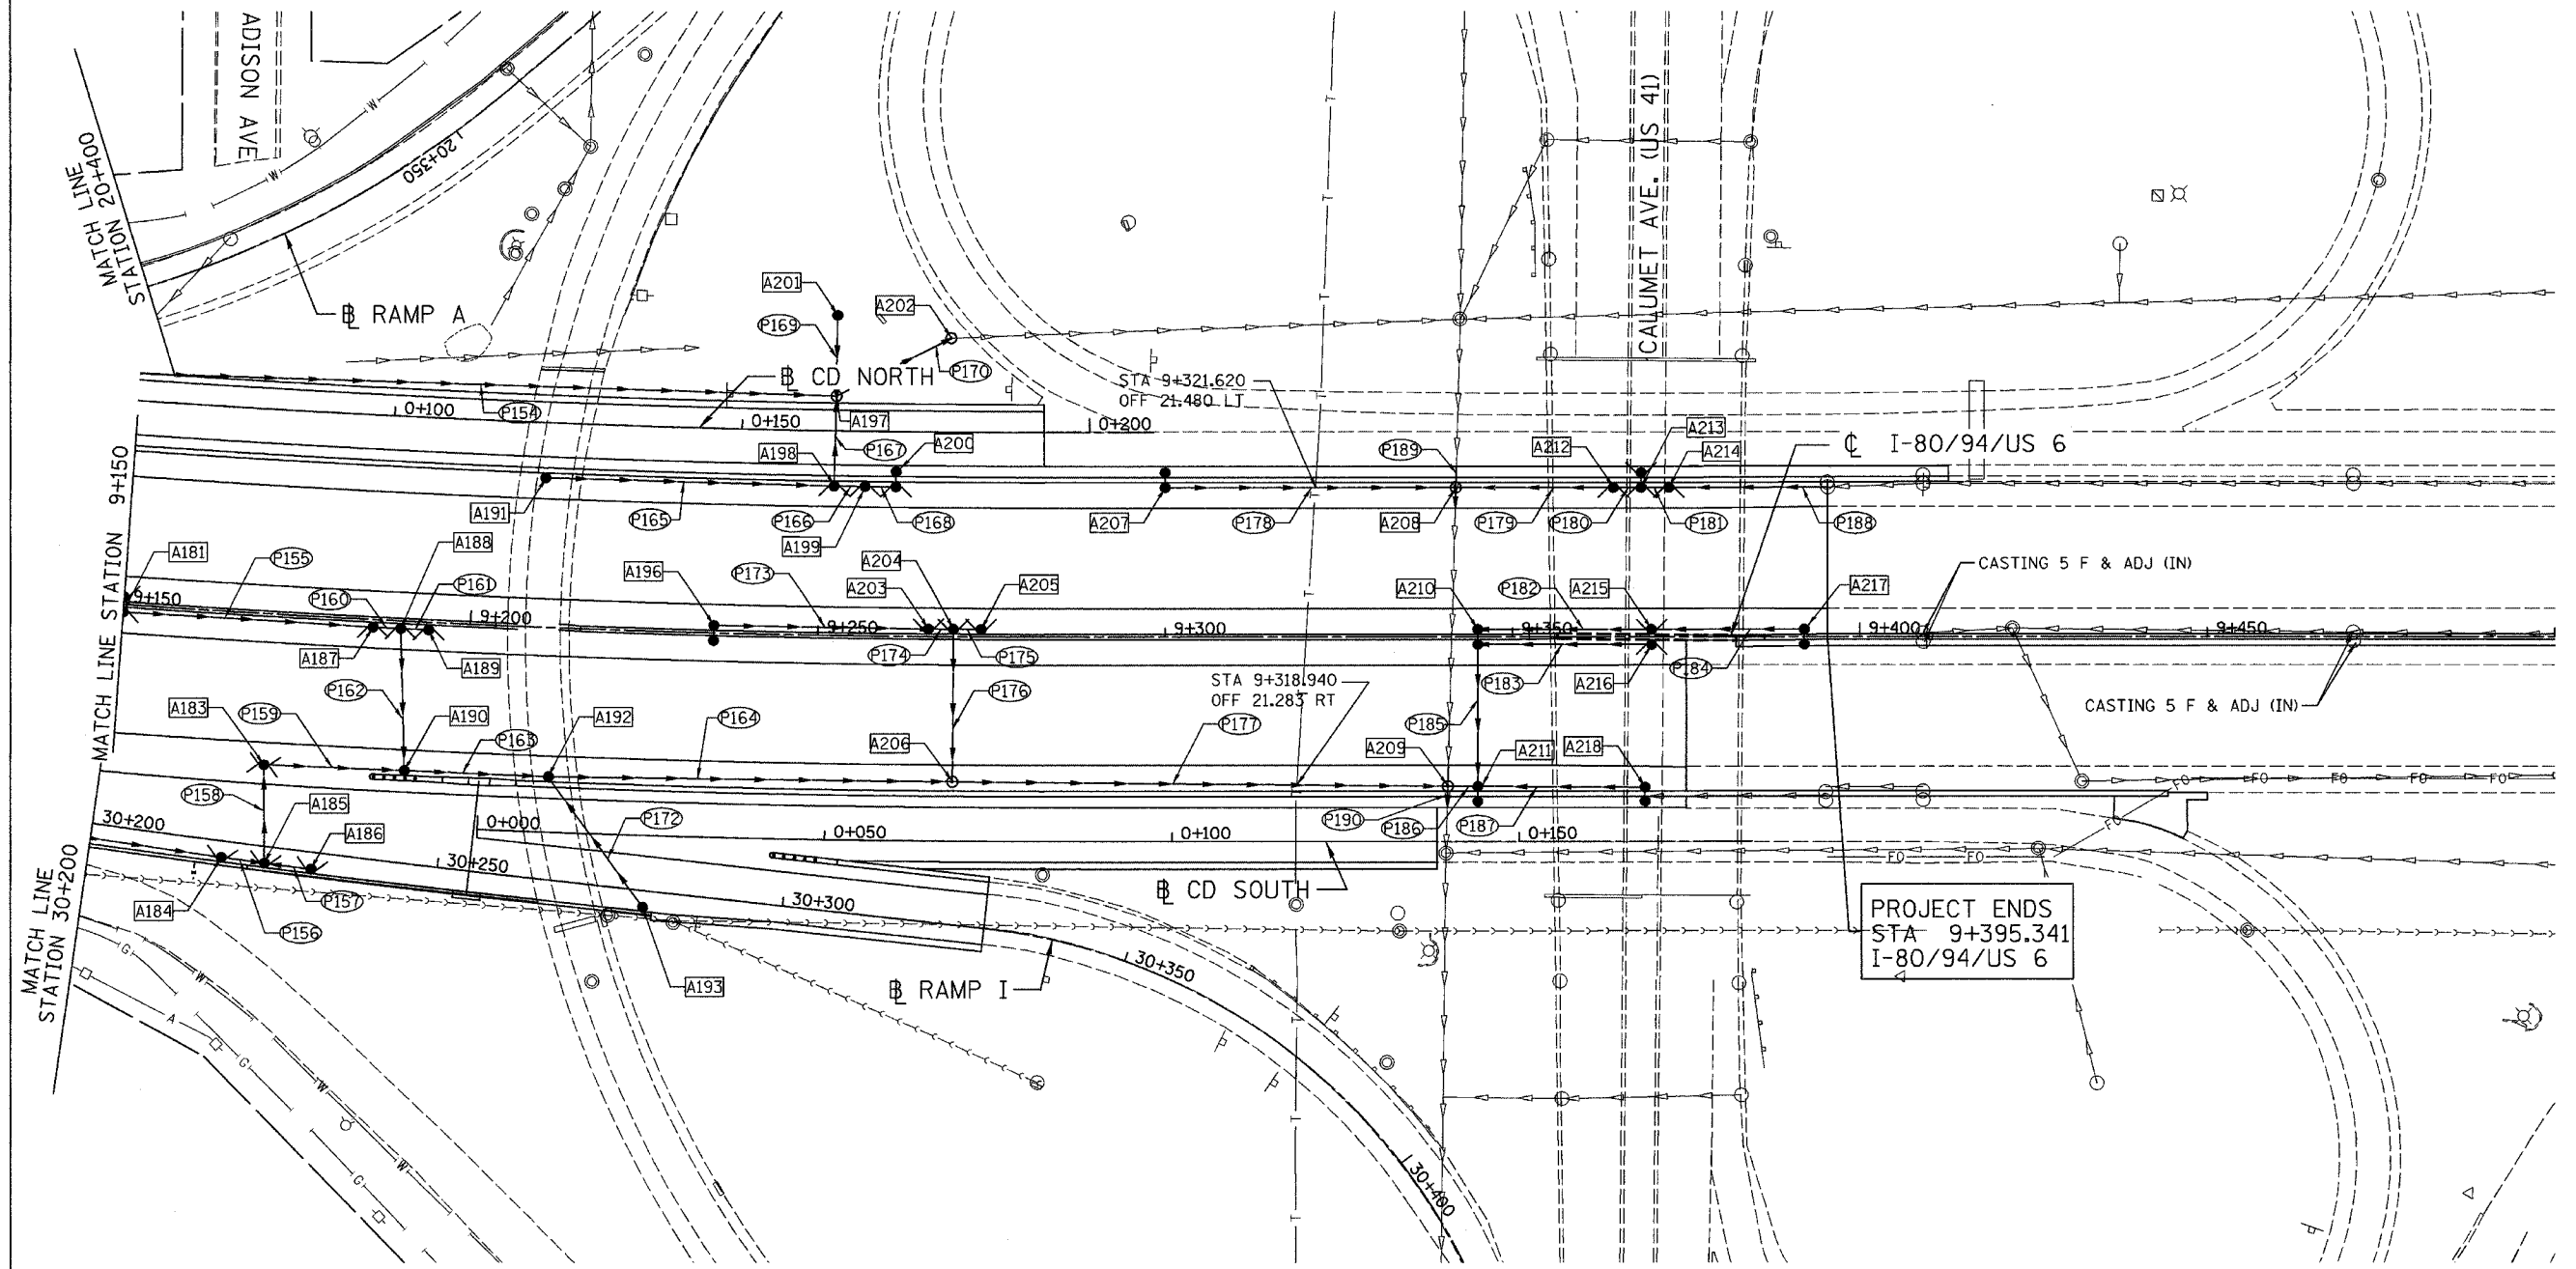

NOTE: PIPE P163 SHALL BE INSTALLED TO ALLOW FOR SUBSEQUENT CONSTRUCTION OF SIGN FOUNDATION.

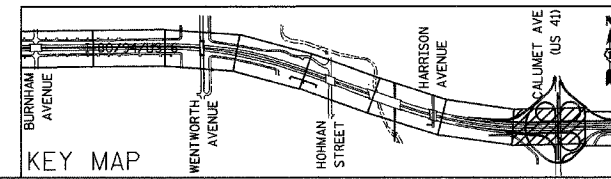

| REVISIONS | |
|-----------|------|
| NAME | DATE |
| | |
| | |
| | |

ILLINOIS DEPARTMENT OF TRANSPORTATION
 I-80/94/US 6
 KINGERY-BORMAN EXPRESSWAY
 BURNHAM ROAD TO US 41
PROPOSED DRAINAGE PLAN

STA. 9+150 TO STA. 9+500
 SCALE 1:500
 DATE 07/05

DRAWN BY ACE/CAD
 CHECKED BY TAE