




F.A.I. RTE.	SECTION	COUNTY	TOTAL SHEETS	SHEET NO.
80/94	2003-0891	COOK	1207	454
STA.		TO STA.		
FED. ROAD DIST. NO.		ILLINOIS FED. AID PROJECT		
CONTRACT # 62114				

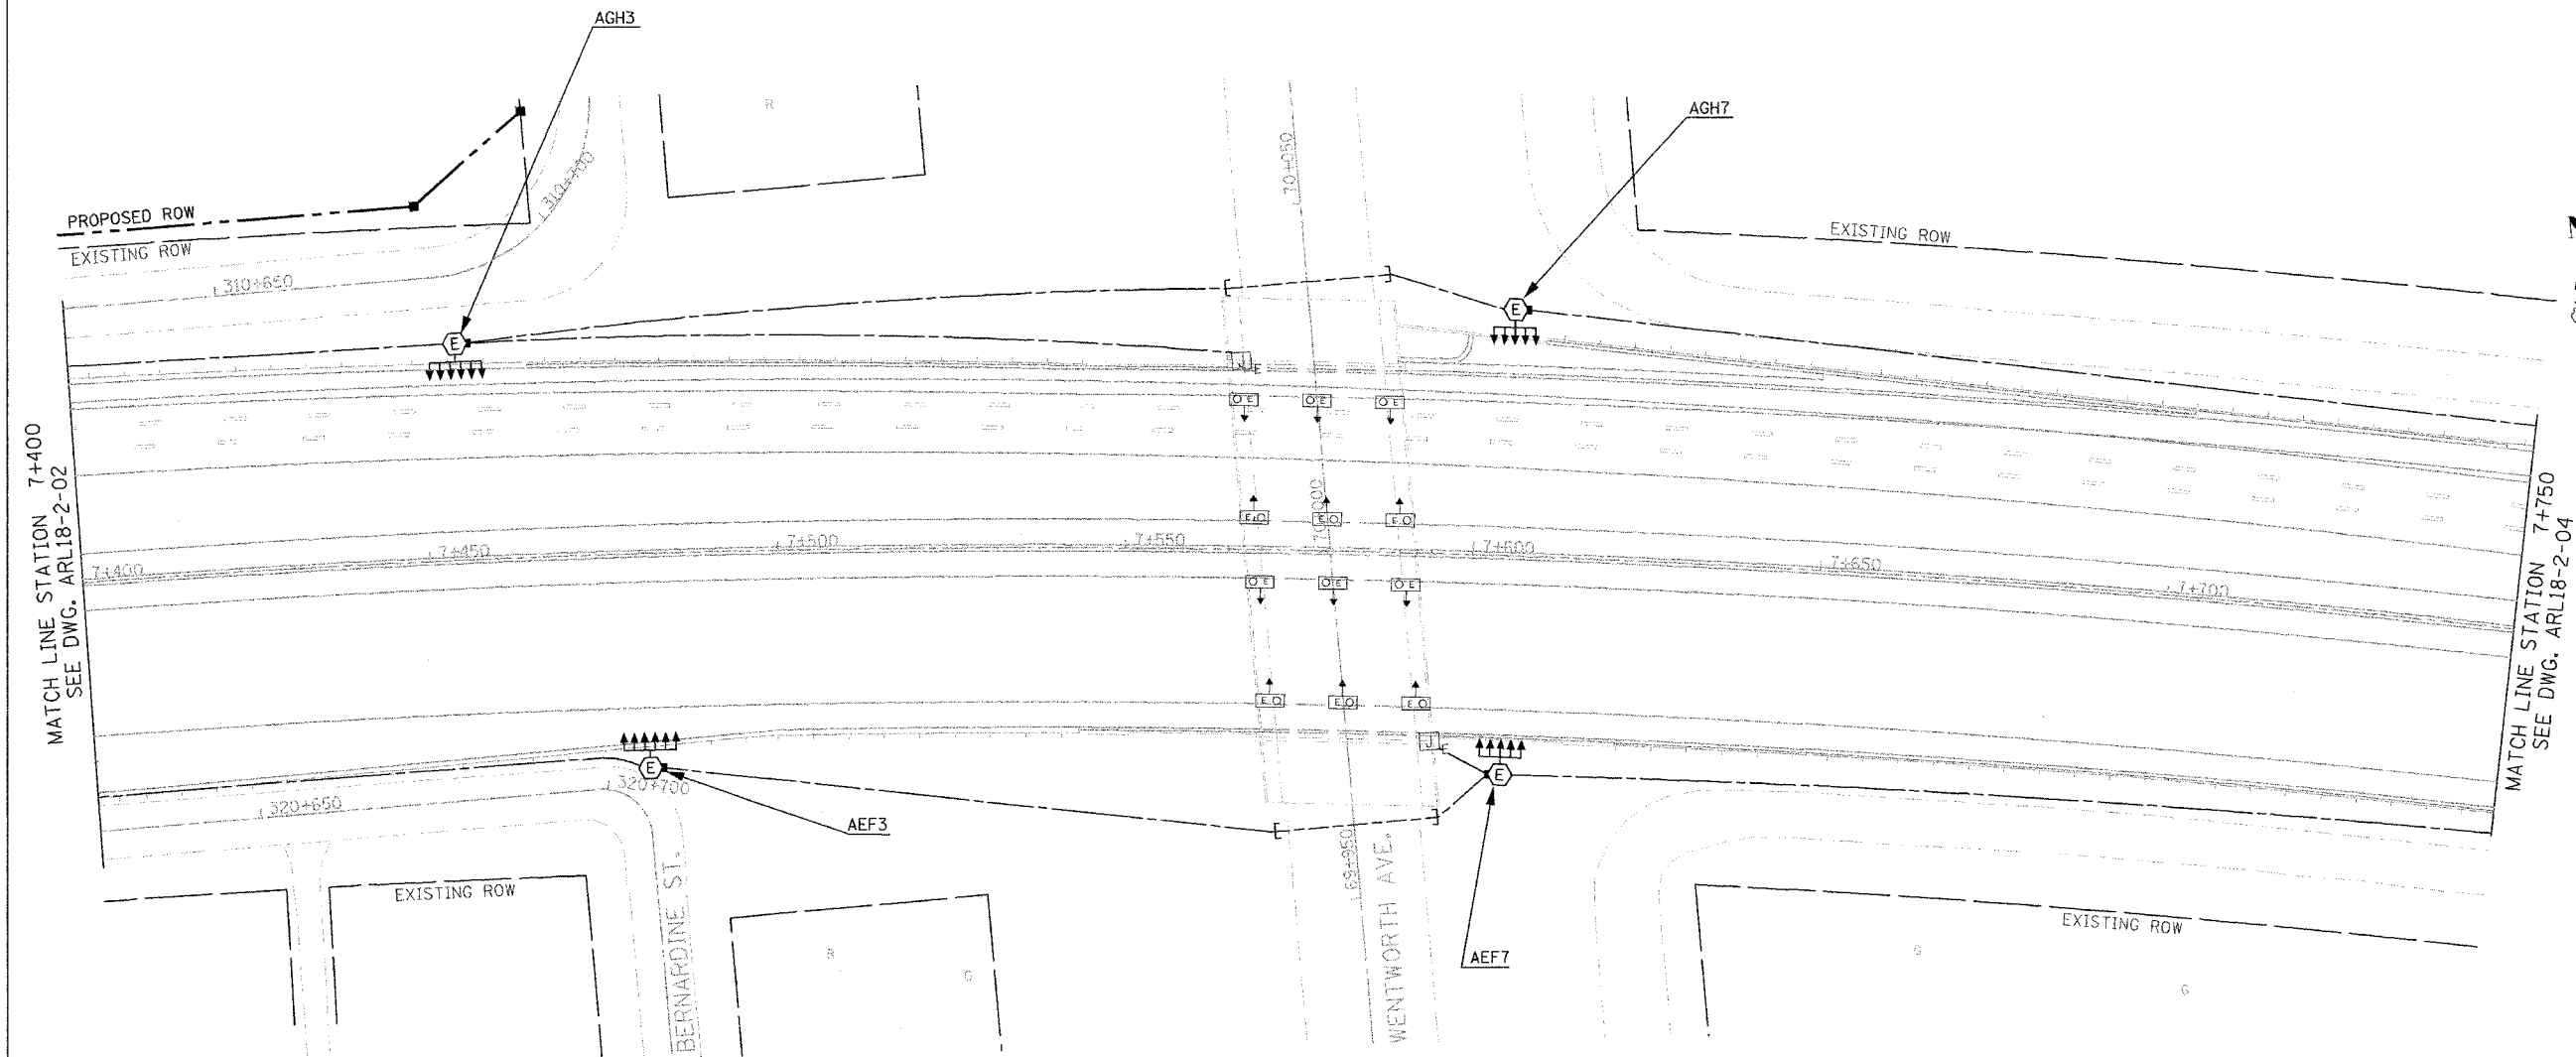

ARL18-2-03

ILLINOIS DEPARTMENT OF TRANSPORTATION  
 I-80/94/US 6  
 KINGERY-BORMAN EXPRESSWAY  
 BURNHAM ROAD TO US 41  
**EXISTING LIGHTING PLAN**  
 I-80 /94 /US-6  
**STA. 7+400 TO STA. 7+750**

 SCALE 1:500 DRAWN BY EA0/BC  
 DATE 07/18/05 CHECKED BY PKG/BC

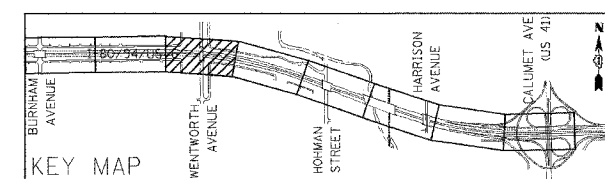

REVISIONS	
NAME	DATE

#1014  
 #1015  
 #1016