



ALL DIMENSIONS IN METERS EXCEPT PAY ITEMS AND UNLESS NOTED OTHERWISE.

F.A.I. RTE.	SECTION	COUNTY	TOTAL SHEETS	SHEET NO.
80/94	2626.2-R-2	COOK	1207	479
STA.	TO STA.			
FED. ROAD DIST. NO.	ILLINOIS FED. AID PROJECT			
CONTRACT #62114	INDOT DES. NO. 0100987			

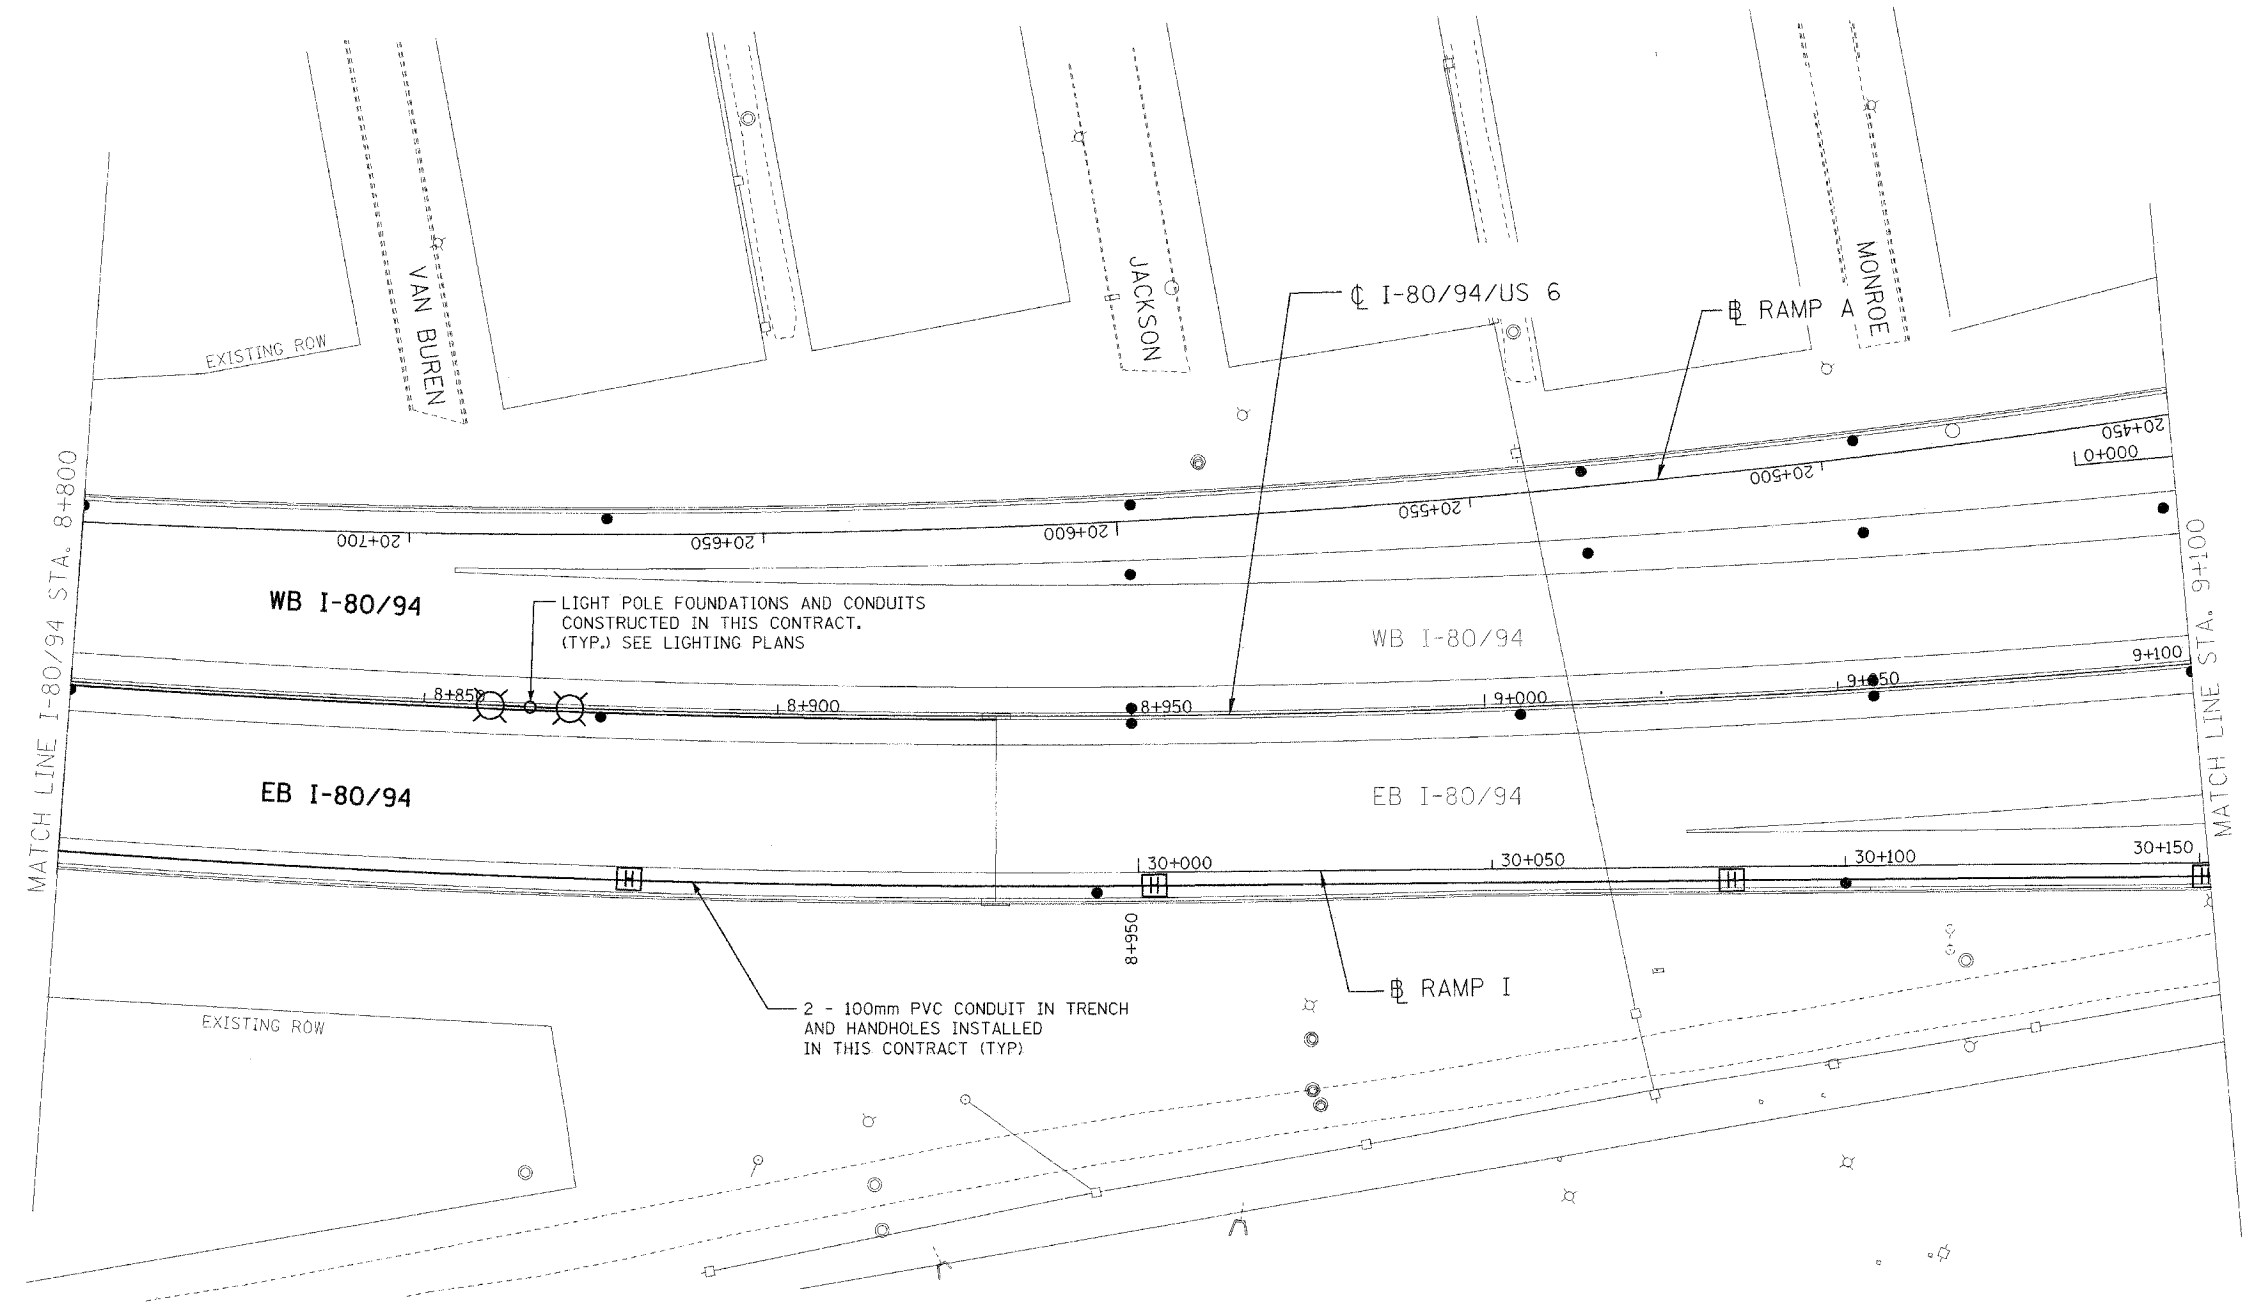

LIGHT POLE FOUNDATIONS AND CONDUITS CONSTRUCTED IN THIS CONTRACT. (TYP.) SEE LIGHTING PLANS

2 - 100mm PVC CONDUIT IN TRENCH AND HANDHOLES INSTALLED IN THIS CONTRACT (TYP)

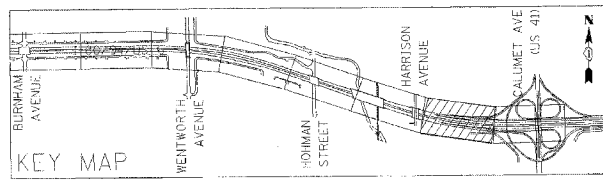

REVISIONS	
NAME	DATE

ILLINOIS DEPARTMENT OF TRANSPORTATION  
 I-80/94/US 6  
 KINGERY-BORMAN EXPRESSWAY  
 BURNHAM ROAD TO US 41  
**ELECTRICAL INSTALLATION PLAN**  
 STA. 8+800 TO STA. 9+150  
 SCALE 1:500  
 DATE 07/05  
 DRAWN BY JRH  
 CHECKED BY DEM

C:\p01\proj\8094\8094.dwg 10/22/2005 3:30:24 PM