


F.A. RTE.	SECTION	COUNTY	TOTAL SHEETS	SHEET NO.
22	6M & TS	HENRY	257	37
STA.		TO STA.		
FED. ROAD DIST. NO.	ILLINOIS	FED. AID PROJECT		

# STAGE 1A

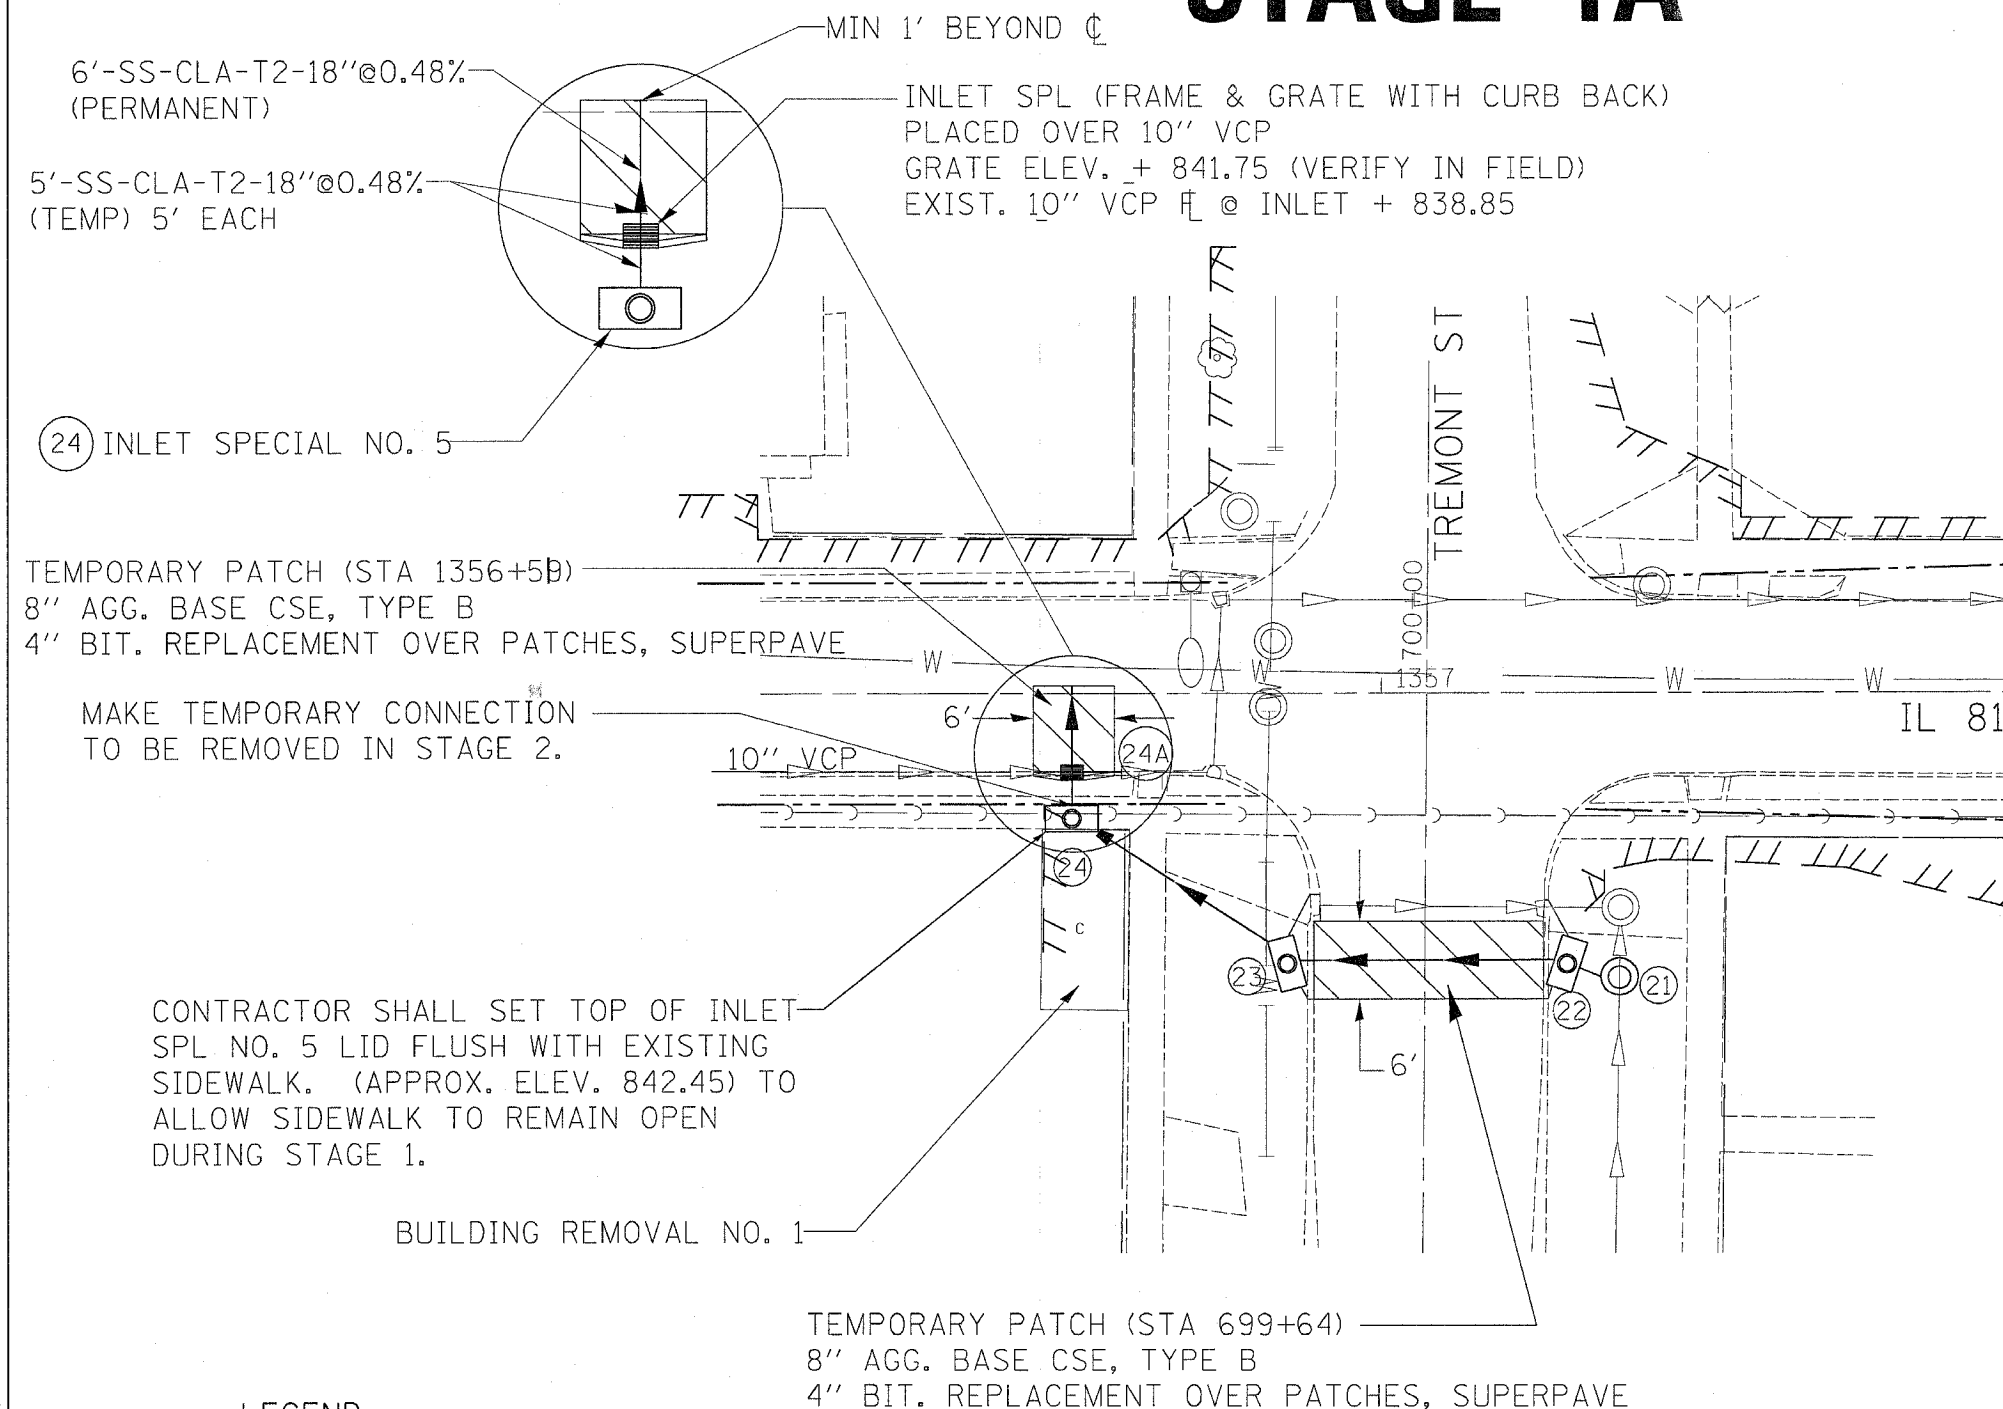

## SEQUENCE OF OPERATION

1. COMPLETE BUILDING REMOVAL NO. 1
2. INSTALL STORM SEWER AND INLETS IN SE & SW QUADRANTS OF TREMONT ST. AND IL 81.
3. INSTALL MANHOLE OVER EXISTING STORM SEWER.
4. INSTALL TEMPORARY INLET SPL TO INTERCEPT FLOW OF 10" VCP FROM WEST
5. CONSTRUCT TEMPORARY GUTTERS FROM EXISTING LOW POINT TO DRAIN INTO NEW INLETS (COST INCLUDED IN TEMPORARY PATCH).
6. PLACE TEMP PATCHES CONSISTING OF 8" AGG BASE COURSE, TYPE B AND 4" BITUMINOUS REPLACEMENT OVER PATCHES.
7. REPLACE SIDEWALK REMOVED WITH AGG. BASE COURSE, TYPE B THE COST FOR THIS WORK SHALL BE INCLUDED IN SIDEWALK REMOVAL.

ALL DROPOFFS EXCEEDING 3" SHALL CONFORM TO ARTICLE 701.04(b)(1)

THIS DRAWING NOT TO SCALE

REVISIONS		ILLINOIS DEPARTMENT OF TRANSPORTATION
NAME	DATE	
		SCALE: VERT. HORIZ. DATE
DRAWN BY		CHECKED BY
DATE		

### LEGEND

	PAVEMENT REMOVAL
	DRIVEWAY PAVEMENT REMOVAL
	COMB. CURB & GUTTER REMOVAL
	SIDEWALK REMOVAL
	TREE REMOVAL

IT SHALL BE THE CONTRACTORS RESPONSIBILITY TO PROVIDE STOP SIGNS AT ALL INTERSECTIONS WHERE APPLICABLE.

NOTE: ALL WORK TO BE COMPLETED DURING DAYLIGHT WORK HOURS WITH THE ROADWAY OPEN TO TRAFFIC AT NIGHT.

PLOT DATE = Thu Oct 27 18:39:23 2005  
 FILE NAME = c:\projects\64640\64640.dgn  
 PLOT SCALE = 1" = 100'  
 REFERENCE = ARE'S