 


COUNTY HIGHWAY	FISCAL YEAR	TOTAL SHEETS	SHEET NO.
	2005	30	13
SEC 03-00001-06-BT			DUPAGE COUNTY

CONTRACT NO.: 83805





 
MATCH LINE STA. 12+00

MATCH LINE STA. 18+00

MATCH LINE STA. 18+00

MATCH LINE STA. 24+00

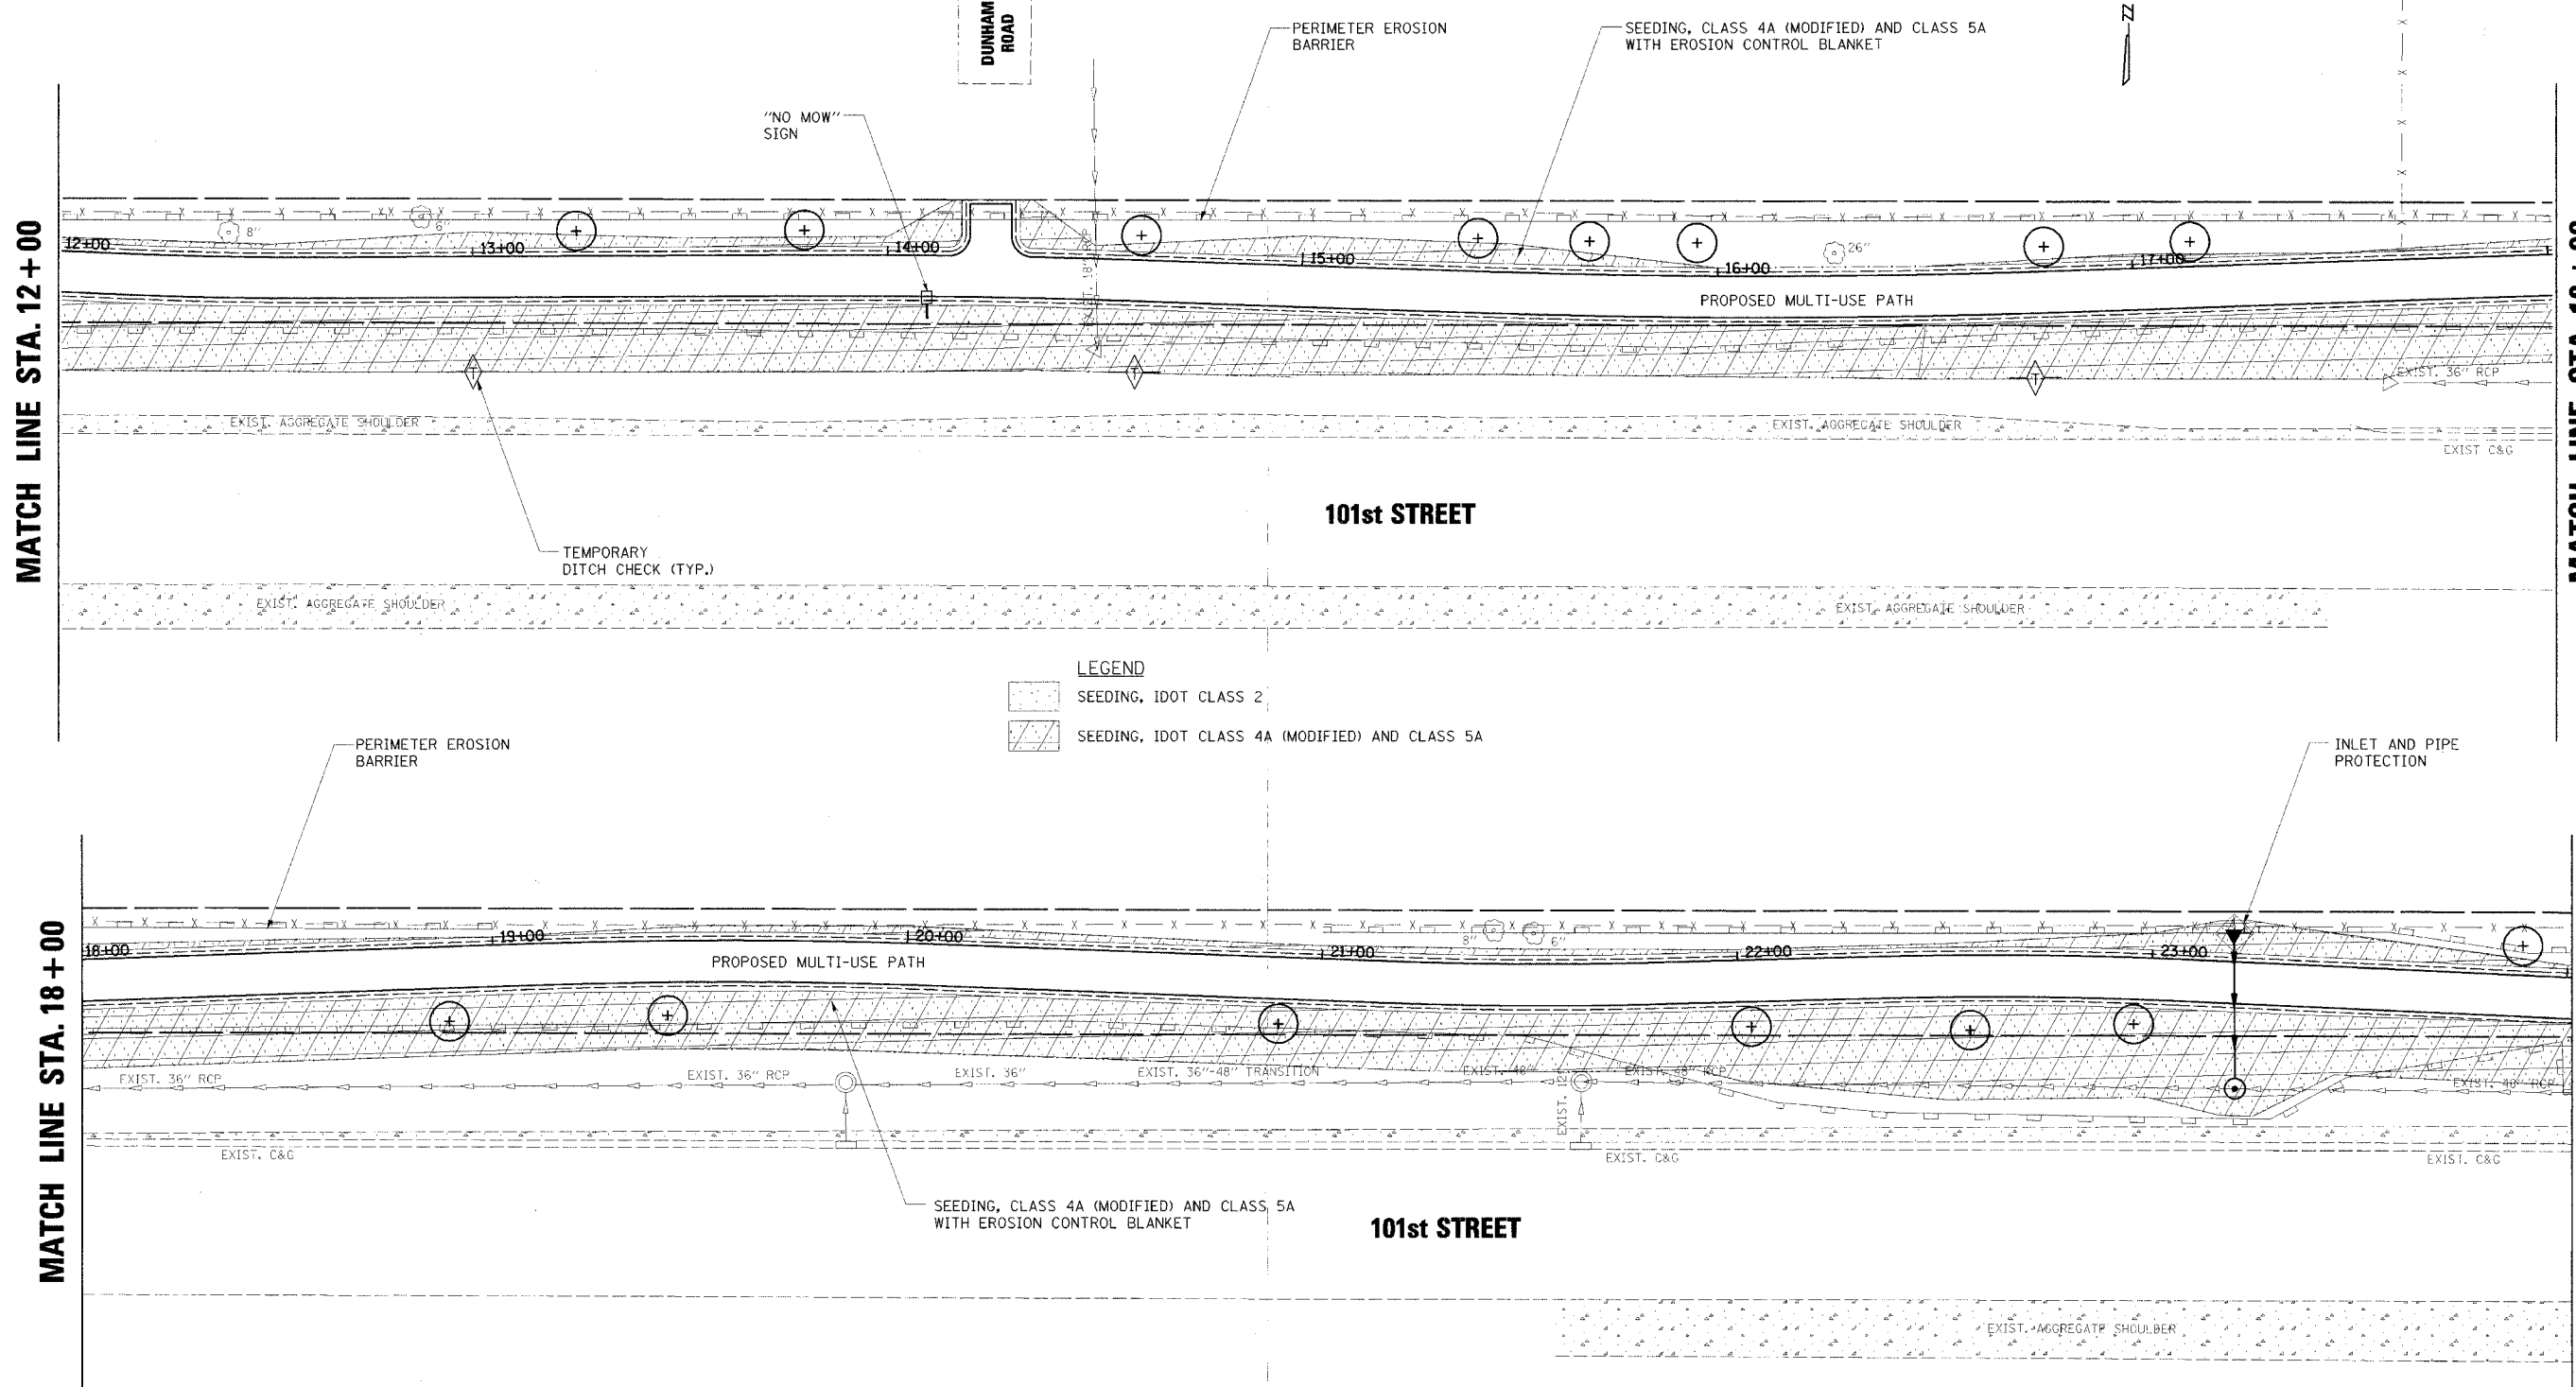

- LEGEND**
-  SEEDING, IDOT CLASS 2
 -  SEEDING, IDOT CLASS 4A (MODIFIED) AND CLASS 5A

8/10/2005 12:24:53 PM K:\11800001\06\001\Design\101_ER02.dgn

NO.	DATE	BY	REVISION

SCALE	1" = 20'
DRAWN BY	JMC DATE
CHECKED BY	MRH DATE
APPROVED BY	DWB DATE



R/N GROUP, INC.
CONSULTING ENGINEERS

PROJECT
**Southern DuPage County Regional Trail
101st Street Connector – Waterfall Glen Spur**

TITLE
**LANDSCAPING AND
EROSION CONTROL PLAN**

DATE	JUNE 9, 2005
PROJECT No.	11-1900-01
SHEET	