



DATE: _____
 BY: _____
 DESIGNED: _____
 DRAWN: _____
 CHECKED: _____
 DATE: _____

DATE: _____
 BY: _____
 DESIGNED: _____
 DRAWN: _____
 CHECKED: _____
 DATE: _____

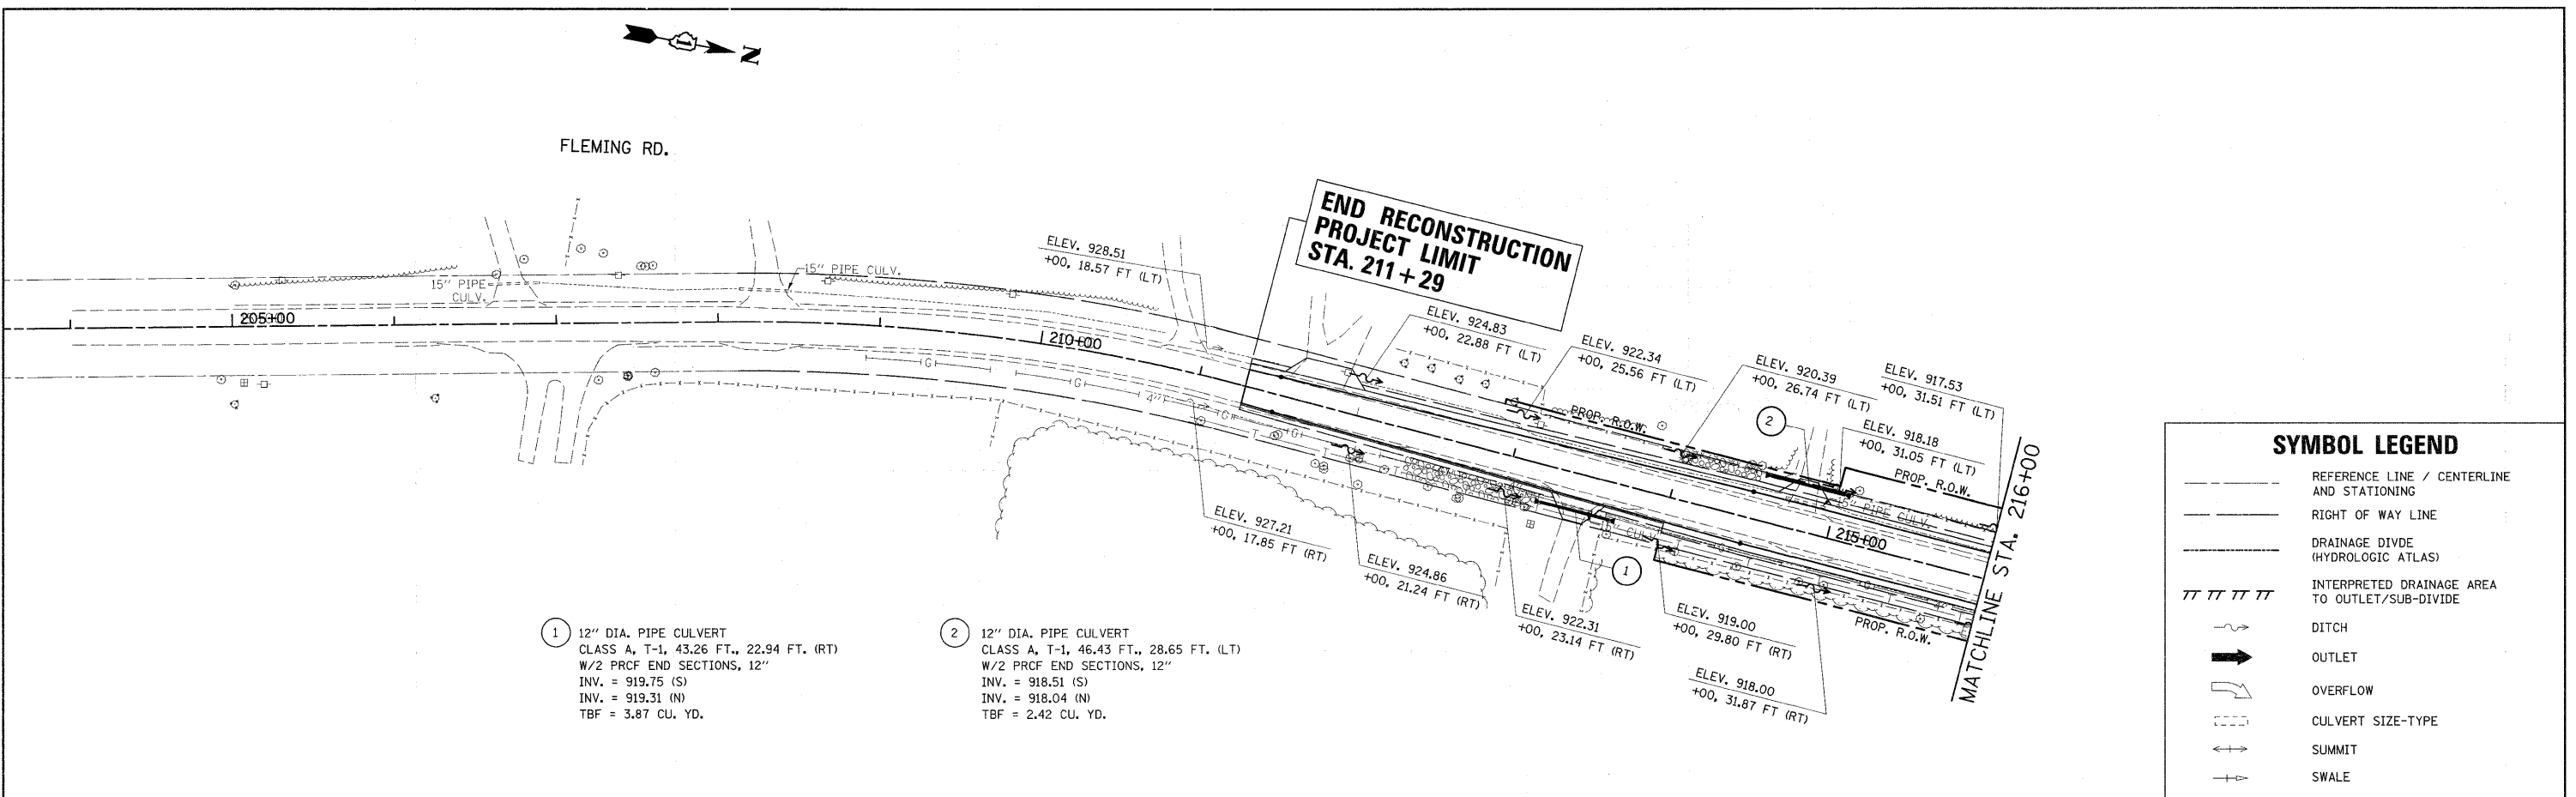

SYMBOL LEGEND

- REFERENCE LINE / CENTERLINE AND STATIONING
- RIGHT OF WAY LINE
- DRAINAGE DIVIDE (HYDROLOGIC ATLAS)
- ||||| INTERPRETED DRAINAGE AREA TO OUTLET/SUB-DIVIDE
- ~ DITCH
- ➔ OUTLET
- ↪ OVERFLOW
- CULVERT SIZE-TYPE
- ↕ SUMMIT
- ↕ SWALE

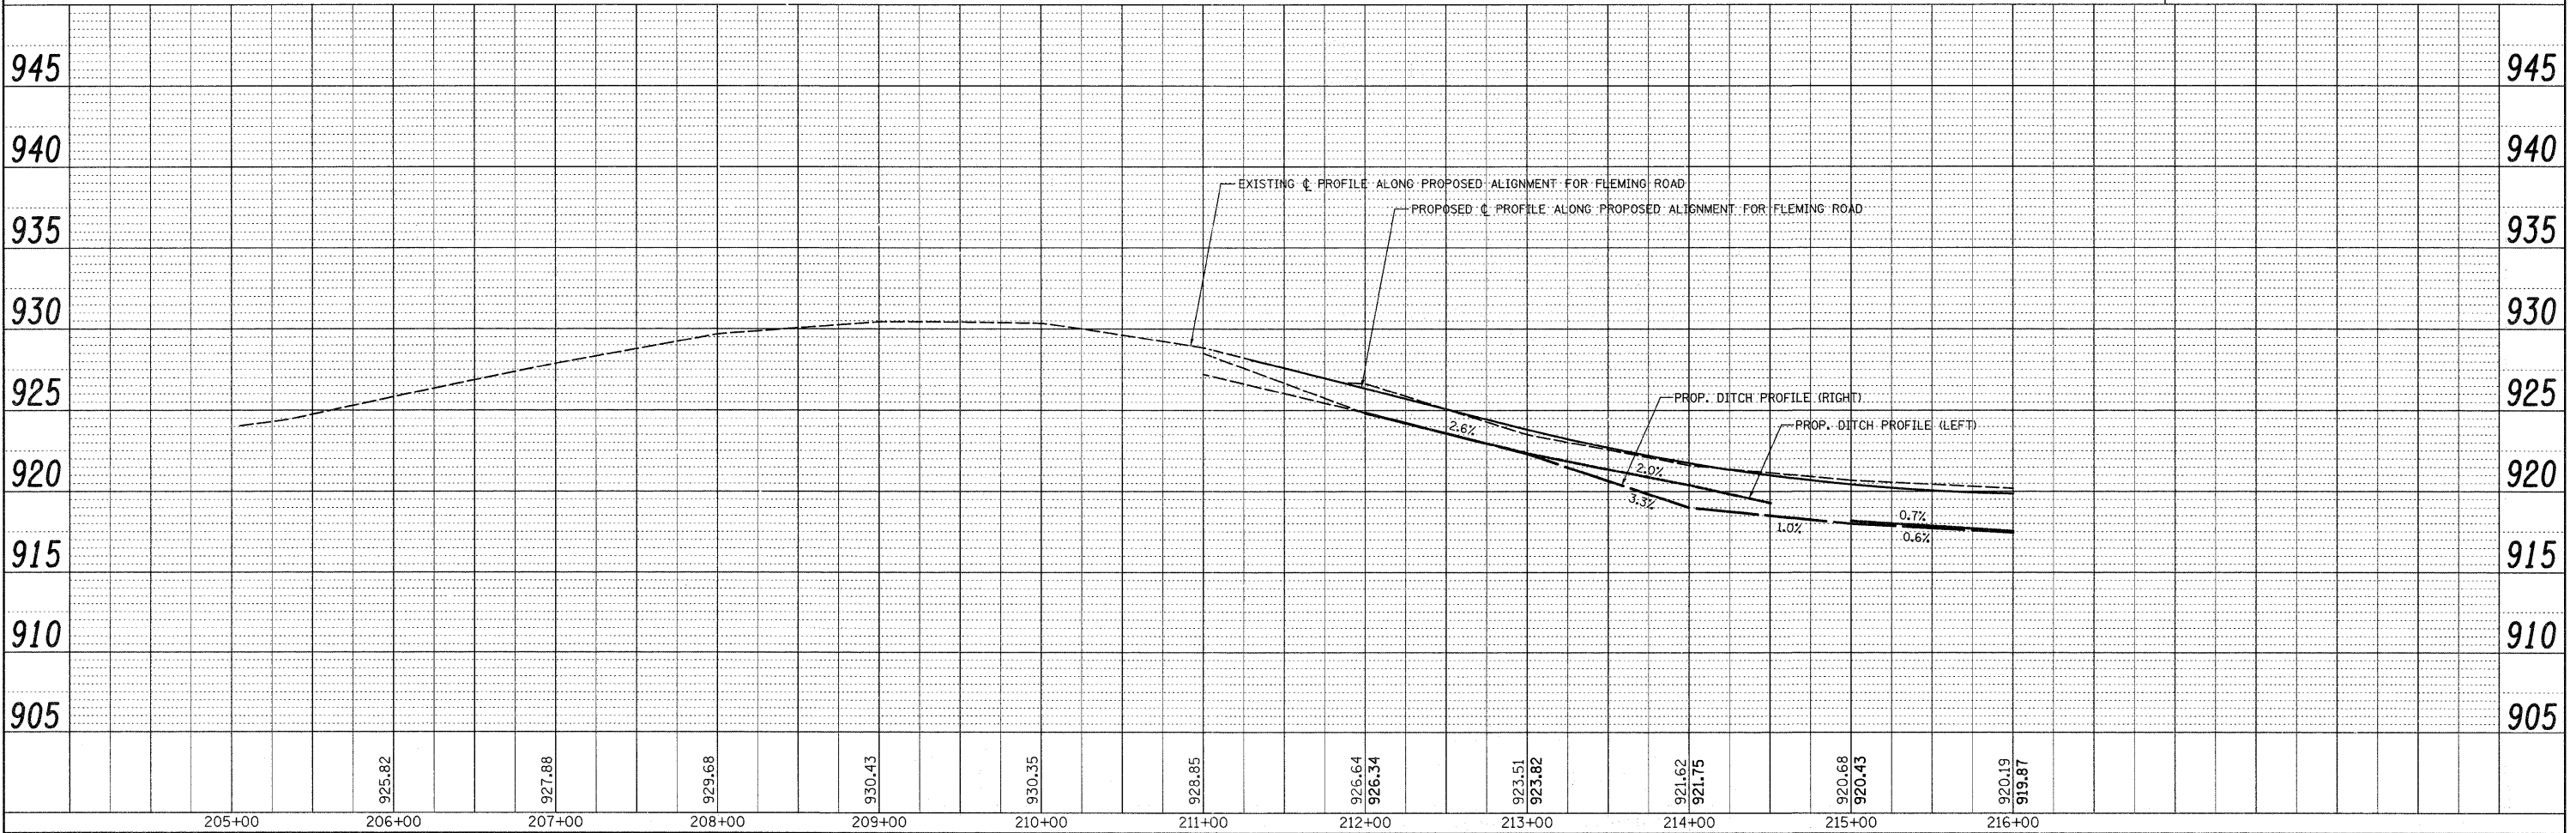

FILE NAME = P113707-shd-drain.dgn	USER NAME = bauer-dl	DESIGNED -	REVISED -	STATE OF ILLINOIS DEPARTMENT OF TRANSPORTATION	EXISTING AND PROPOSED DRAINAGE PLAN FLEMING RD IL. ROUTE 120			F.A.P. RTE. 333	SECTION 15-N-6	COUNTY MCHENRY	TOTAL SHEETS 67	SHEET NO. 27
		DRAWN -	REVISED -		SCALE: 1"=50'	SHEET NO. OF SHEETS	STA. 211+29 TO STA. 216+00	CONTRACT NO. 60L27				
		CHECKED -	REVISED -		ILLINOIS FED. AID PROJECT							
		DATE -	REVISED -									