


F.A.P. RTE.	SECTION	COUNTY	TOTAL SHEETS	SHEET NO.
307	I29 R-2	KANE	243	151
STA.		TO STA.		
FED. ROAD DIST. NO. 1		ILLINOIS	FED. AID PROJECT	

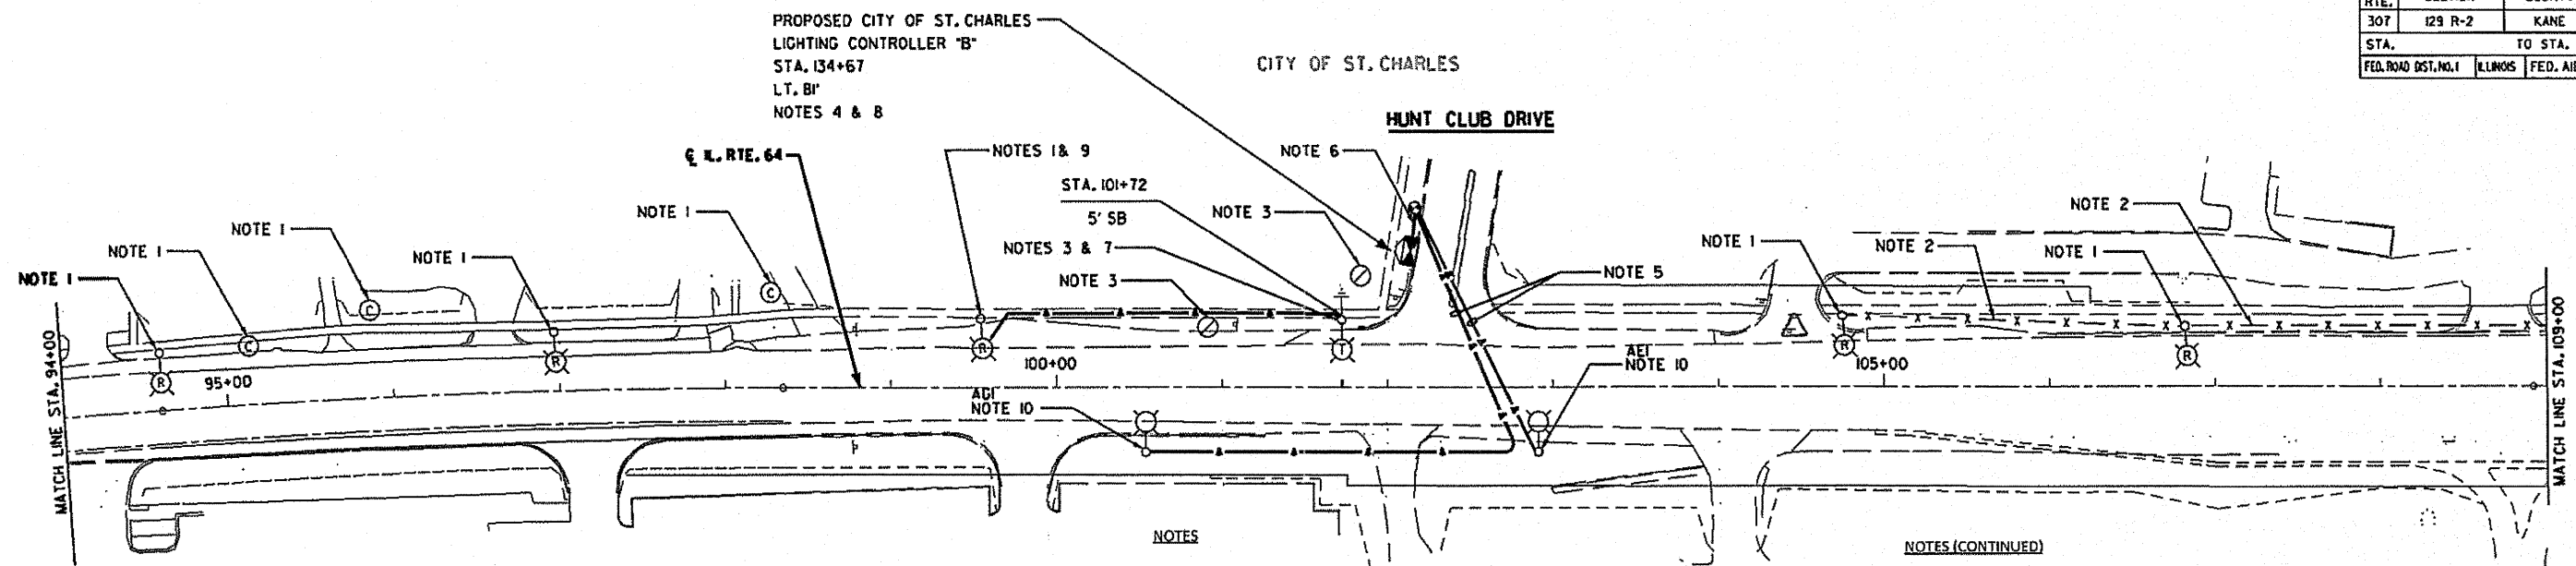


**NOTES**

- EXISTING LIGHTING UNIT AND ASSOCIATED CABLES AND WOOD POLES TO BE REMOVED AFTER STAGE 1 CONSTRUCTION IS COMPLETE AND PROPOSED LIGHT UNITS ON THE SOUTH SIDE OF IL RTE. 64 ARE OPERATIONAL UNLESS NOTED OTHERWISE. CONTRACTOR SHALL REMOVE ALL WOOD POLES ASSOCIATED WITH TEMPORARY LIGHTING, INCLUDING THOSE WOOD POLES WITH ONLY AERIAL CABLES BUT NO LUMINAIRES. LUMINAIRES, MAST ARMS AND POLES SHALL BE RETURNED TO SCEU FOR SALVAGE. REMOVAL COST FOR THESE WOOD POLES SHALL BE PAID FOR UNDER THE PAY ITEM FOR REMOVAL OF TEMPORARY LIGHT UNIT. COORDINATE REMOVAL WITH SCEU. CONTACT MR. GARY SITTLER, PHONE (630) 377-4407.
- AFTER STAGE 1 CONSTRUCTION IS COMPLETE AND PROPOSED LIGHT UNITS ON THE SOUTH SIDE OF IL RTE. 64 ARE OPERATIONAL, REMOVE CONDUCTORS FROM EXISTING RACEWAY BETWEEN POLES AND ABANDON RACEWAY IN PLACE.
- EXISTING WOOD POLES TO BE REMOVED BY COMCAST.
- INSTALL PROPOSED LIGHTING CONTROLLER DURING STAGE 1 CONSTRUCTION. DURING STAGE 2 CONSTRUCTION, CONTROLLER WILL BE USED TO FEED PROPOSED LIGHTING INSTALLED ON SOUTH SIDE OF IL RTE. 64. REFER TO SHEET LT-04 FOR ADDITIONAL CONTROLLER INSTALLATION INFORMATION.


**NOTES (CONTINUED)**

- FOR STAGE 2 CONSTRUCTION, INSTALL TEMPORARY AERIAL CABLE FEED FROM LIGHTING CONTROLLER TO PROPOSED LIGHTING UNITS ON SOUTH SIDE OF ILLINOIS ROUTE 64.
- 3" RGSC WITH (2) 3-1/C #4 AERIAL CABLE AND 1-1/C #6 GROUND FROM CONTROLLER TO TEMPORARY WOOD POLE FOR TEMPORARY FEEDS TO LIGHTING CIRCUITS ON SOUTH SIDE OF IL RTE. 64 DURING STAGE 2 CONSTRUCTION. GROUND CONDUCTOR SHALL BE INCLUDED IN THE PAY ITEM FOR AERIAL CABLE.
- SCEU WILL TERMINATE THE AERIAL CABLES AT THEIR 240-VOLT SECONDARY. CONTACT MR. GARY SITTLER, PHONE: (630) 377-4407.
- REFER TO SHEET LT-04 FOR CONTROLLER AND SERVICE INSTALLATION.
- ATTACH AERIAL CABLE TO POLE WITH A POLE BAND AND ROUTE THROUGH POLE CAP TO BASE OF POLE.
- PROPOSED LIGHTING UNIT INSTALLED DURING STAGE 1 CONSTRUCTION (REFER TO SHEET LT-04). ATTACH AERIAL CABLE TO POLE WITH A POLE BAND AND ROUTE THROUGH POLE CAP TO BASE OF POLE.

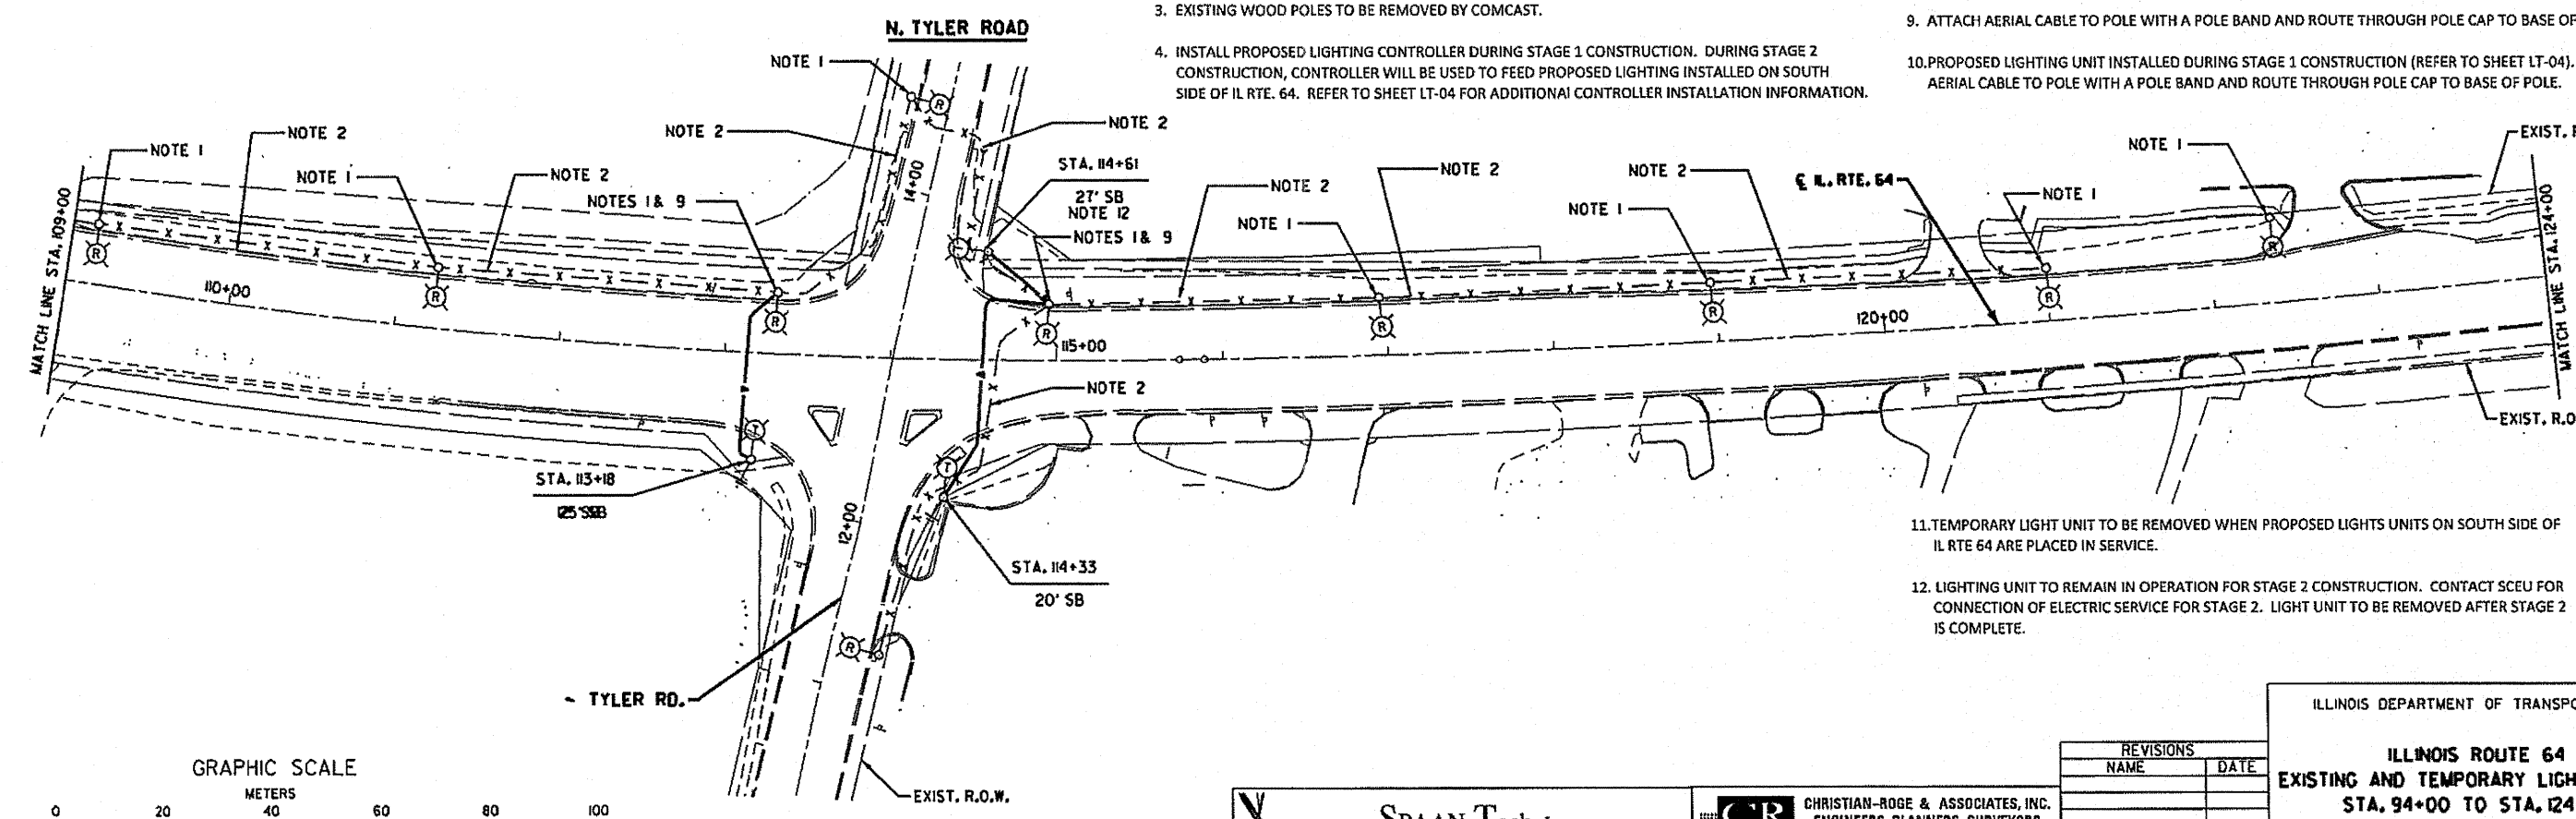

- TEMPORARY LIGHT UNIT TO BE REMOVED WHEN PROPOSED LIGHTS UNITS ON SOUTH SIDE OF IL RTE 64 ARE PLACED IN SERVICE.
- LIGHTING UNIT TO REMAIN IN OPERATION FOR STAGE 2 CONSTRUCTION. CONTACT SCEU FOR CONNECTION OF ELECTRIC SERVICE FOR STAGE 2. LIGHT UNIT TO BE REMOVED AFTER STAGE 2 IS COMPLETE.

LT-07

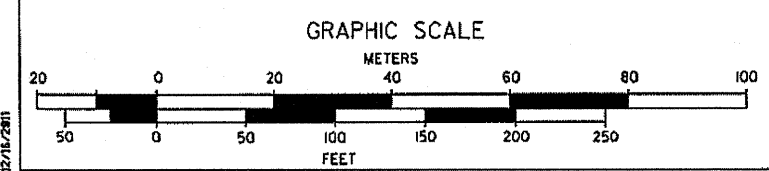

**S. TYLER ROAD**

**SPAAN Tech, Inc.**  
 311 South Wacker Drive, Suite 2400  
 Chicago, IL 60606  
 Phone: 312-277-8500  
 Fax: 312-277-8508  
 Web: www.SpaanTech.com

**CHRISTIAN-ROGE & ASSOCIATES, INC.**  
 ENGINEERS-PLANNERS-SURVEYORS  
 211 WEST WACKER DRIVE  
 CHICAGO, ILLINOIS 60606  
 1-312-372-2023 FAX: 1-312-372-5274

REVISIONS	
NAME	DATE

ILLINOIS DEPARTMENT OF TRANSPORTATION

**ILLINOIS ROUTE 64  
 EXISTING AND TEMPORARY LIGHTING PLAN  
 STA. 94+00 TO STA. 124+00**

VERT. N.A.  
 SCALE: HORIZ. 1" = 50'  
 DATE: SEPT. 2010

DRAWN BY: M. J./D. L.  
 CHECKED BY: I. B.