

F.A.P. RTE.	SECTION	COUNTY	TOTAL SHEETS	SHEET NO.
307	129 R-2	KANE	243	174
PLAN AND PROFILE		CONTRACT NO. 62195		
FED. ROAD DIST. NO.	ILLINOIS	FED. AID PROJECT		

WM-4

ROUTE 64 SUGGESTED STAGING AND PATCHING

IDOT STAGE I

A. INSTALLATION OF WATER MAIN FROM CONNECTION TO EXISTING WATER MAIN AT STA. 73+45±, LT. TO CONNECTION TO EXISTING WATER MAIN AT STA. 105+55±, RT.

WITHIN IDOT STAGE I CONSTRUCTION LIMITS FROM STA. 75+03, RT. TO STA. 105+55, RT.

IDOT STANDARD 701602 FOR DAILY LANE CLOSURES FOR CONNECTIONS AT STA. 73+45±, LT, STA. 86+41±, LT. AND STA. 90+62±, LT.

IDOT STANDARD 701602 FOR DAILY LANE CLOSURES ACROSS S. 8TH AVENUE, S. 9TH AVENUE, S. 10TH AVENUE, S. 11TH AVENUE AND S. 13TH AVENUE

PATCHING: CLASS C, 12" STA. 73+45±, LT TO STA. 73+75±, LT

TEMPORARY, 8" S. 8TH AVE., S. 9TH AVE.
S. 10TH AVE., N. 12TH AVE.
S. 13TH AVE., N. 13TH AVE.

B. INSTALLATION OF WATER MAIN LATERALS AND SERVICES, VALVE VAULT REMOVALS, CUT AND CAPS AND CONNECTIONS FROM STA. 73+45±, LT. TO STA. 105+55±, RT.

WITHIN IDOT STAGE I CONSTRUCTION LIMITS FROM STA. 75+03, RT. TO STA. 105+55, RT.




IDOT STANDARD 701602 FOR DAILY LANE CLOSURES FOR CONNECTIONS, REMOVALS, AND CUT AND CAPS.

PATCHING: CLASS C, 12" STA. 73+50±, LT (REM.)
STA. 74+35±, LT. (REM.)

CLASS B, 13" STA. 102+95±, LT. (REM.)

IDOT STAGE II

A. INSTALL WATER MAIN FROM DUNHAM TO ST. CHARLES PLACE.

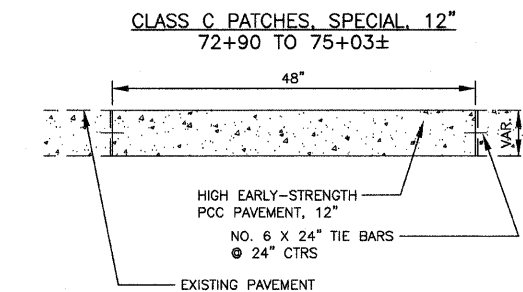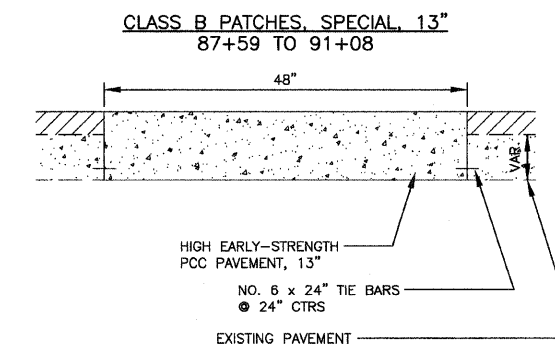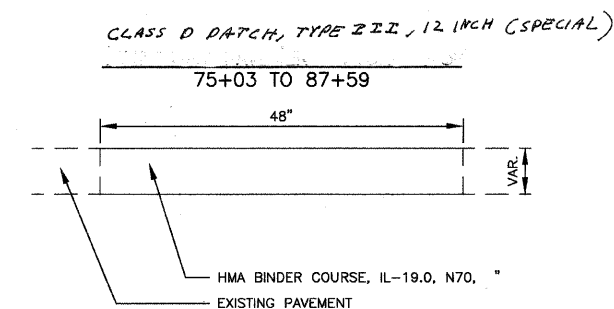

P:\2010\00186\card\IDOT WM\dwg\05014-notes.dwg Jun 17, 2011 10:11

FILE NAME =	USER NAME =	DESIGNED — LB	REVISED — 9-30-2010
		DRAWN — AC	REVISED — 10-15-2010
		CHECKED — AS	REVISED — 1-10-2011
PLOT DATE =	DATE — 9-17-2010		REVISED — 12-2-2011

**STATE OF ILLINOIS
DEPARTMENT OF TRANSPORTATION**

ILLINOIS RTE 64 SANITARY SEWER AND WATER MAIN IMPROVEMENTS		F.A.P. RTE.	SECTION	COUNTY	TOTAL SHEETS	SHEET NO.
STAGING AND PATCHING PLAN		307	129 R-2	KANE	243	WM-4
SCALE: N.T.S.		CITY OF ST. CHARLES		CONTRACT NO. 62195		
SHEET NO. OF SHEETS	STA. ___+___ TO STA. ___+___	FED. ROAD DIST. NO. 1 ILLINOIS FED. AID PROJECT				