


F.A.I. SECTION	COUNTY	TOTAL SHEETS	SHEET NO.
90/94 2003-03II	COOK	976	77
STA. 2024+00 TO STA. 2011+00			
FED. ROAD DIST. NO. ILLINOIS		FED. AID PROJECT	

62583

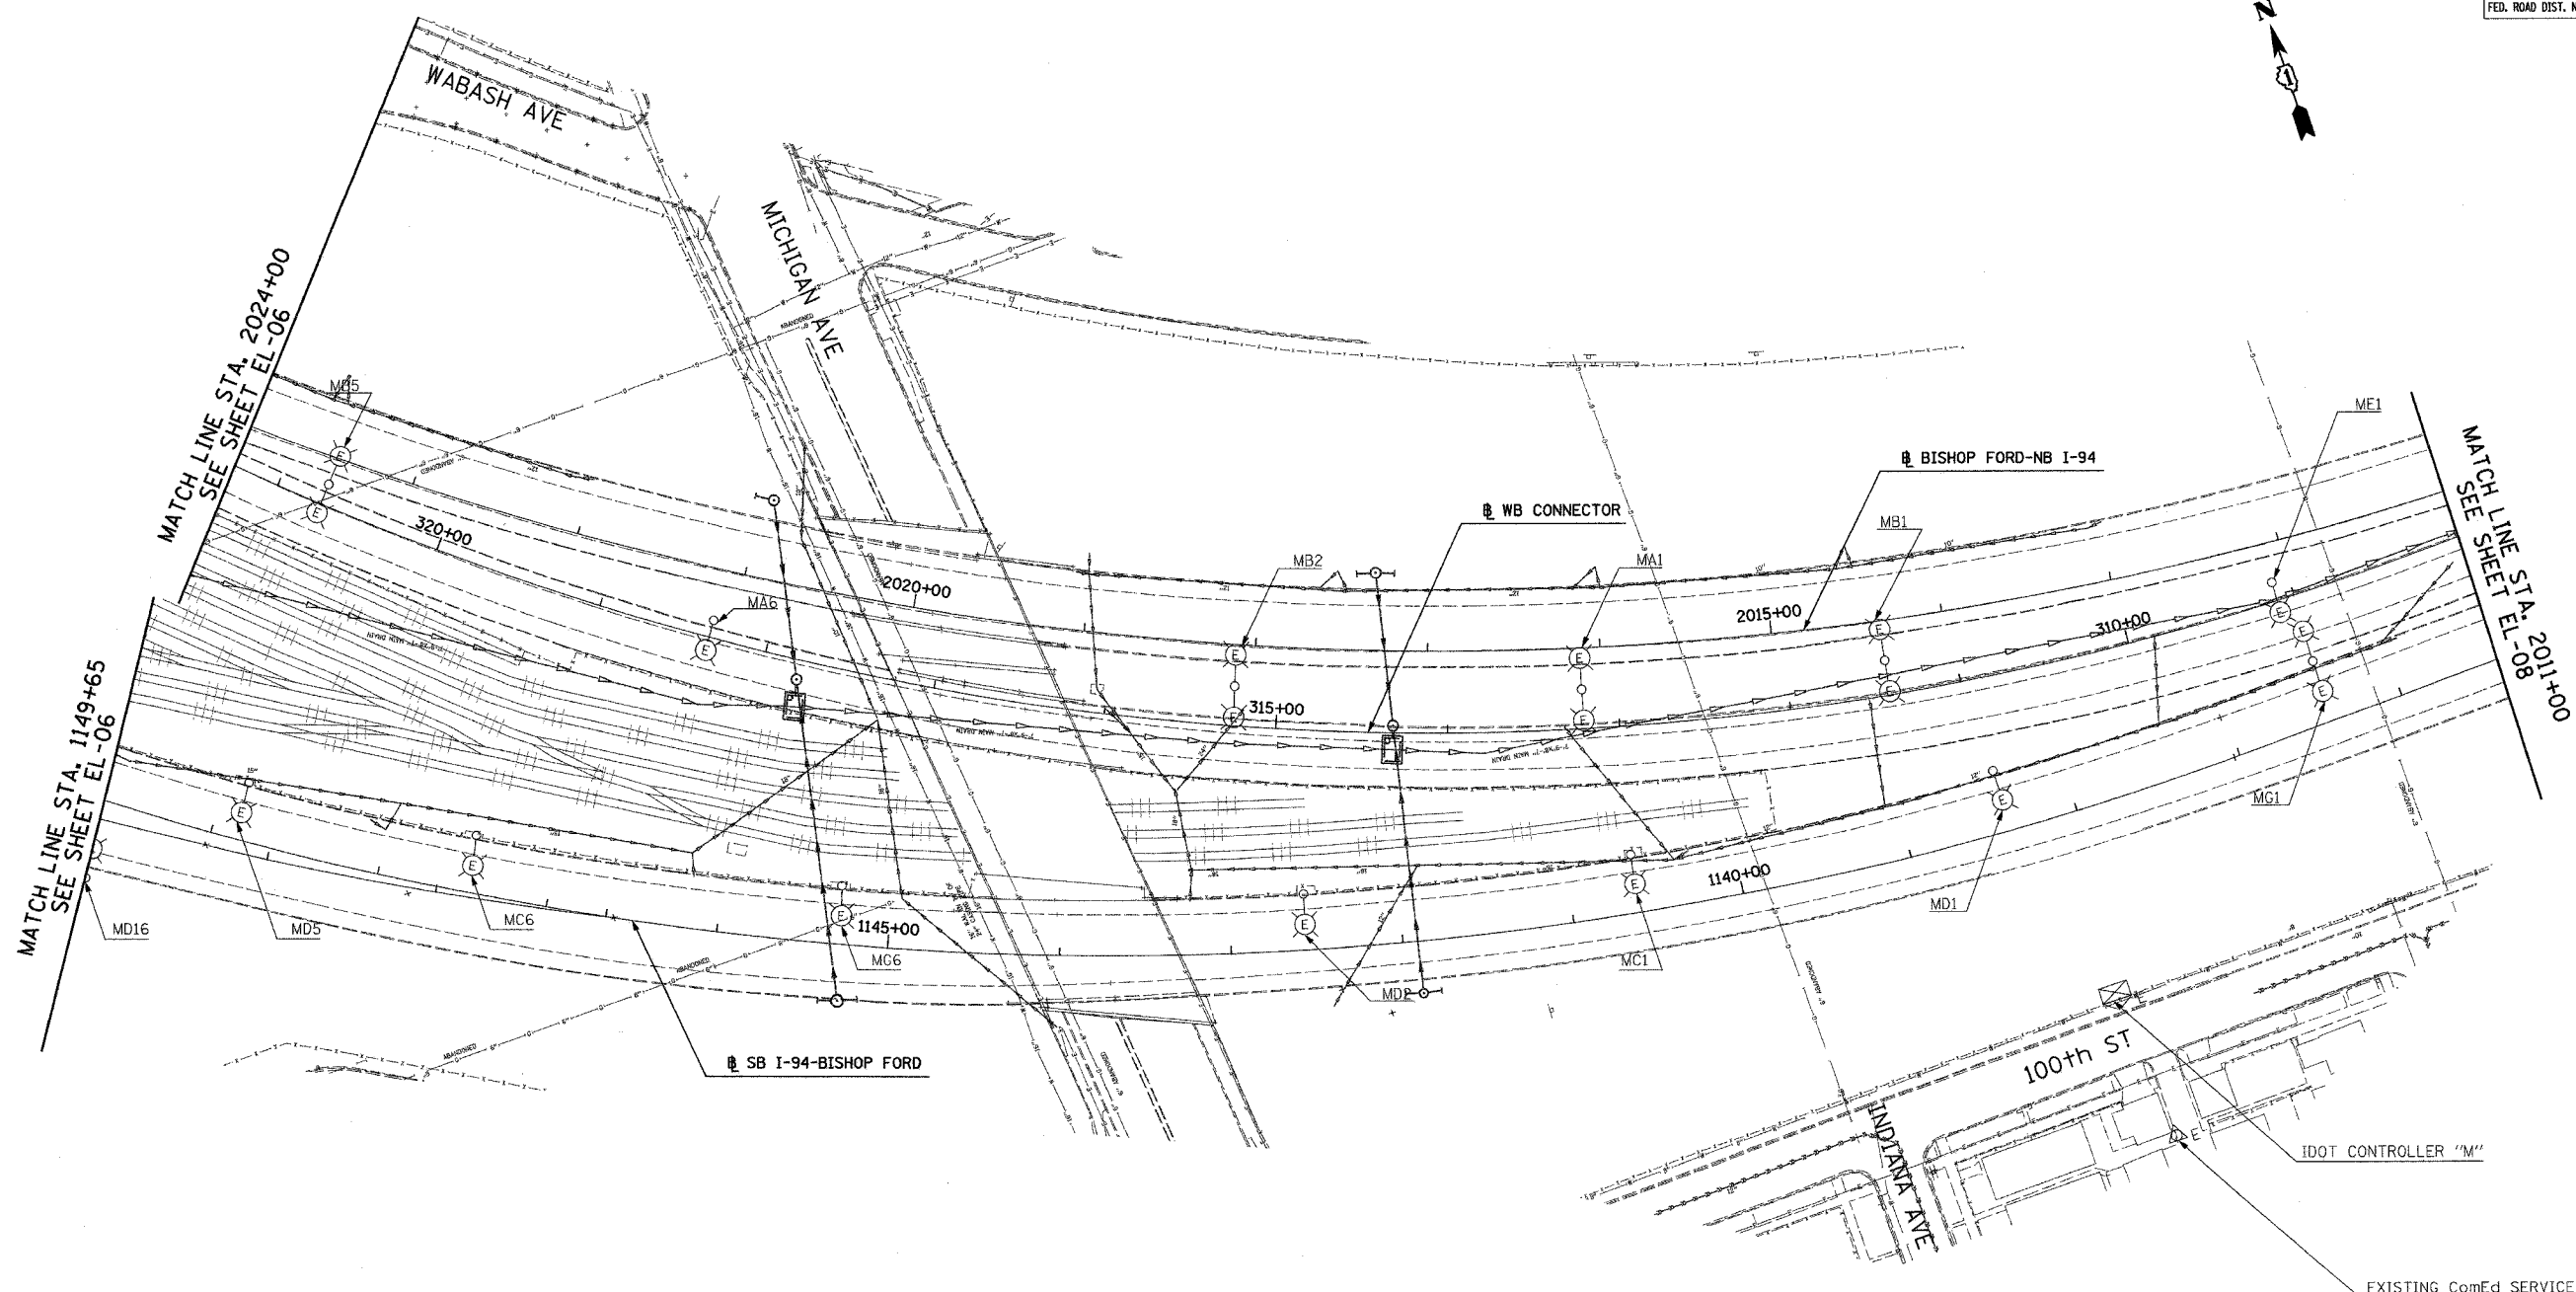

NO ELECTRICAL WORK THIS SHEET
FOR REFERENCE ONLY



EL-07

SINGH
SINGH & ASSOCIATES, INC.
CONSULTING ENGINEERS

300 W. ADAMS ST.
CHICAGO, IL 60608
TEL: (312) 629-0240
FAX: (312) 629-8449

REVISIONS	
NAME	DATE

ILLINOIS DEPARTMENT OF TRANSPORTATION
F.A.I. 90/94 (DAN RYAN EXPRESSWAY)
31st STREET TO I-57
ROADWAY LIGHTING PLANS EXISTING
CONDITIONS, TEMPORARY AND REMOVAL
SCALE: 1"=50'
DATE: OCTOBER 29, 2004
DRAWN BY: SP
CHECKED BY: TM

10/20/2004 6:03:28 PM