 



F.A.I. RTE.	SECTION	COUNTY	TOTAL SHEETS	SHEET NO.
90/94	2003-0311	COOK	976	31
STA. 142+00		TO STA. 1204+00		
FED. ROAD DIST. NO.		ILLINOIS	FED. AID PROJECT	

62583

NOTES:

- SEE DRAWINGS ME-01 AND ME-02 FOR ELECTRICAL SYMBOLS AND ABBREVIATIONS.
- THE EXISTING ROADWAY LIGHTING SYSTEM SHALL REMAIN IN OPERATION UNTIL THE PROPOSED ROADWAY LIGHTING SYSTEM HAS BEEN INSTALLED, ENERGIZED, TESTED, AND ACCEPTED BY THE ENGINEER, UNLESS OTHERWISE DIRECTED BY THE ENGINEER.
- UNLESS NOTED OTHERWISE, ALL ITEMS AND WORK SHOWN IN HEAVY LINE WEIGHT ON THIS DRAWING ARE PROPOSED NEW ITEMS OF WORK.
- SIGN SHALL BE DISCONNECTED BACK TO NEXT SPLICE. SIGN STRUCTURE AND LUMINAIRES SHALL BE REMOVED UNDER SEPARATE CONTRACT. COORDINATE WITH CONTRACTS 62694 AND 62695. NOTE: PROPOSED SIGN AT SHALL BE INSTALLED AND OPERATIONAL BEFORE EXISTING SIGN IS DISCONNECTED.
- REMOVAL OF LIGHT POLE AND LUMINAIRE ARE PART OF CONTRACT 62583. FOUNDATION REMOVAL SHALL BE PART OF CONTRACT 62694 AND 62695. COORDINATE REMOVAL SCHEDULE WITH CIVIL CONTRACTS 62694 AND 62695 OR AS OTHERWISE DIRECTED BY THE ENGINEER.

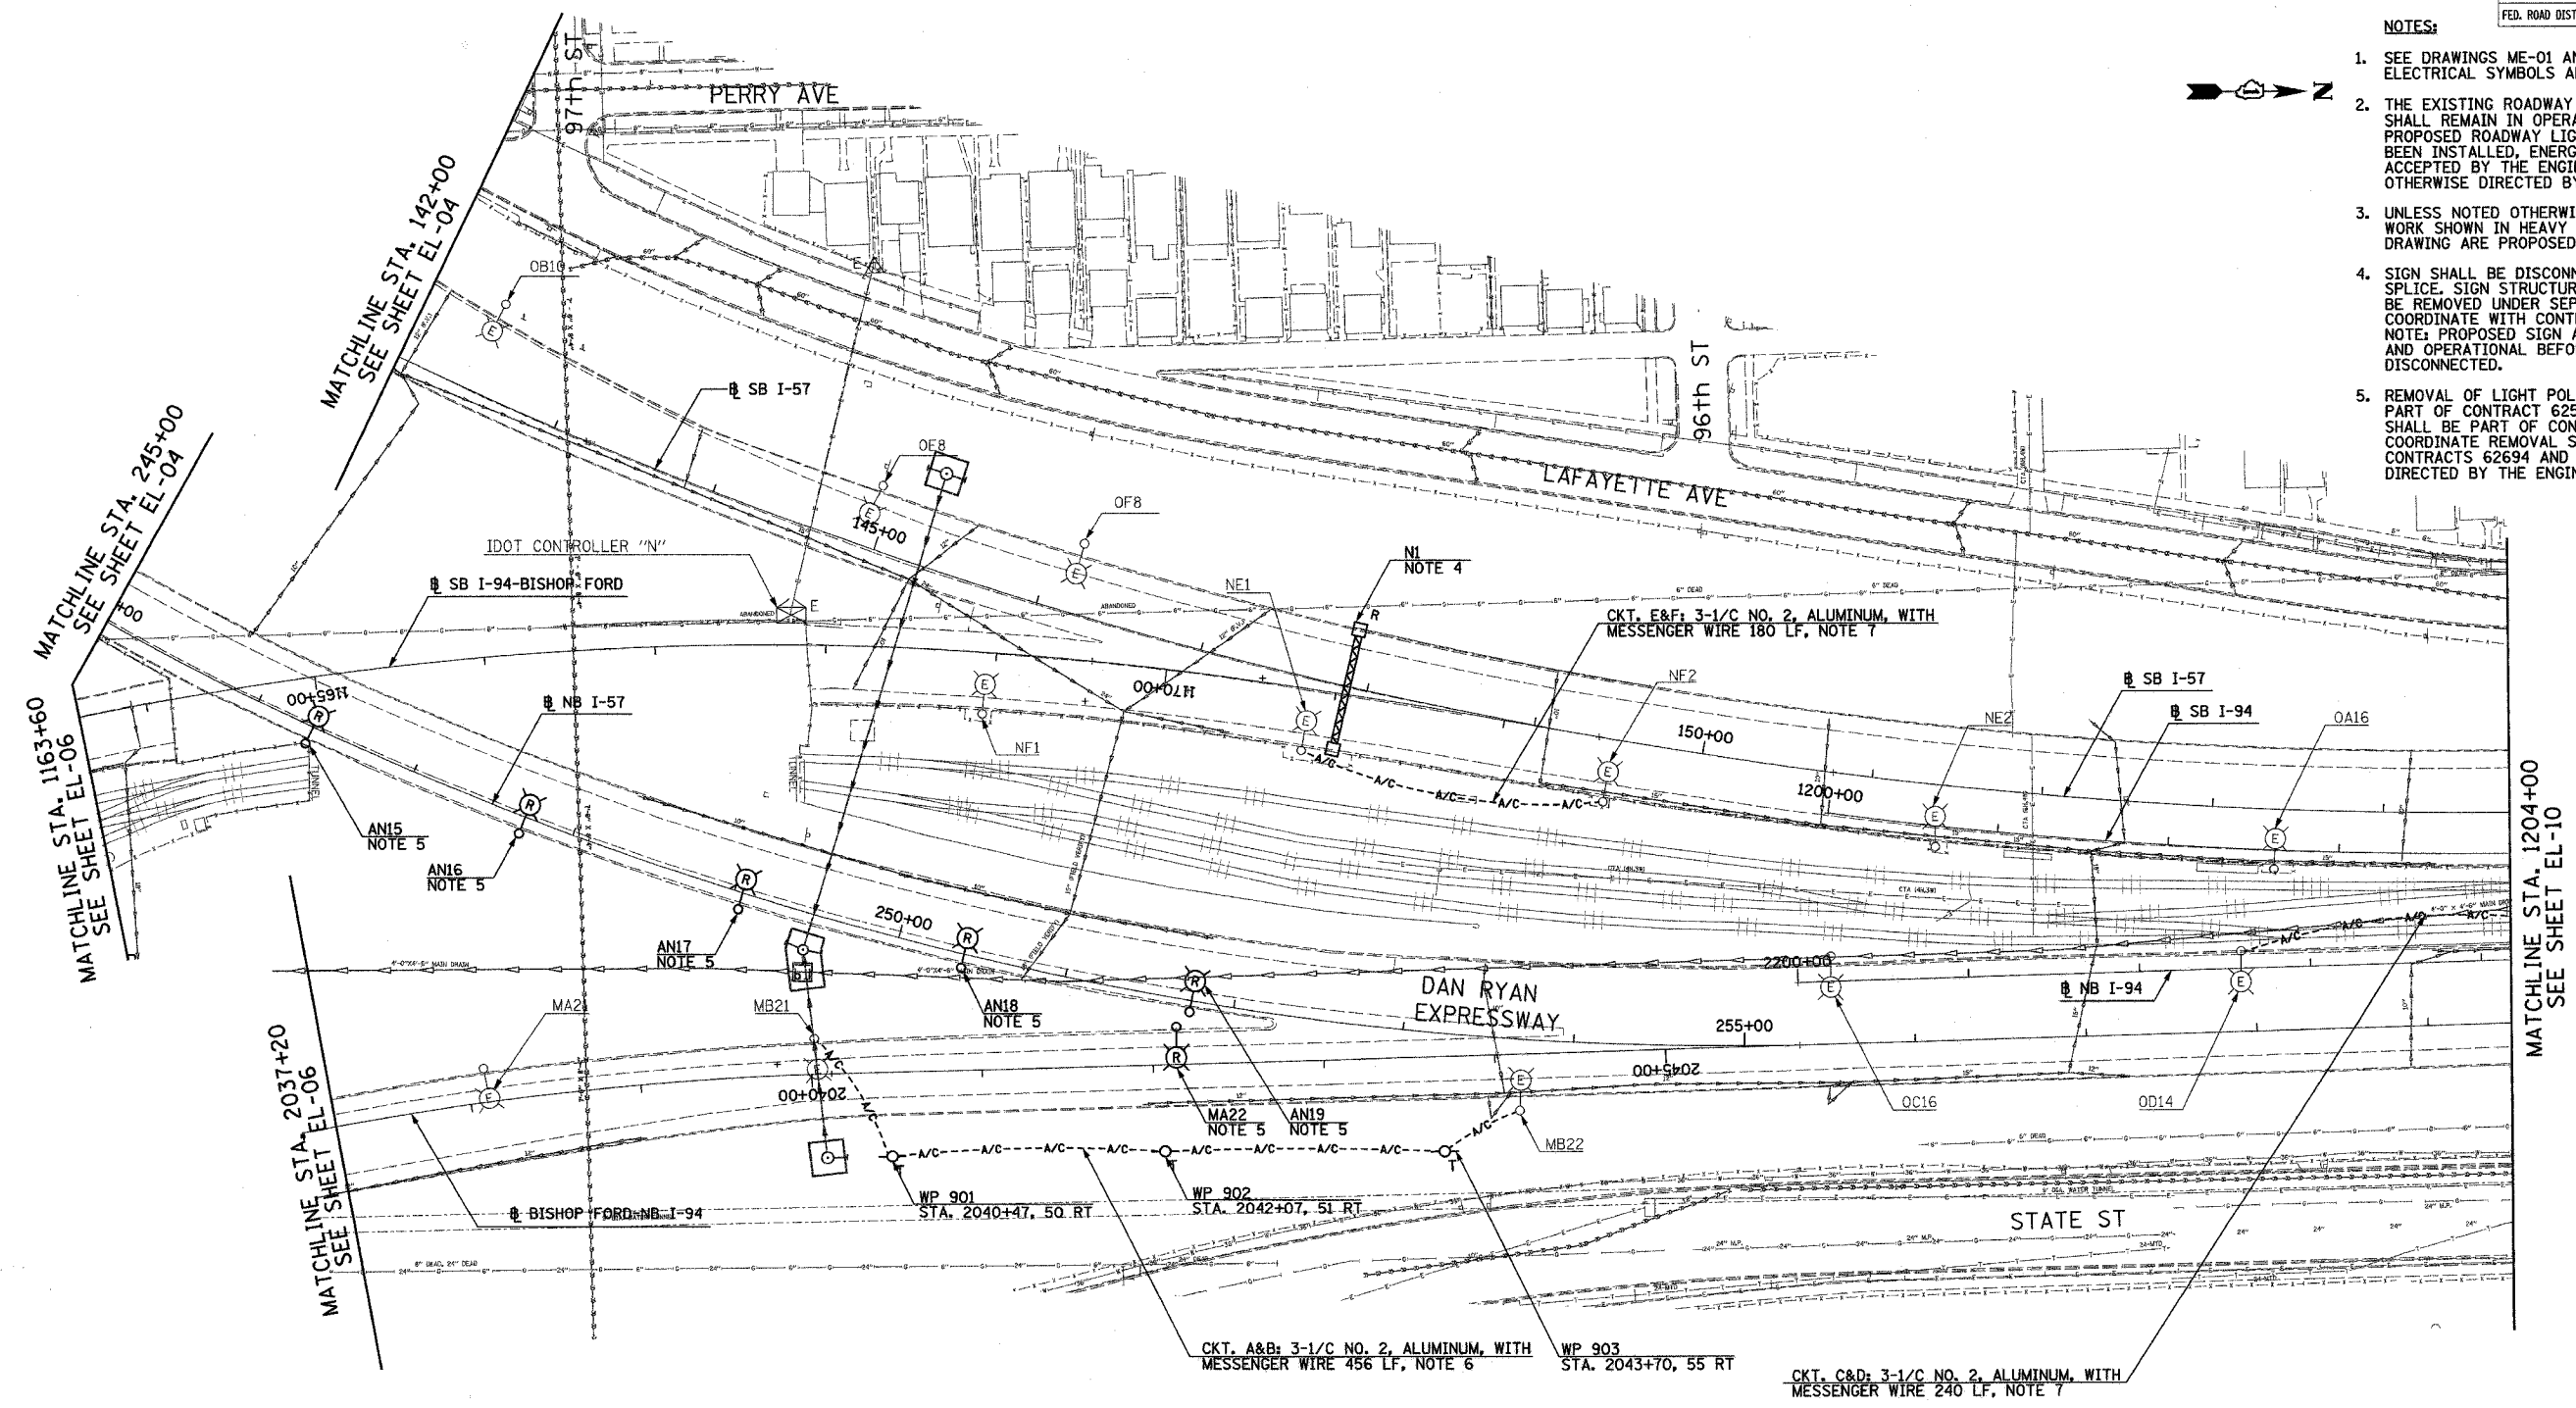

EL-09

NOTES CONTINUED:

- PROVIDE AERIAL CABLE BETWEEN EXISTING LIGHT POLES TO PROVIDE CONTINUITY BETWEEN POLE MB21 AND MB22 BEFORE REMOVAL OF POLE MA22.
- PROVIDE AERIAL CABLE BETWEEN EXISTING LIGHT POLES TO PERMIT REMOVAL OF SIGN UNDER SEPARATE CONTRACT. REFER SHEET ME-16.

REVISIONS	
NAME	DATE

ILLINOIS DEPARTMENT OF TRANSPORTATION  
 F.A.I. 90/94 (DAN RYAN EXPRESSWAY)  
 31st STREET TO I-57

ROADWAY LIGHTING PLANS EXISTING  
 CONDITIONS, TEMPORARY AND REMOVAL

SCALE: 1"=50'  
 DATE: OCTOBER 29, 2004

DRAWN BY: SP  
 CHECKED BY: TM

**SINGH**  
 SINGH & ASSOCIATES, INC.  
 CONSULTING ENGINEERS

300 W. ADAMS ST.  
 CHICAGO, IL 60606  
 TEL: (312) 629-0240  
 FAX: (312) 629-8449

10/29/2004 5:43:13 PM