 



F.A.I. RTE.	SECTION	COUNTY	TOTAL SHEETS	SHEET NO.
90/94	2003-0311	COOK	976	84
STA. 12030+00		TO STA. 1243+00		
FED. ROAD DIST. NO.		ILLINOIS FED. AID PROJECT		

62583



**NOTES:**


- SEE DRAWINGS ME-01 AND ME-02 FOR ELECTRICAL SYMBOLS AND ABBREVIATIONS.
- UNLESS NOTED OTHERWISE, ALL ITEMS AND WORK SHOWN IN HEAVY LINE WEIGHT ON THIS DRAWING ARE PROPOSED NEW ITEMS OF WORK.
- THE EXISTING ROADWAY LIGHTING SYSTEM SHALL REMAIN IN OPERATION UNTIL THE PROPOSED ROADWAY LIGHTING SYSTEM HAS BEEN INSTALLED, ENERGIZED, TESTED, AND ACCEPTED BY THE ENGINEER, UNLESS OTHERWISE DIRECTED BY THE ENGINEER.
- SIGN SHALL BE DISCONNECTED BACK TO NEXT SPLICE. SIGN STRUCTURE AND LUMINAIRES SHALL BE REMOVED UNDER SEPARATE CONTRACT. COORDINATE WITH CONTRACTS 62694 AND 62695. NOTE: SIGN 04 TO REMAIN LIT UNTIL 79th ST. AND 87th ST. RAMP ARE CLOSED OR AS DIRECTED BY THE ENGINEER. NOTE: PROPOSED SIGN 08 SHALL BE INSTALLED AND OPERATIONAL BEFORE EXISTING SIGN 03 IS DISCONNECTED.
- PROVIDE AERIAL CABLE BETWEEN EXISTING LIGHT POLES TO PERMIT REMOVAL OF SIGN UNDER SEPARATE CONTRACT. REFER TO SHEET ME-16.

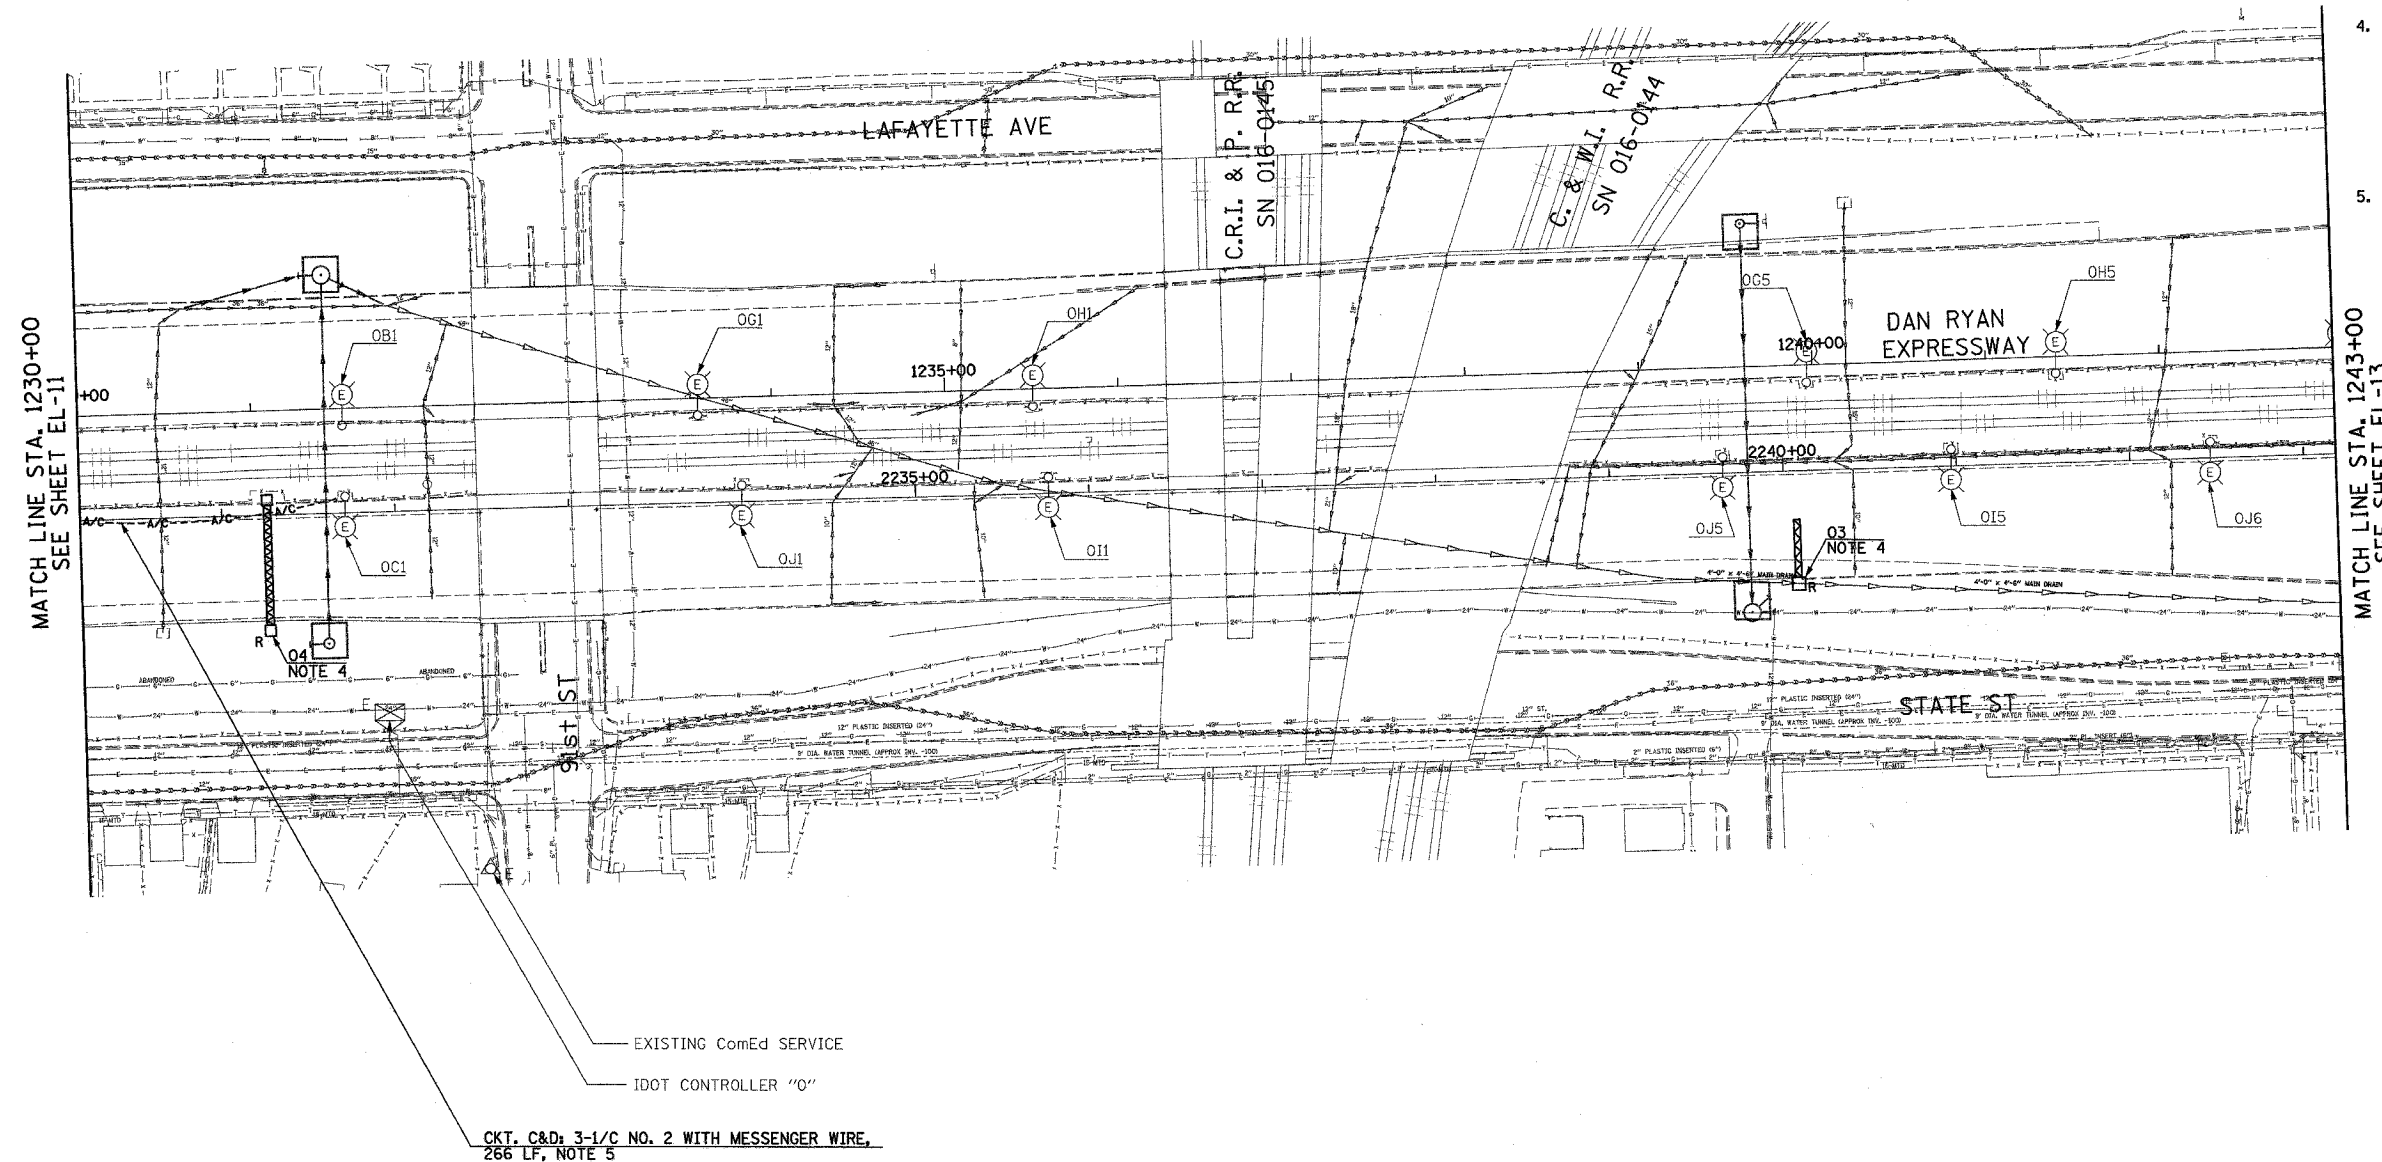

MATCH LINE STA. 1230+00  
SEE SHEET EL-11

MATCH LINE STA. 1243+00  
SEE SHEET EL-13

 EXISTING ComEd SERVICE  
IDOT CONTROLLER "O"  
CKT. C&D: 3-1/C NO. 2 WITH MESSENGER WIRE,  
266 LF, NOTE 5



EL-12

REVISIONS	
NAME	DATE

ILLINOIS DEPARTMENT OF TRANSPORTATION  
F.A.I. 90/94 (DAN RYAN EXPRESSWAY)  
31st STREET TO I-57  
  
ROADWAY LIGHTING PLANS EXISTING  
CONDITIONS, TEMPORARY AND REMOVAL  
  
SCALE: 1"=50'  
DATE: OCTOBER 29, 2004  
DRAWN BY: SP  
CHECKED BY: TM

**SINGH**  
SINGH & ASSOCIATES, INC.  
CONSULTING ENGINEERS  
300 W. ADAMS ST.  
CHICAGO, IL 60606  
TEL: (312) 629-0240  
FAX: (312) 629-8449

10/20/2004 6:00 PM