


F.A.I. RTE.	SECTION	COUNTY	TOTAL SHEETS	SHEET NO.
94/90	2003-0311	COOK	976	111
STA. 1536+00	TO STA. 1548+00			
FED. ROAD DIST. NO.	ILLINOIS FED. AID PROJECT			
62583				

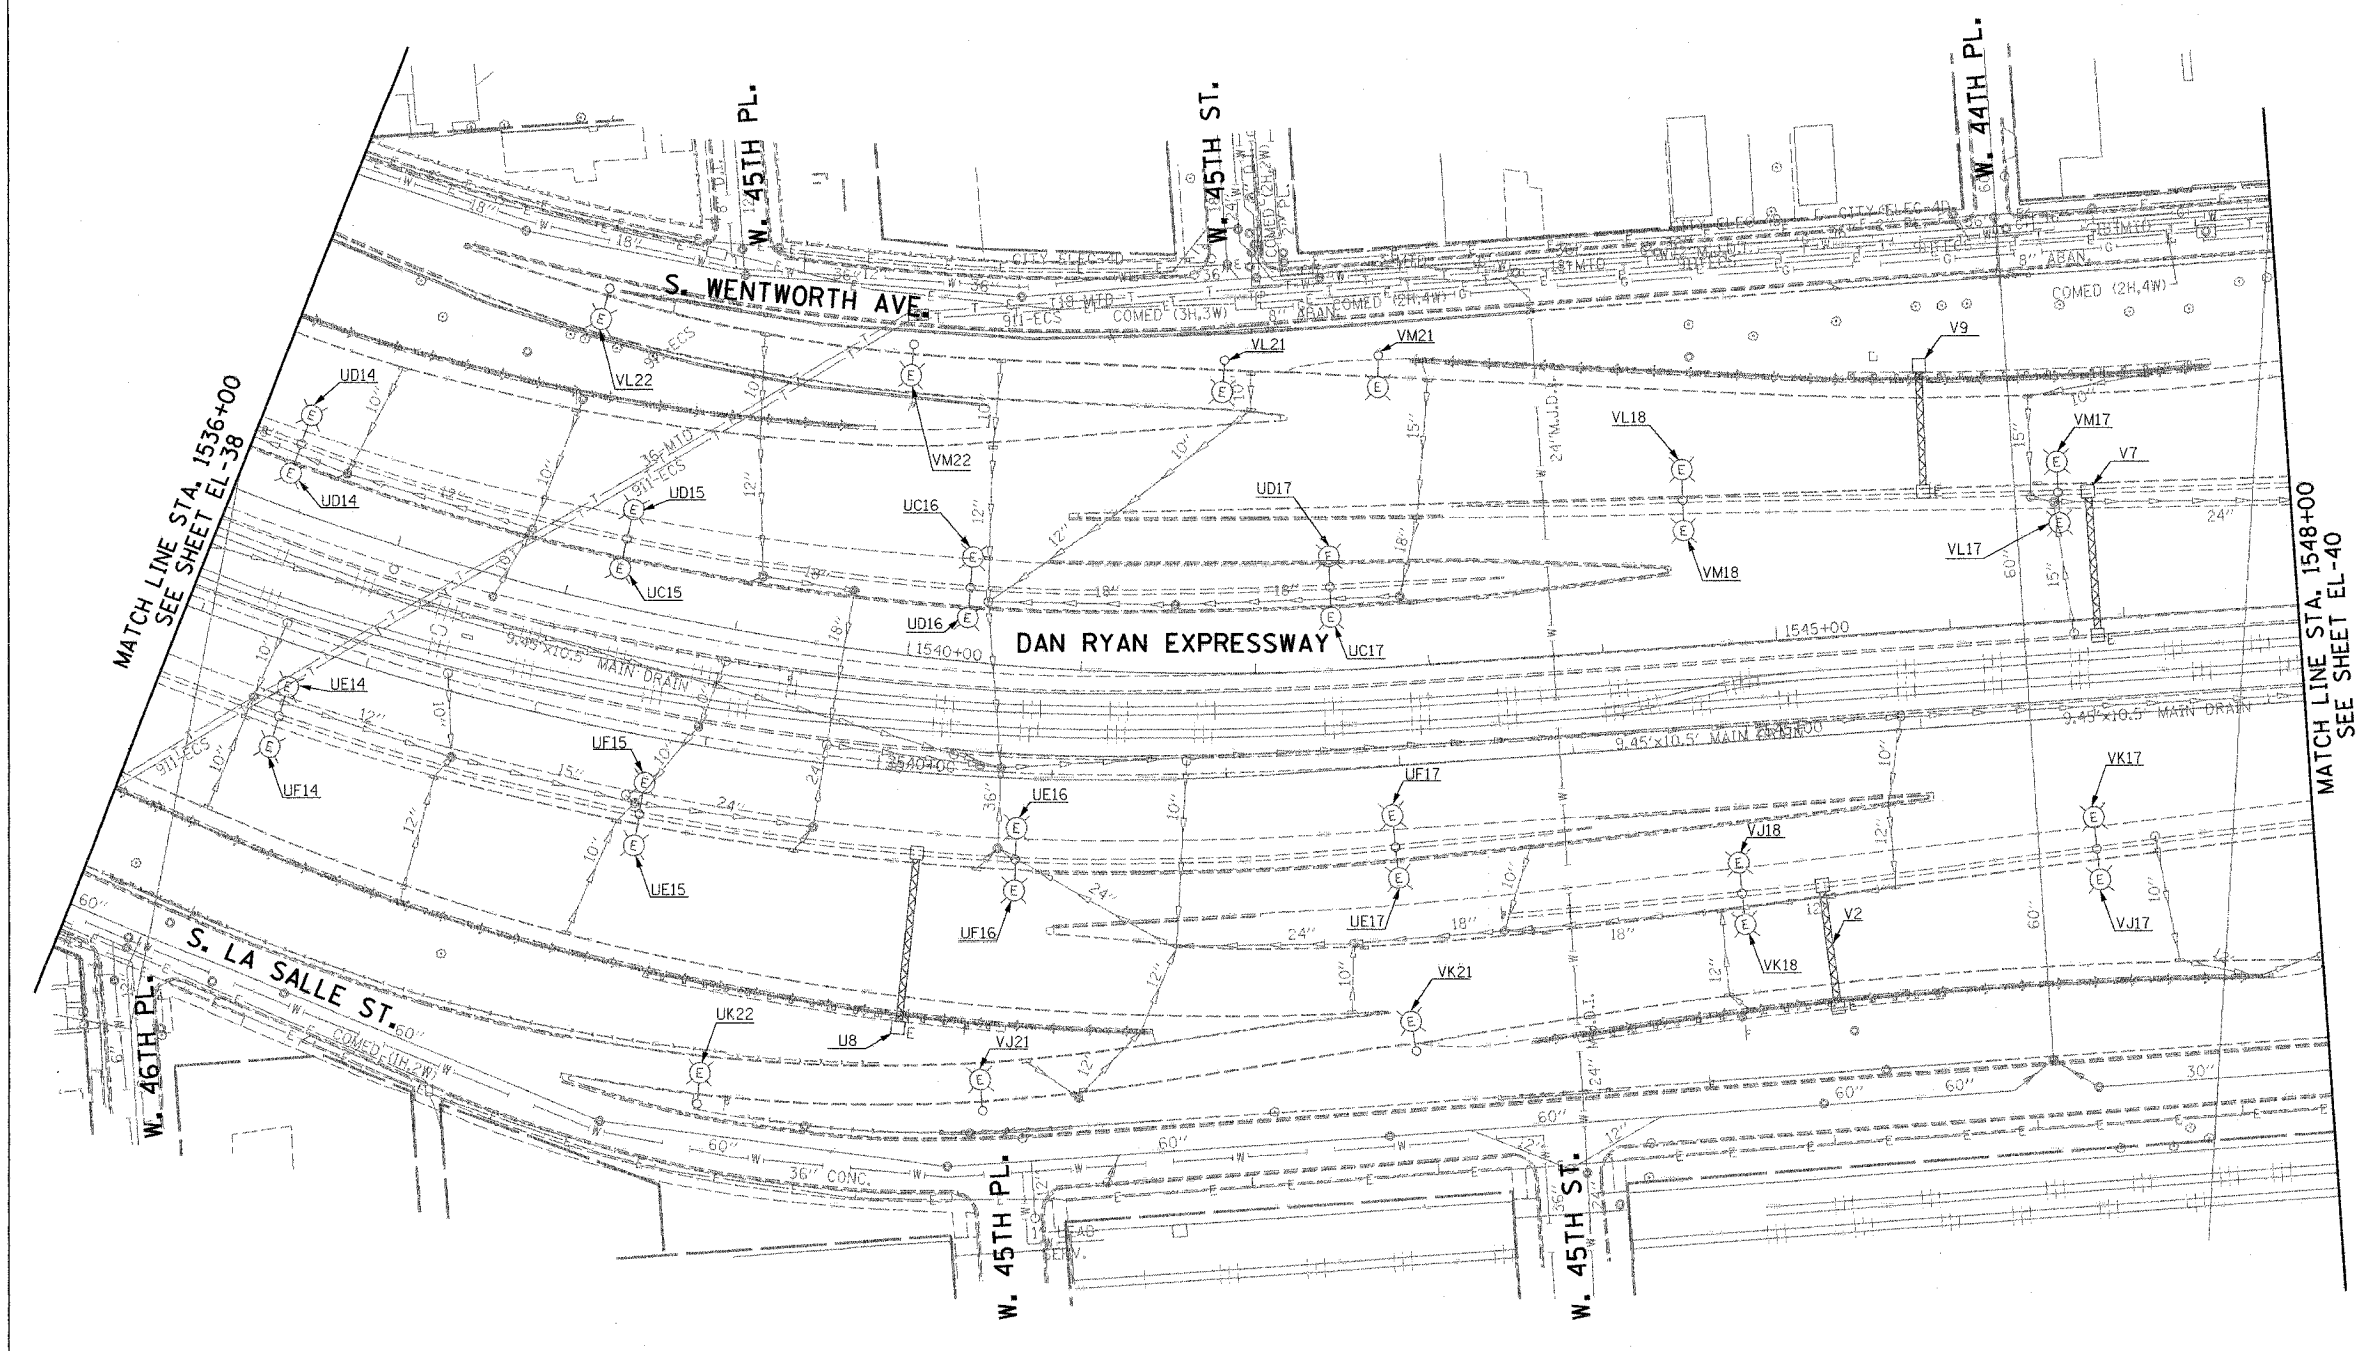

**NOTES:**  
 1. SEE DRAWINGS ME-01 AND ME-02 FOR ELECTRICAL SYMBOLS, AND ABBREVIATIONS.



**KAM ENGINEERING, INC.**  
 CONSULTING ENGINEERS  
 707A Davis Road, Suite 205  
 Elgin, Illinois 60123-1369



REVISIONS	
NAME	DATE

ILLINOIS DEPARTMENT OF TRANSPORTATION  
 F.A.I. 94/90 (DAN RYAN EXPRESSWAY)  
 31st STREET TO I-57

**ROADWAY LIGHTING PLANS**  
**EXISTING CONDITIONS AND DEMOLITION**

SCALE: 1"=50'  
 DATE: OCTOBER 29, 2004

DRAWN BY: BL  
 CHECKED BY: SM

EL-39

10/15/2004 08:54:27 AM C:\p0\refr\ub\_395\Lighting\EL020391.dwg