


F.A.I. RTE.	SECTION	COUNTY	TOTAL SHEETS	SHEET NO.
94/90	2003-0311	COOK	976	120
STA. 1644+00		TO STA.		
FED. ROAD DIST. NO.	ILLINOIS	FED. AID PROJECT		
62583				



 
NOTES:  
 1. SEE DRAWINGS ME-01 AND ME-02 FOR ELECTRICAL SYMBOLS, AND ABBREVIATIONS.

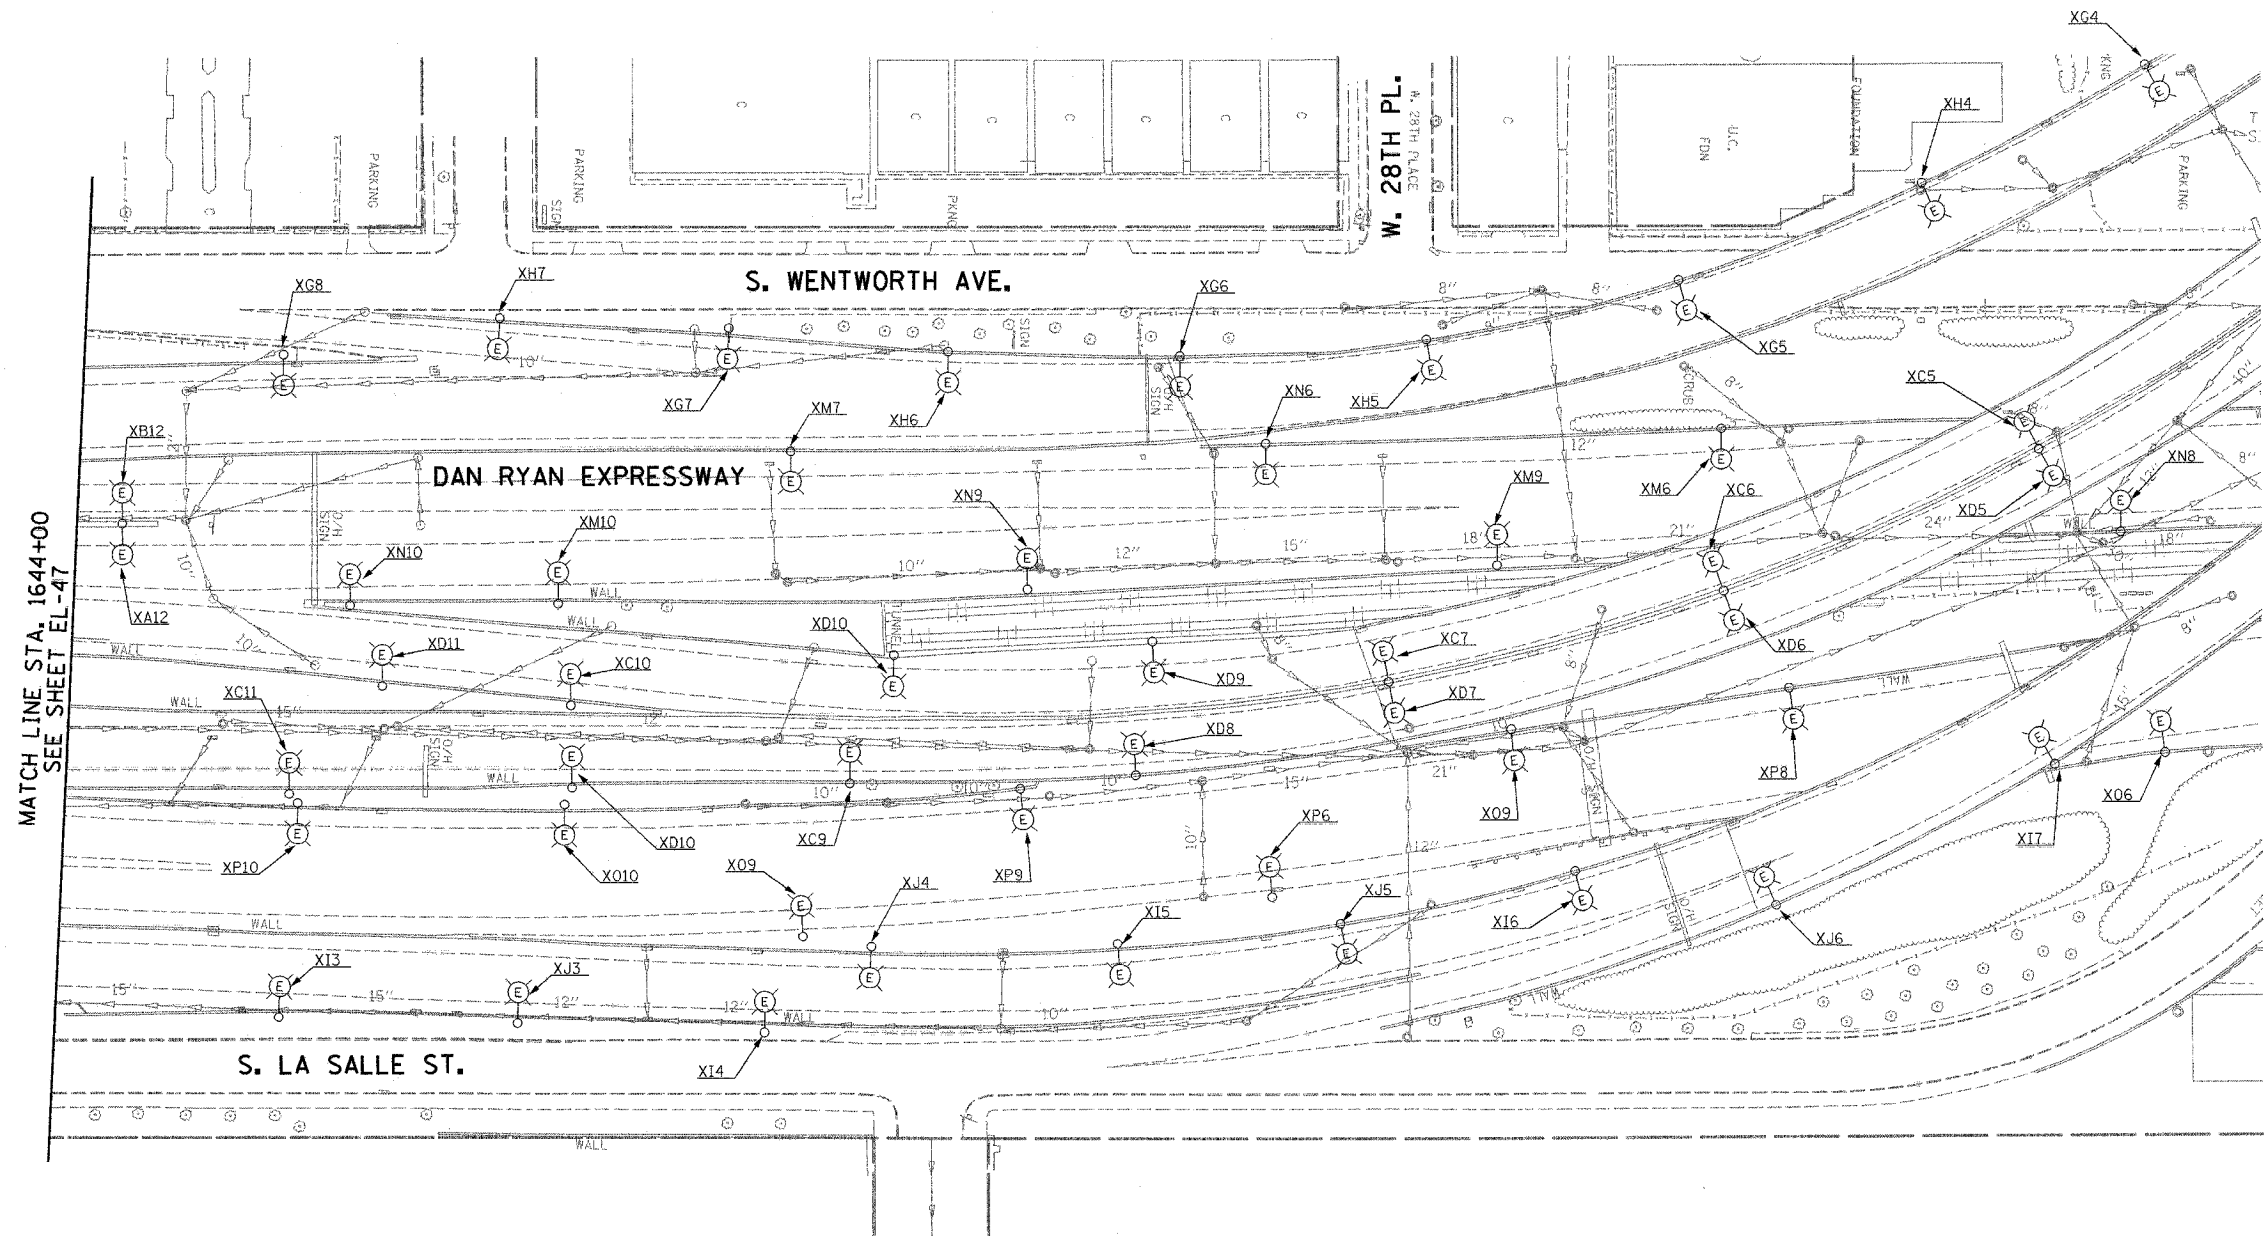

MATCH LINE STA. 1644+00  
SEE SHEET EL-47

EL-48

**KAM ENGINEERING, INC.**  
 CONSULTING ENGINEERS  
 707A Davis Road, Suite 205  
 Elgin, Illinois 60123-1369



REVISIONS	
NAME	DATE

ILLINOIS DEPARTMENT OF TRANSPORTATION  
 F.A.I. 94/90 (DAN RYAN EXPRESSWAY)  
 31st STREET TO I-57

**ROADWAY LIGHTING PLANS**  
**EXISTING CONDITIONS AND DEMOLITION**

SCALE: 1"=50'  
 DATE: OCTOBER 29, 2004  
 DRAWN BY: BL  
 CHECKED BY: SM

09/28/04 10:15:20 AM