


F.A.I. RTE.	SECTION	COUNTY	TOTAL SHEETS	SHEET NO.
90/94	2003-03II	COOK	976	127
STA. 90+00	TO STA. 103+00			
FED. ROAD DIST. NO.	ILLINOIS	FED. AID PROJECT	62583	

 


- NOTES:
- SEE DRAWINGS ME-01 AND ME-02 FOR ELECTRICAL SYMBOLS AND ABBREVIATIONS.

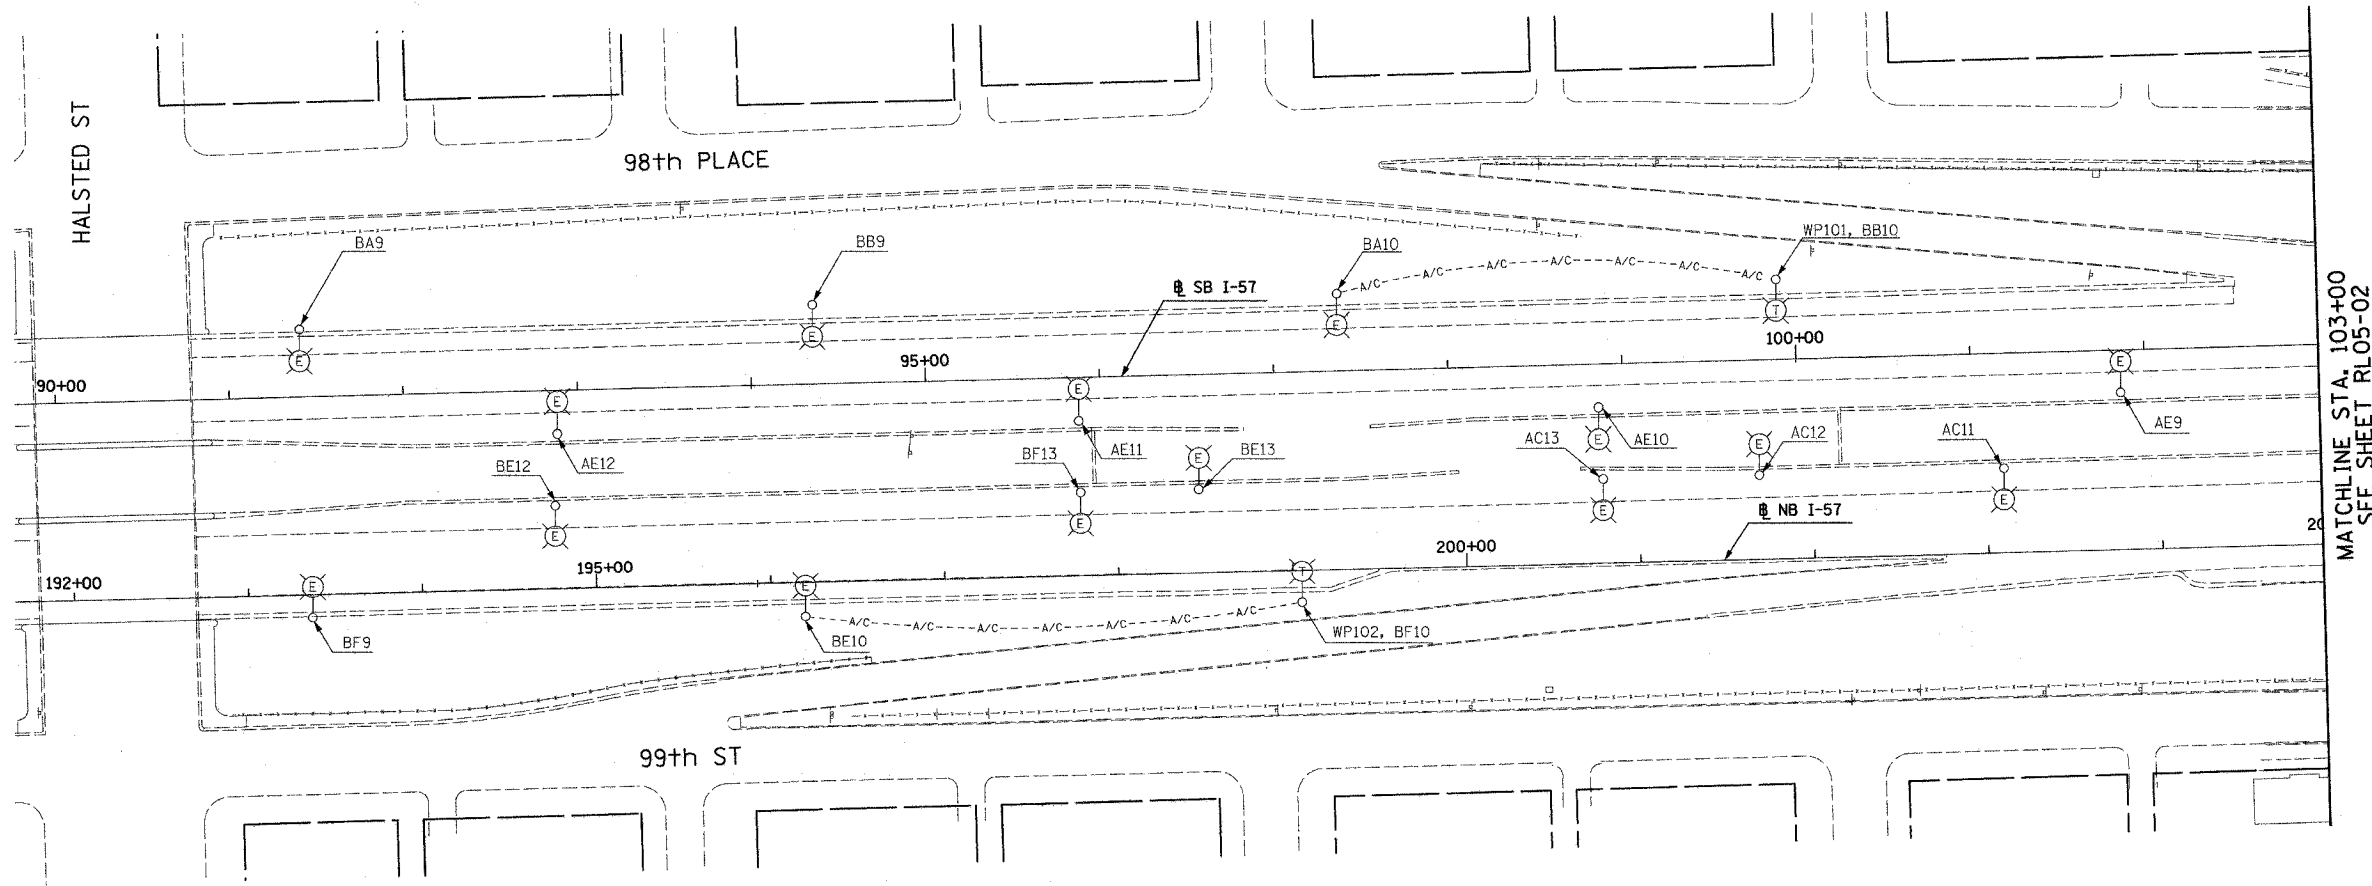

MATCHLINE STA. 103+00  
SEE SHEET RL05-02

NO ELECTRICAL WORK THIS SHEET  
FOR REFERENCE ONLY



RL05-01

REVISIONS	
NAME	DATE

ILLINOIS DEPARTMENT OF TRANSPORTATION  
F.A.I. 90/94 (DAN RYAN EXPRESSWAY)  
31st STREET TO I-57  
ROADWAY LIGHTING PLANS  
PROPOSED IMPROVEMENTS 2005  
SCALE: 1"=50'  
DATE: OCTOBER 29, 2004  
DRAWN BY: VRK  
CHECKED BY: TM

**SINGH** 300 W. ADAMS ST.  
CHICAGO, IL 60606  
SINGH & ASSOCIATES, INC. TEL: (312) 629-0240  
CONSULTING ENGINEERS FAX: (312) 629-9449

10/14/2004 9:41:23 AM