


F.A.I. RTE.	SECTION	COUNTY	TOTAL SHEETS	SHEET NO.
90/94	2003-0311	COOK	976	140
STA. 1334+00		TO STA. 1347+00		
FED. ROAD DIST. NO.		ILLINOIS FED. AID PROJECT		

 
62583

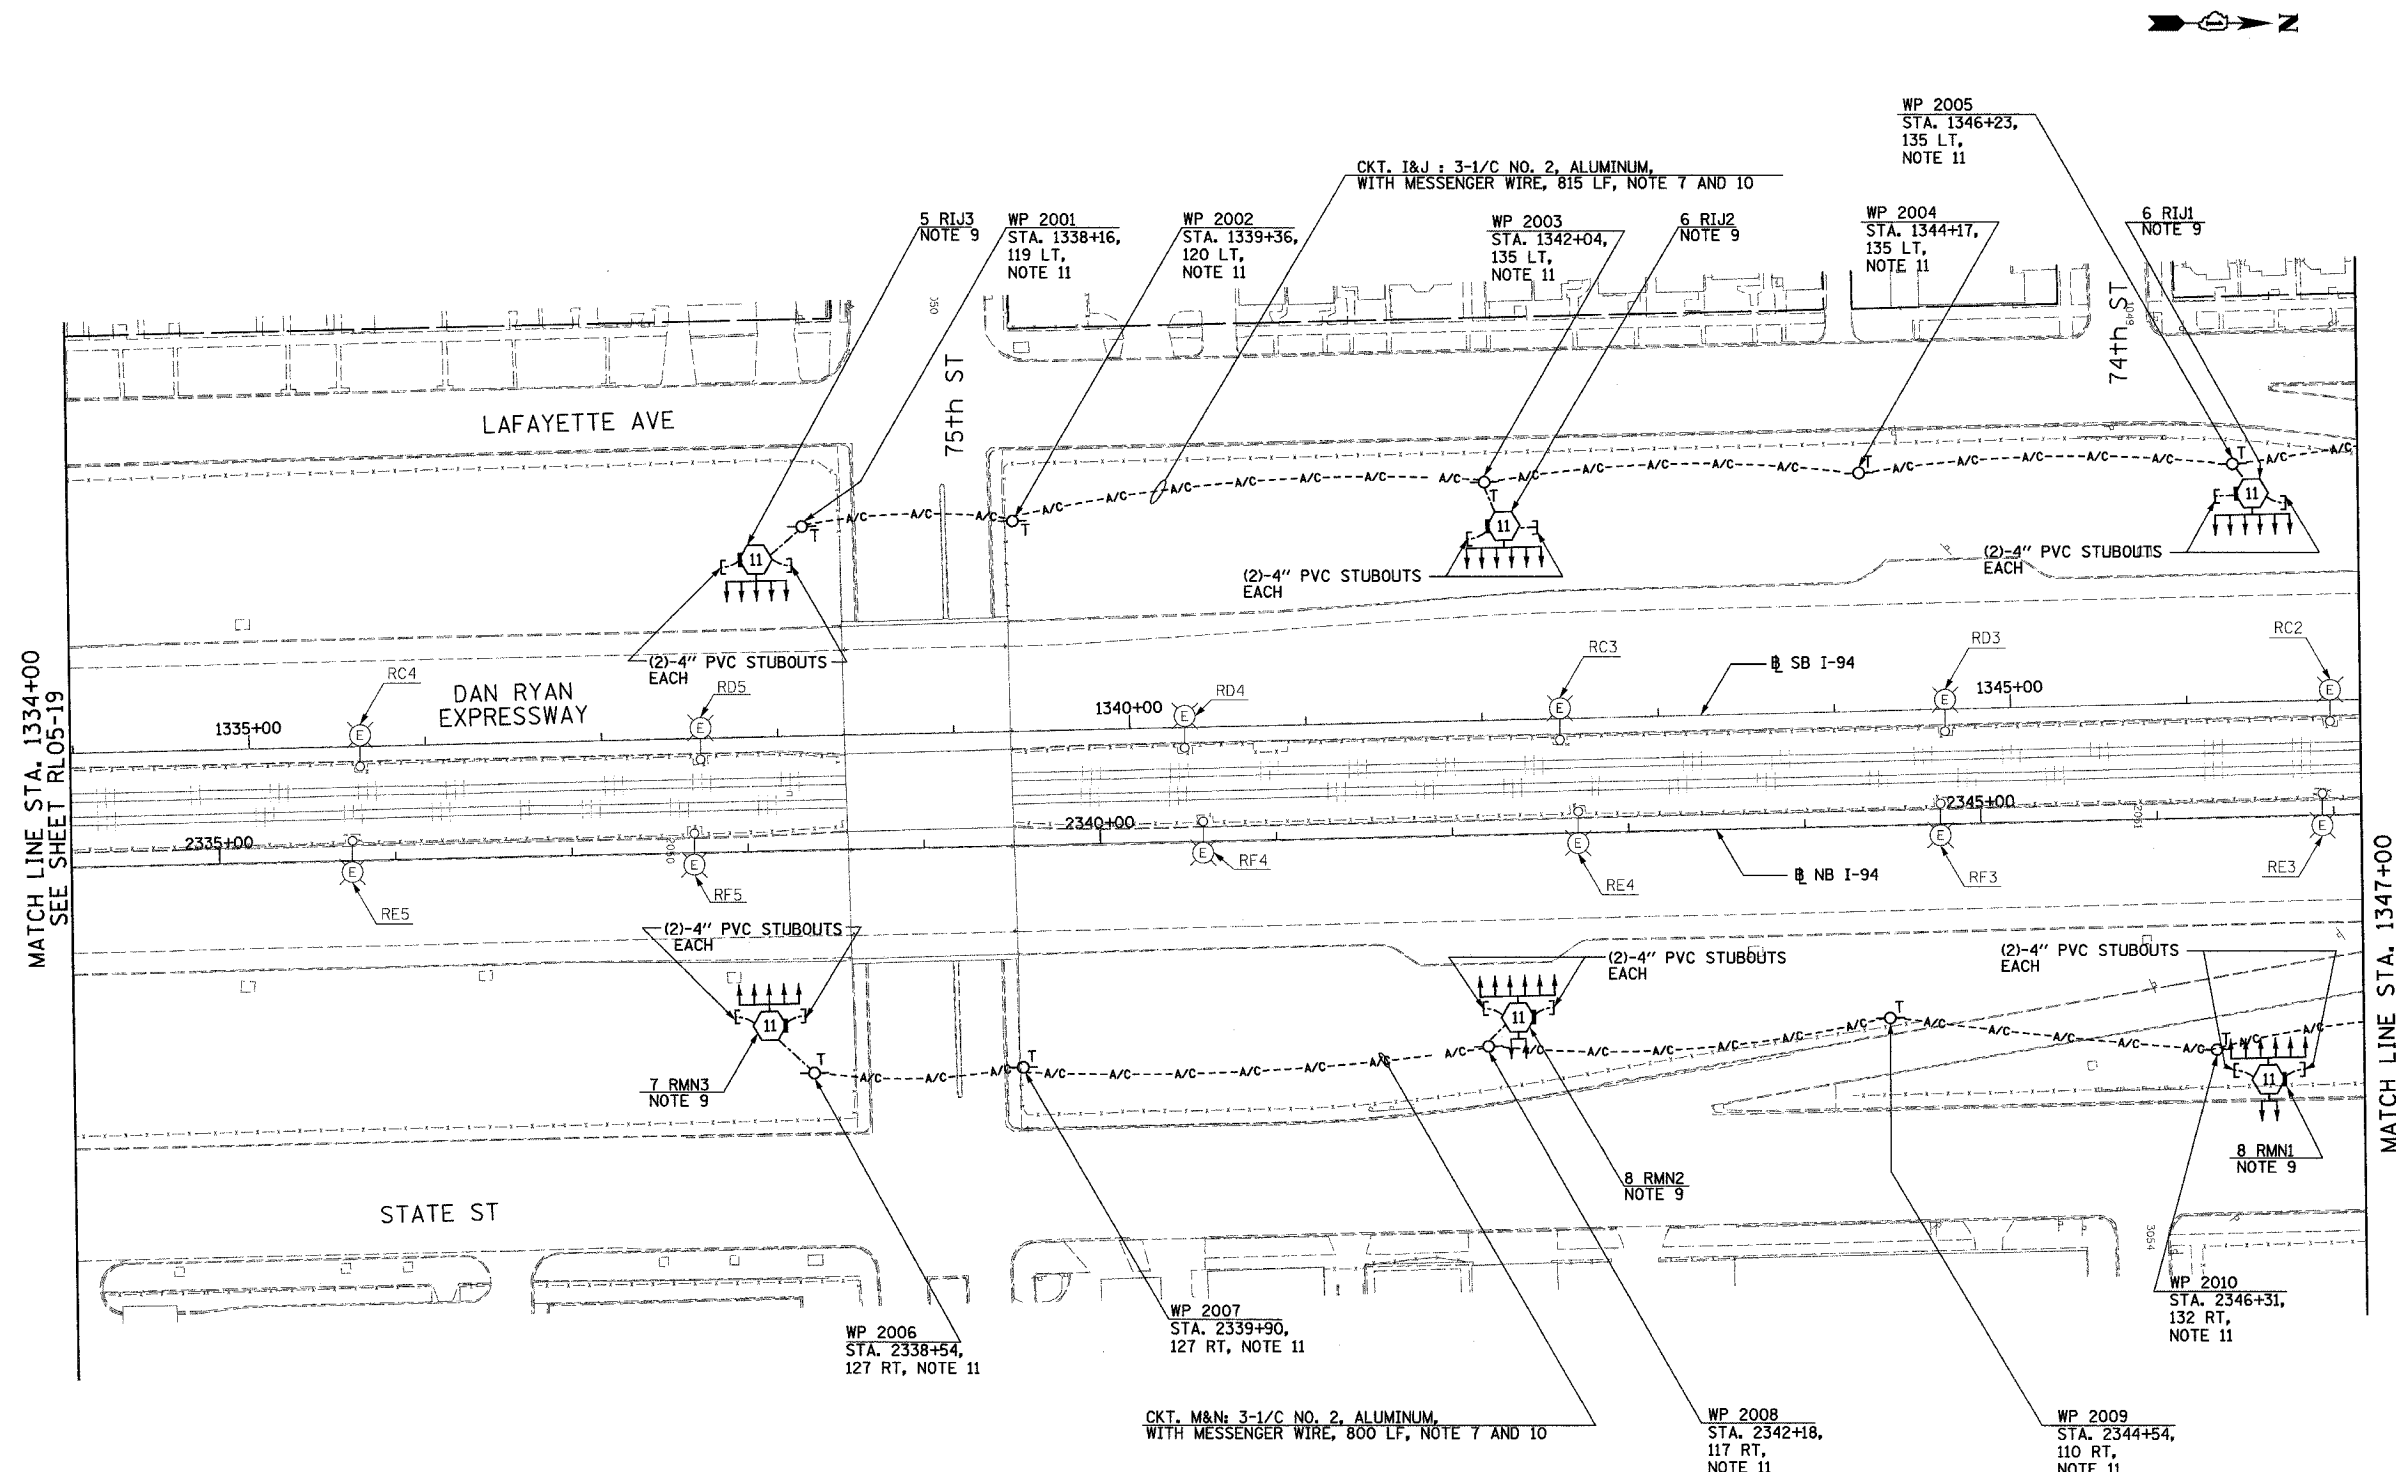

MATCH LINE STA. 1334+00  
SEE SHEET RL05-19

MATCH LINE STA. 1347+00  
SEE SHEET RL05-21

- NOTES:**
- SEE DRAWINGS ME-01 AND ME-02 FOR ELECTRICAL SYMBOLS AND ABBREVIATIONS.
  - UNLESS NOTED OTHERWISE, ALL ITEMS AND WORK SHOWN IN HEAVY LINE WEIGHT ON THIS DRAWING ARE PROPOSED NEW ITEMS OF WORK.
  - SEE SHEET ES-03 FOR HIGH MAST LIGHT TOWER SCHEDULE.
  - THE EXISTING ROADWAY LIGHTING SYSTEM SHALL REMAIN IN OPERATION UNTIL THE PROPOSED ROADWAY LIGHTING SYSTEM HAS BEEN INSTALLED, ENERGIZED, TESTED, AND ACCEPTED BY THE ENGINEER, UNLESS OTHERWISE DIRECTED BY THE ENGINEER.
  - FOUNDATION SHALL BE PROVIDED UNDER CONTRACT 62694 AND 62695. CONTRACTOR TO COORDINATE WITH THESE CONTRACTS FOR INSTALLATION OF LIGHT POLE AND LUMINAIRE.
  - PROPOSED RAMP LIGHTING TO BE INSTALLED AND ENERGIZED PRIOR TO OPENING OF RAMP. COORDINATE WITH CIVIL CONTRACTS 62694 AND 62695 AND AS DIRECTED BY THE ENGINEER.
  - REFER TO SHEET ME-16 FOR TEMPORARY AERIAL CABLE CONNECTION.
  - UNIT DUCT SHALL BE PULLED THROUGH EXISTING UNDERGROUND DUCT BANKS PROVIDED UNDER SEPARATE CONTRACTS. UNIT DUCT SHALL BE INSTALLED BETWEEN HIGH MAST LIGHT TOWER IN CONTINUOUS LENGTHS WITHOUT SPLICES.
  - REFER TO SHEET ME-25 FOR TEMPORARY AERIAL CABLE CONNECTION TO HIGH MAST LIGHT TOWER.
  - AERIAL CABLE AND TEMPORARY WOOD POLES SHALL BE REMOVED AFTER HIGH MAST LIGHT TOWERS ARE PERMANENTLY WIRED AND ACCEPTED BY THE ENGINEER.
  - TEMPORARY WOOD POLES SHALL BE INSERTED IN GROUND TO ACCOMMODATE PROPOSED GRADING.



RL05-20

REVISIONS	
NAME	DATE

ILLINOIS DEPARTMENT OF TRANSPORTATION  
 F.A.I. 90/94 (DAN RYAN EXPRESSWAY)  
 31st STREET TO I-57  
 ROADWAY LIGHTING PLANS  
 PROPOSED IMPROVEMENTS 2005

SCALE: 1"=50'  
 DATE: OCTOBER 29, 2004

DRAWN BY: VRK  
 CHECKED BY: TM

**SINGH** 300 W. ADAMS ST.  
 CHICAGO, IL 60606  
 SINGH & ASSOCIATES, INC. TEL: (312) 629-0240  
 CONSULTING ENGINEERS FAX: (312) 629-8449

11/22/2004 3:56:25 PM