


F.A.I. RTE.	SECTION	COUNTY	TOTAL SHEETS	SHEET NO.
94/90	2003-0311	COOK	976	156
STA. 1584+00	TO STA. 1596+00			
FED. ROAD DIST. NO.	ILLINOIS	FED. AID PROJECT		

62583



**NOTE:**

- SEE DRAWINGS ME-01 AND ME-02 FOR ELECTRICAL SYMBOLS AND ABBREVIATIONS.

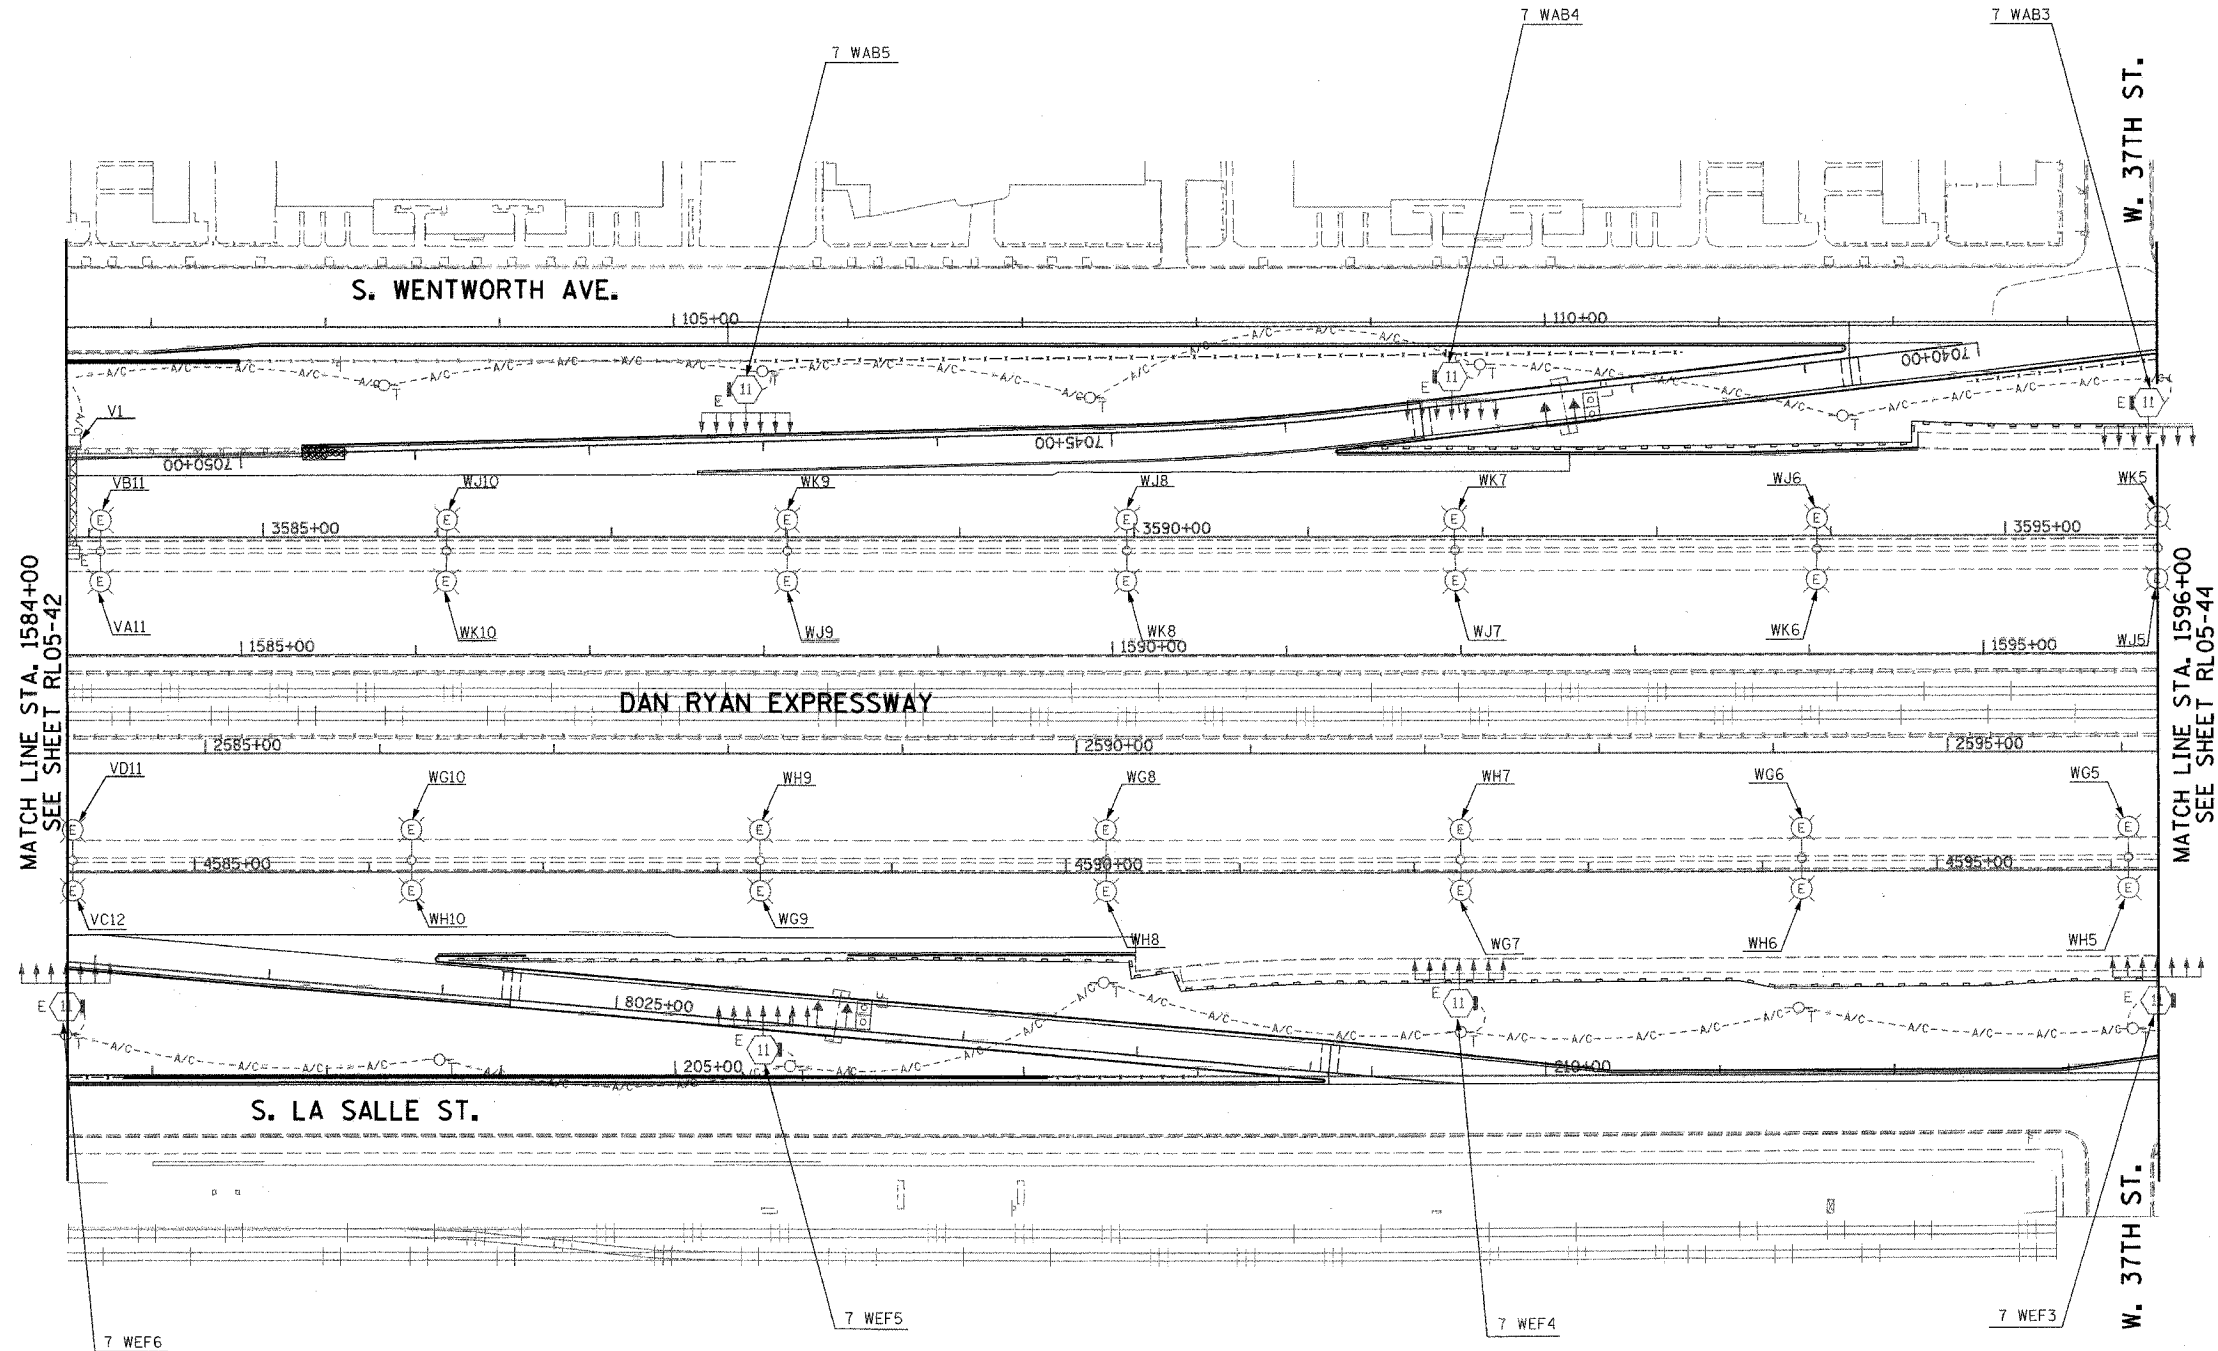


MATCH LINE STA. 1584+00  
SEE SHEET RL05-42

MATCH LINE STA. 1596+00  
SEE SHEET RL05-44

RL05-43

 **K&E** KAM ENGINEERING, INC.  
CONSULTING ENGINEERS  
707A Davis Road, Suite 205  
Elgin, Illinois 60123-1369



REVISIONS	
NAME	DATE

ILLINOIS DEPARTMENT OF TRANSPORTATION  
F.A.I. 94/90 (DAN RYAN EXPRESSWAY)  
31st STREET TO I-57

**ROADWAY LIGHTING PLANS  
PROPOSED IMPROVEMENTS 2005**

SCALE: 1"=50'  
DATE: OCTOBER 29, 2004

DRAWN BY: BL  
CHECKED BY: SM

D:\projects\2004\10\29\RL05-43.dwg 10/29/04 10:55:31 AM