


F.A.I. RTE.	SECTION	COUNTY	TOTAL SHEETS	SHEET NO.
94/90	2003-0311	COOK	976	157
STA. 1596+00		TO STA. 1608+00		
FED. ROAD DIST. NO.		ILLINOIS FED. AID PROJECT		
62583				



**NOTE:**  
 1. SEE DRAWINGS ME-01 AND ME-02 FOR ELECTRICAL SYMBOLS AND ABBREVIATIONS.

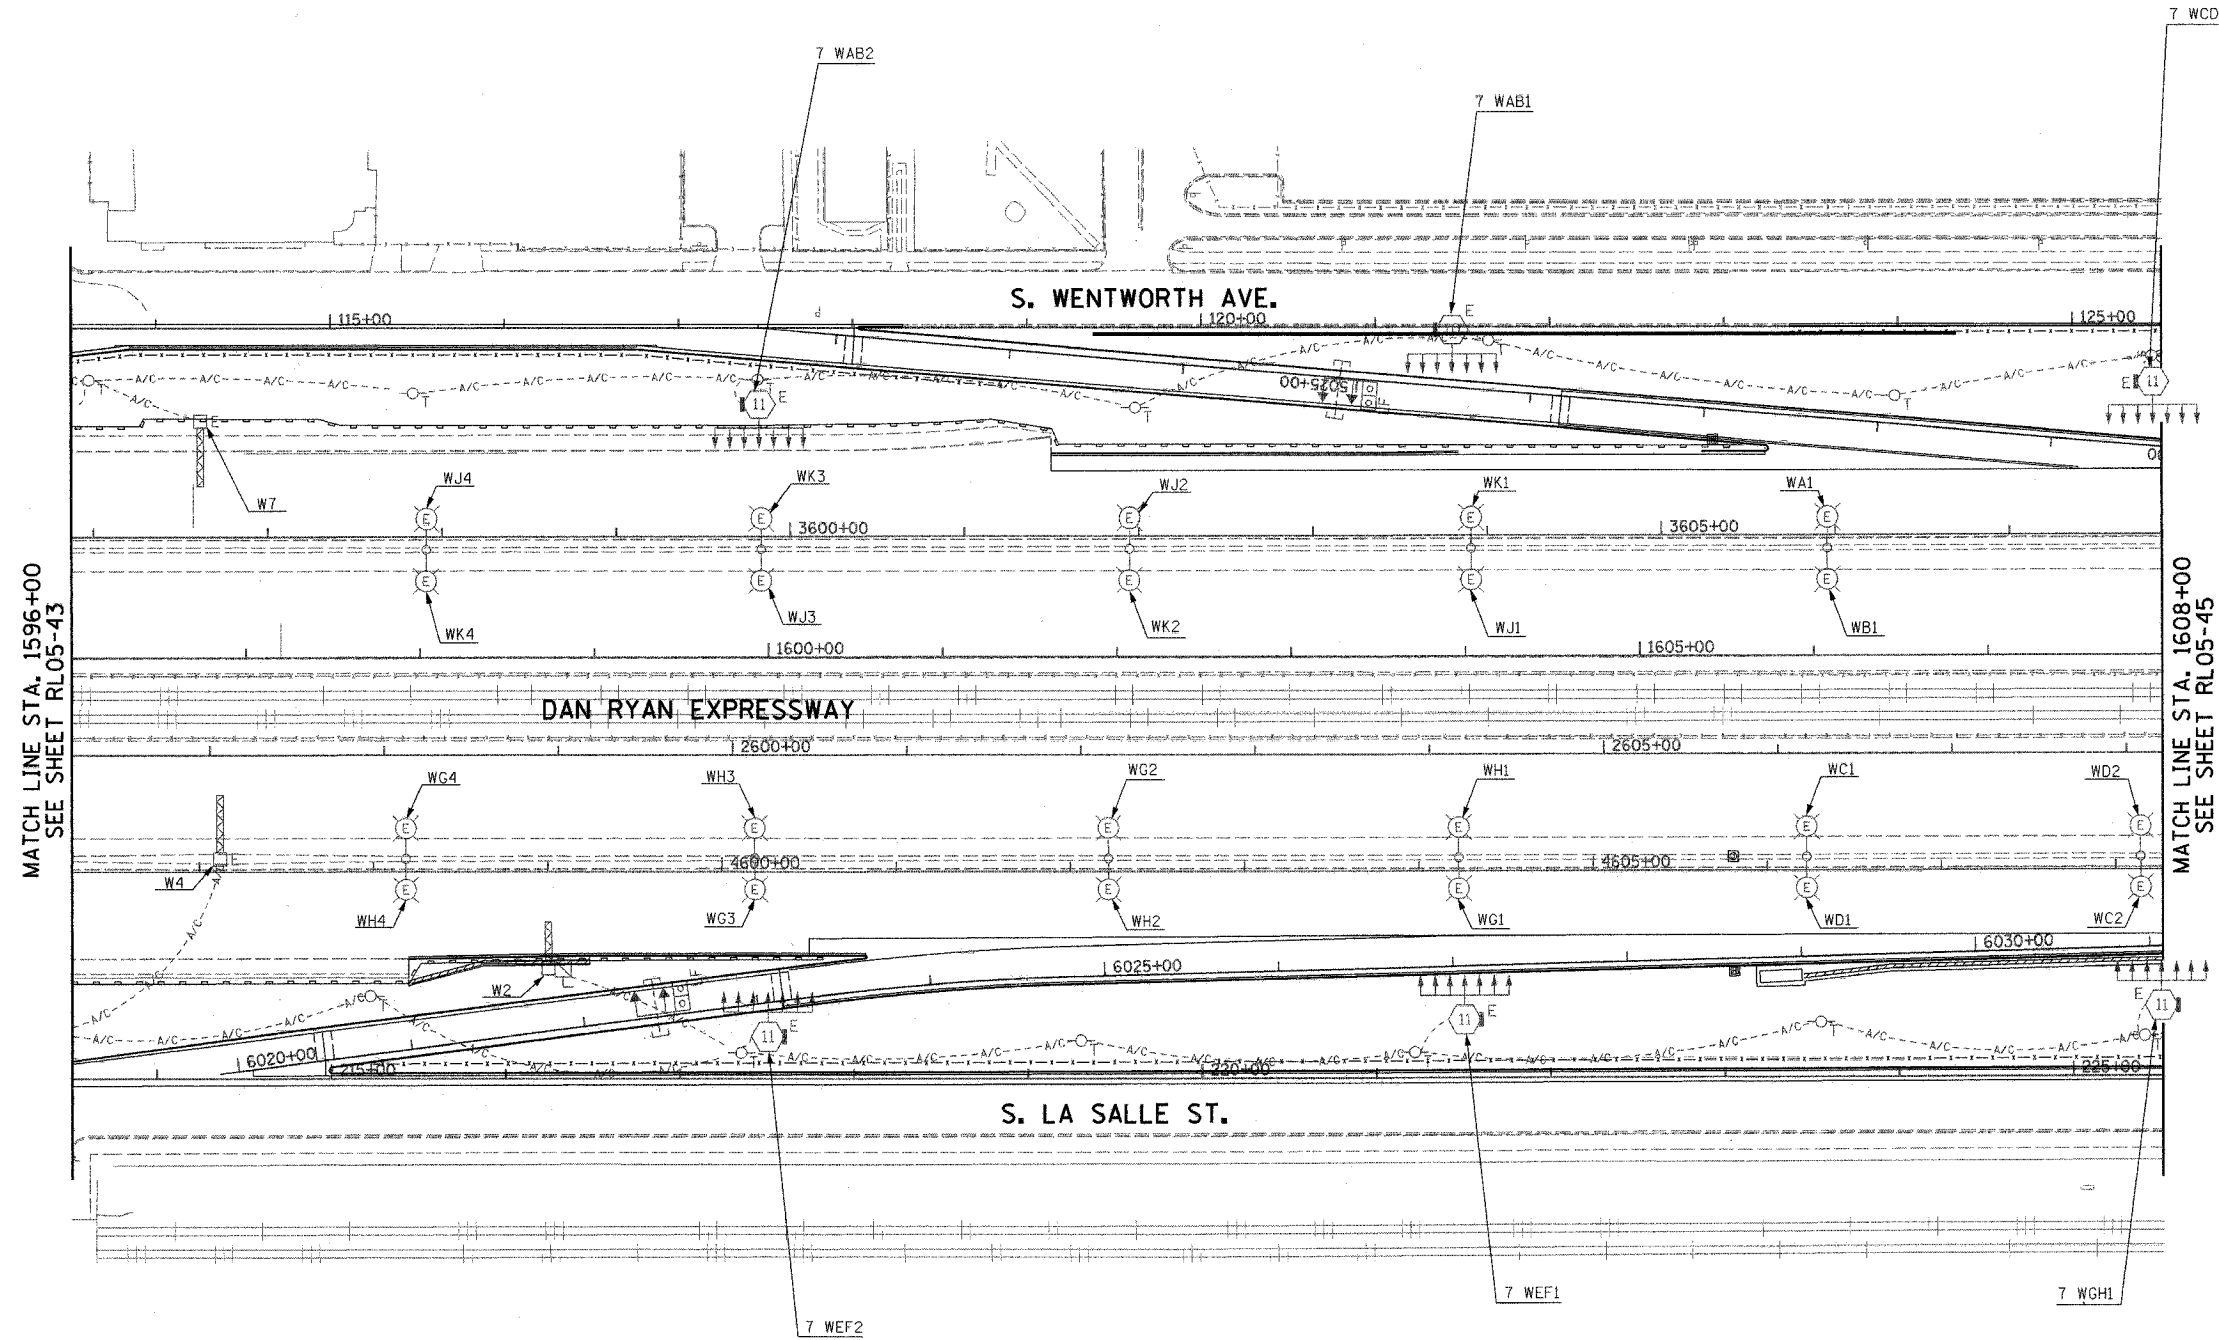

MATCH LINE STA. 1596+00  
SEE SHEET RL05-43

MATCH LINE STA. 1608+00  
SEE SHEET RL05-45

RL05-44

**K&E** KAM ENGINEERING, INC.  
 CONSULTING ENGINEERS  
 707A Davis Road, Suite 205  
 Elgin, Illinois 60123-1369



REVISIONS	
NAME	DATE

ILLINOIS DEPARTMENT OF TRANSPORTATION  
 F.A.I. 94/90 (DAN RYAN EXPRESSWAY)  
 31st STREET TO I-57

**ROADWAY LIGHTING PLANS  
 PROPOSED IMPROVEMENTS 2005**

SCALE: 1"=50'      DRAWN BY: BL  
 DATE: OCTOBER 29, 2004      CHECKED BY: SM

10/15/2004 11:08:13 AM G:\projects\Job 329\Sheet\Lighting\RL05-44.DWG