


F.A.I. RTE.	SECTION	COUNTY	TOTAL SHEETS	SHEET NO.
94/90	2003-0311	COOK	976	159
STA. 1620+00		TO STA. 1632+00		
FED. ROAD DIST. NO.		ILLINOIS	FED. AID PROJECT	

62583



NOTE:

- SEE DRAWINGS ME-01 AND ME-02 FOR ELECTRICAL SYMBOLS AND ABBREVIATIONS.

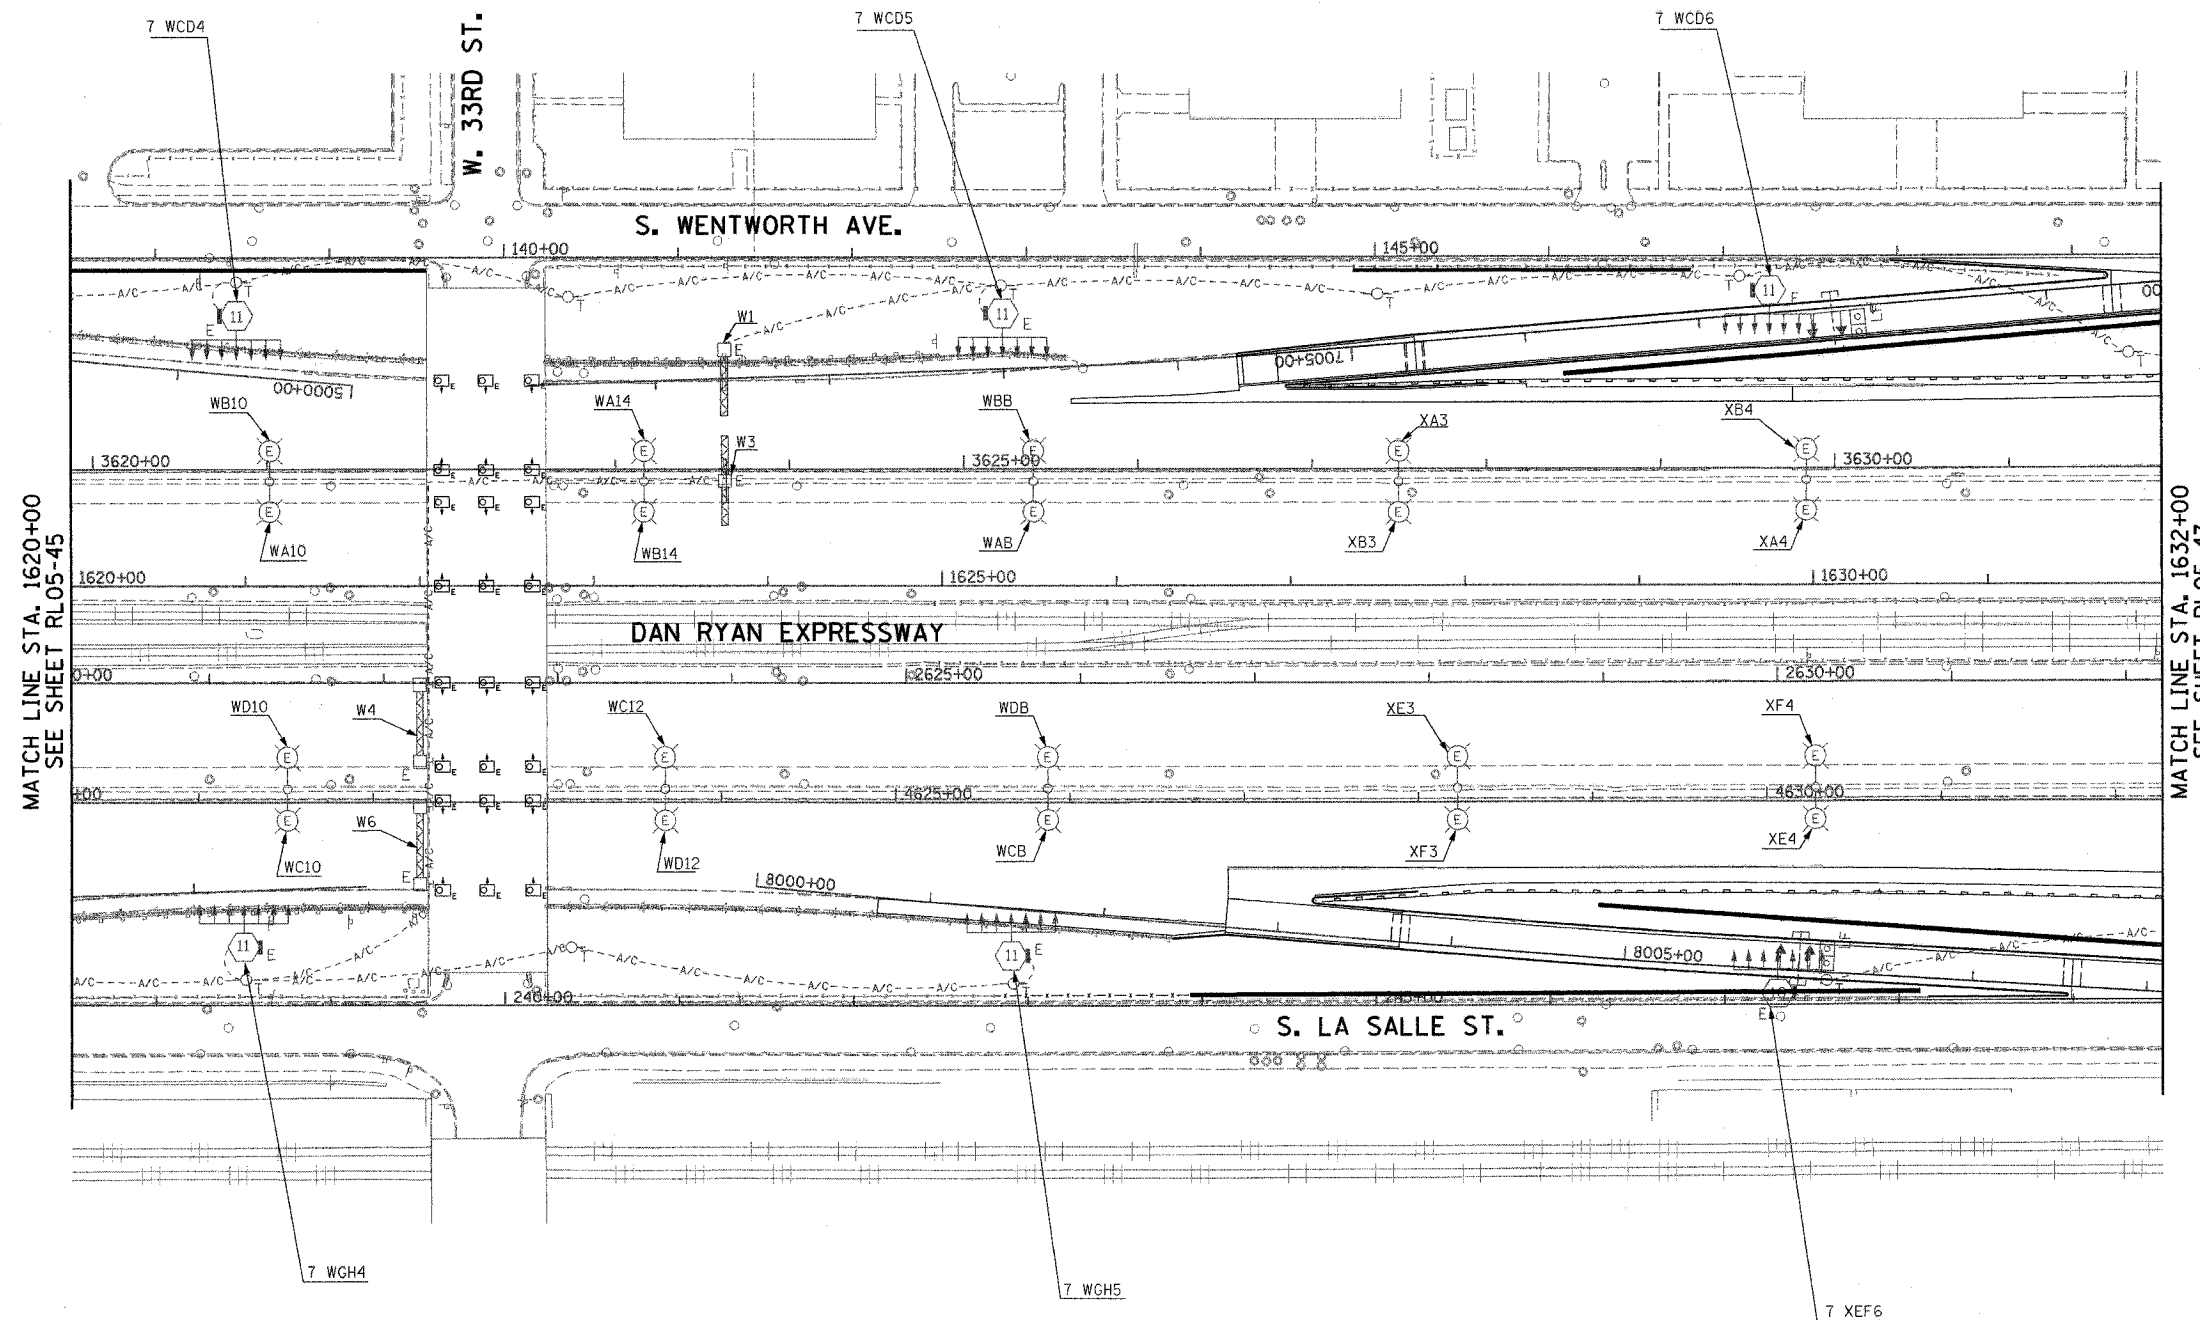


MATCH LINE STA. 1620+00
SEE SHEET RL05-45

MATCH LINE STA. 1632+00
SEE SHEET RL05-47

RL05-46

 K&E KAM ENGINEERING, INC.
CONSULTING ENGINEERS
707A Davis Road, Suite 205
Elgin, Illinois 60123-1369



REVISIONS	
NAME	DATE

ILLINOIS DEPARTMENT OF TRANSPORTATION
F.A.I. 94/90 (DAN RYAN EXPRESSWAY)
31st STREET TO I-57

ROADWAY LIGHTING PLANS
PROPOSED IMPROVEMENTS 2005

SCALE: 1"=50'

DATE: OCTOBER 29, 2004

DRAWN BY: BL

CHECKED BY: SM

11/09/04 10:15:2004