


F.A.I. RTE.	SECTION	COUNTY	TOTAL SHEETS	SHEET NO.
94/90	2003-0311	COOK	976	160
STA. 1632+00	TO STA. 1644+00			
FED. ROAD DIST. NO.	ILLINOIS	FED. AID PROJECT		

62583

 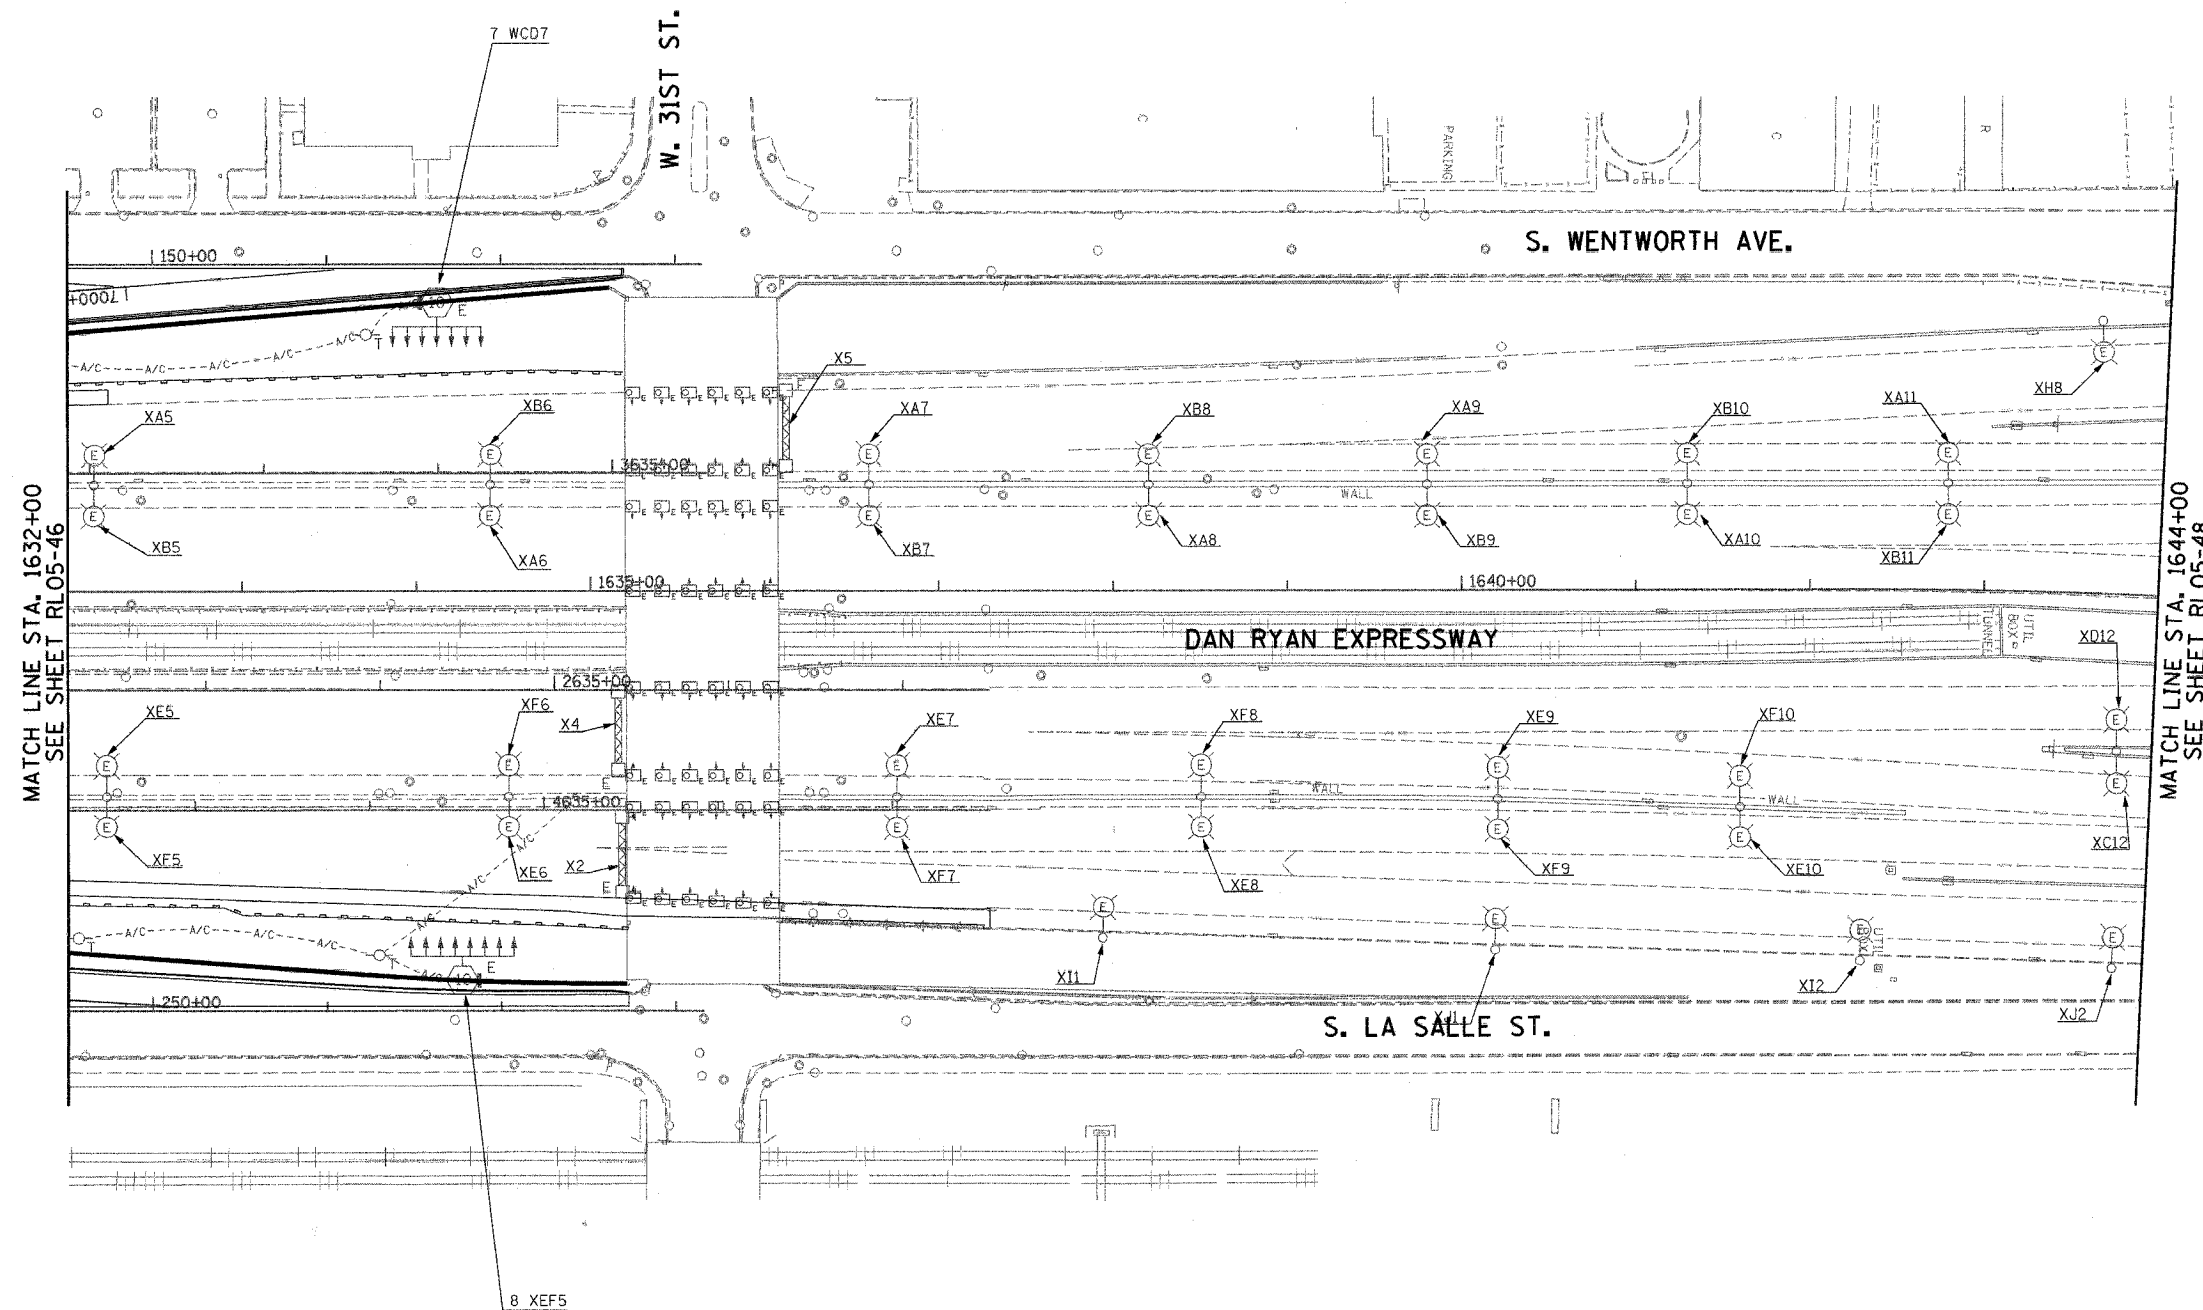


NOTE:
 1. SEE DRAWINGS ME-01 AND ME-02 FOR ELECTRICAL SYMBOLS AND ABBREVIATIONS.

MATCH LINE STA. 1632+00
SEE SHEET RL05-46

MATCH LINE STA. 1644+00
SEE SHEET RL05-48

KAM ENGINEERING, INC.
 CONSULTING ENGINEERS
 707A Davis Road, Suite 205
 Elgin, Illinois 60123-1369



REVISIONS	
NAME	DATE

ILLINOIS DEPARTMENT OF TRANSPORTATION
 F.A.I. 94/90 (DAN RYAN EXPRESSWAY)
 31st STREET TO I-57

**ROADWAY LIGHTING PLANS
 PROPOSED IMPROVEMENTS 2005**

SCALE: 1"=50' DRAWN BY: BL
 DATE: OCTOBER 29, 2004 CHECKED BY: SM

RL05-47

G:\projects\sub_325\SHR Lighting\RL05-47\RL05-47.dwg 11/23/04 AM 10:05:2004