
 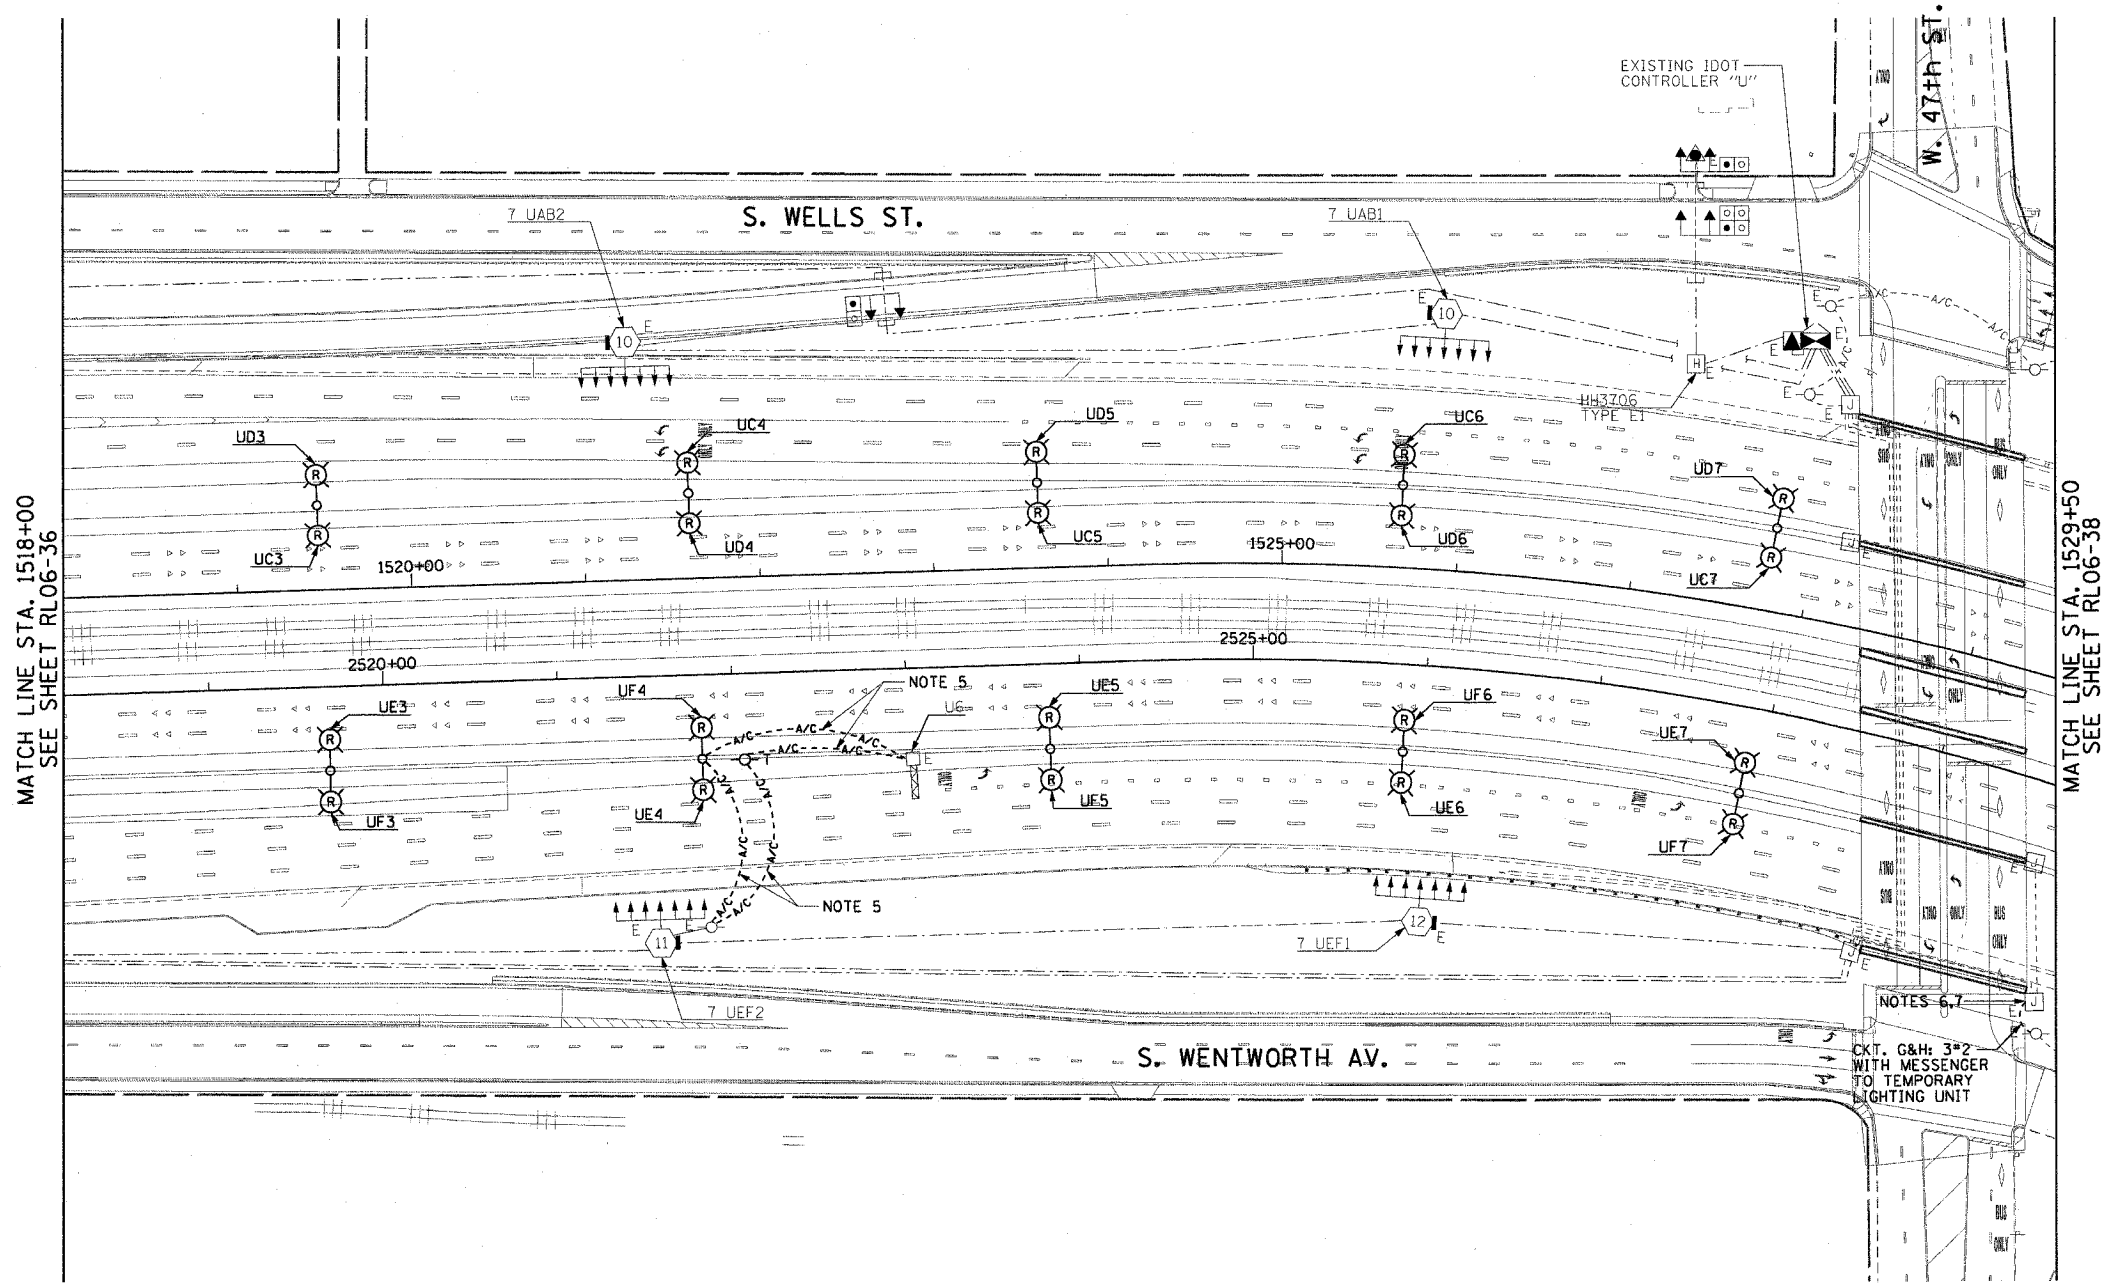


F.A.I. 90/94	SECTION 2003-0311	COUNTY COOK	TOTAL SHEETS 976	SHEET NO. 148
STA. 1518+00.00		TO STA. 1529+50.00		
FED. ROAD DIST. NO. 1 ILLINOIS FED. AID PROJECT				

62583

 
NOTES:

- SEE DRAWINGS ME-01 AND ME-02 FOR ELECTRICAL SYMBOLS AND ABBREVIATIONS.
- COORDINATE ALL WORK WITH IDOT CONTRACT NOS. 62300 AND 62302.
- UNLESS NOTED OTHERWISE, ALL ITEMS AND WORK SHOWN IN HEAVY LINE WEIGHT ON THIS DRAWING ARE PROPOSED ITEMS AND WORK.
- SEE DRAWING UL-32 FOR 47th STREET UNDERPASS LIGHTING PLANS.
- DETACH THE EXISTING TEMPORARY AERIAL CABLES FROM THE EXISTING LIGHTING UNIT TO BE REMOVED AND REATTACH TO THE NEW TEMPORARY WOOD POLE AS SHOWN. THIS WILL BE INCLUDED FOR PAYMENT WITH THE "REMOVAL OF EXISTING LIGHTING UNIT, SALVAGE" PAY ITEM.
- SPLICE NEW LIGHTING CIRCUIT CABLES TO THE CORRESPONDING EXISTING LIGHTING CIRCUITS LOCATED WITHIN THE EXISTING JUNCTION BOX.
- CONTRACTOR MUST DRILL AN ACCESS HOLE ON THE BOTTOM OF THE EXISTING JUNCTION BOX FOR THE TEMPORARY AERIAL CABLES. PROVIDE A WEATHERTIGHT SEAL WHERE THE AERIAL CABLES ENTER THE JUNCTION BOX.



MATCH LINE STA. 1518+00
SEE SHEET RL06-36

MATCH LINE STA. 1529+50
SEE SHEET RL06-38



RL06-37

REVISIONS	
NAME	DATE

ILLINOIS DEPARTMENT OF TRANSPORTATION
F.A.I. 90/94 (DAN RYAN EXPRESSWAY)
31st STREET TO I-57
**ROADWAY LIGHTING PLANS
PROPOSED IMPROVEMENTS 2006**

SCALE: 1"=50' DRAWN BY: CJM
DATE: October 29, 2004 CHECKED BY: WDS

CTE ENGINEERS
CONSOER TOWNSEND ENVIRODYNE ENGINEERS, INC.
303 EAST WACKER DRIVE, SUITE 600
CHICAGO ILLINOIS 60601-5212, PHONE: (312) 938-0300

10/15/2004 04:17:44 PM