


F.A.I. RTE.	SECTION	COUNTY	TOTAL SHEETS	SHEET NO.
90/94	2003-0311	COOK	976	276
STA. 1334+00		TO STA. 1347+00		
FED. ROAD DIST. NO.		ILLINOIS FED. AID PROJECT		

62583

- NOTES:
- SEE DRAWINGS ME-01 AND ME-02 FOR ELECTRICAL SYMBOLS AND ABBREVIATIONS.
  - SEE DRAWING UL-19 FOR 75th STREET UNDERPASS LIGHTING PLANS.

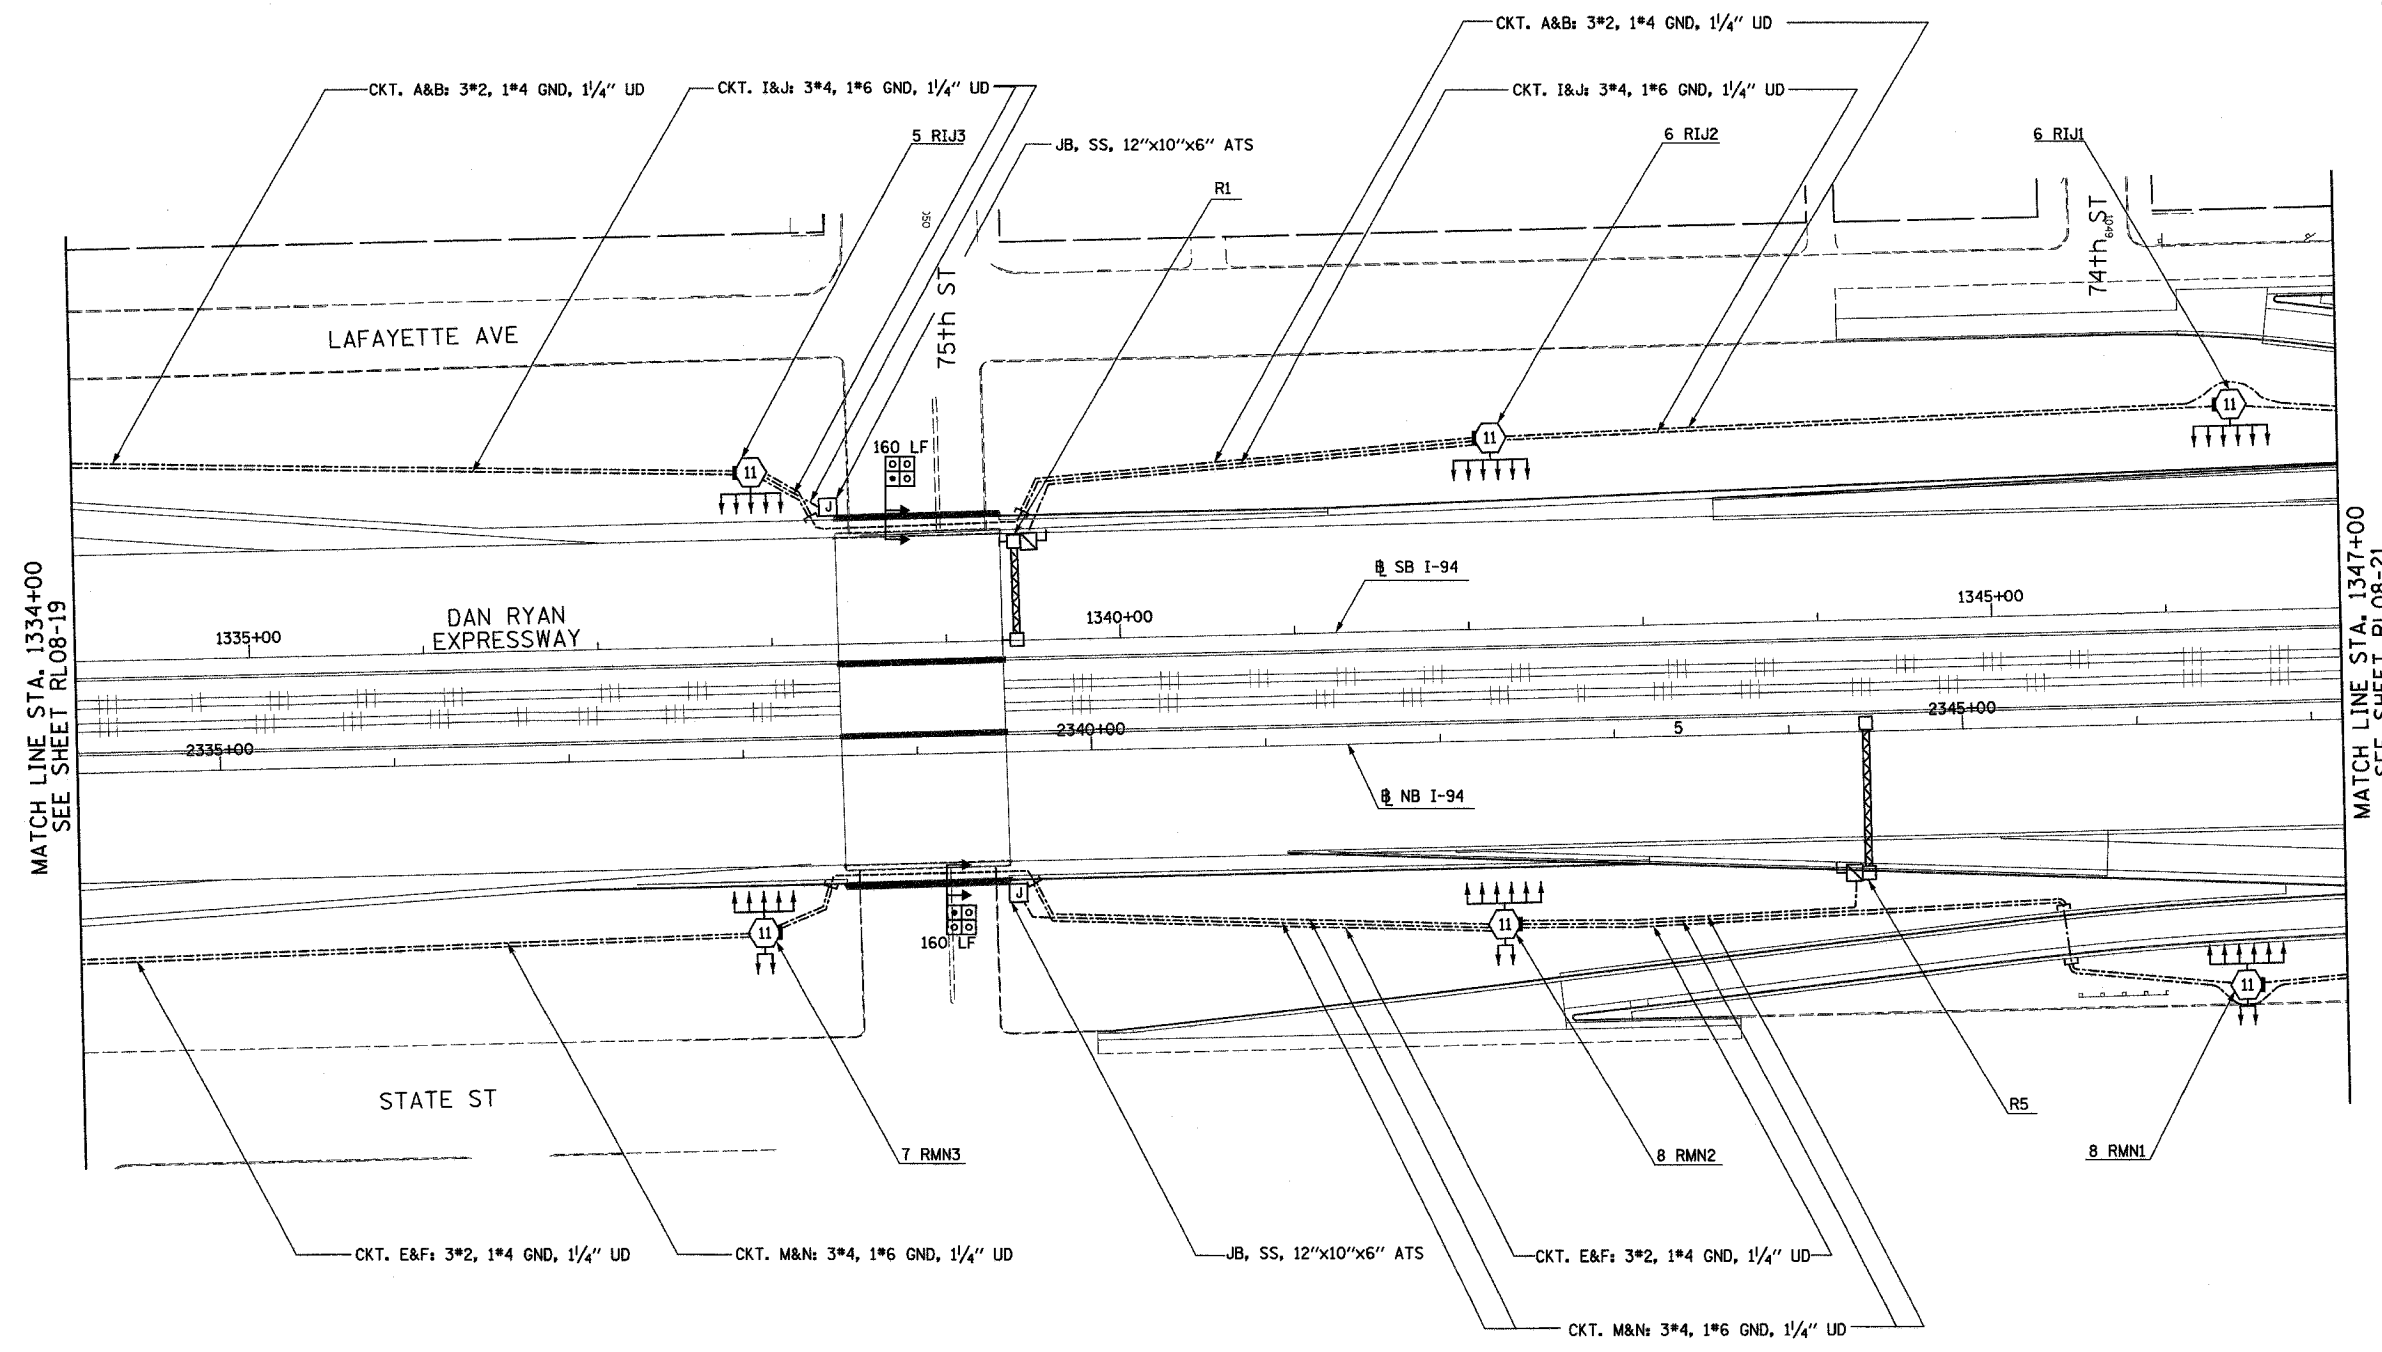

MATCH LINE STA. 1334+00  
SEE SHEET RL08-19

MATCH LINE STA. 1347+00  
SEE SHEET RL08-21



RL08-20

**SINGH** 300 W. ADAMS ST.  
CHICAGO, IL 60606  
SINGH & ASSOCIATES, INC. TEL: (312) 629-0240  
CONSULTING ENGINEERS FAX: (312) 629-8445

REVISIONS	
NAME	DATE

ILLINOIS DEPARTMENT OF TRANSPORTATION  
F.A.I. 90/94 (DAN RYAN EXPRESSWAY)  
31st STREET TO I-57  
ROADWAY LIGHTING PLANS  
PROPOSED IMPROVEMENTS 2008  
SCALE: 1"=50' DRAWN BY: VG  
DATE: OCTOBER 29, 2004 CHECKED BY: TM

10/21/2004 12:35:08 PM