


F.A.I. RTE.	SECTION	COUNTY	TOTAL SHEETS	SHEET NO.
90/94	2003-0311	COOK	976	278
STA. 1360+00		TO STA. 1366+00		
FED. ROAD DIST. NO.	ILLINOIS	FED. AID PROJECT		

62583




NOTES:

- SEE DRAWINGS ME-01 AND ME-02 FOR ELECTRICAL SYMBOLS AND ABBREVIATIONS.
- SEE DRAWING UL-19A FOR 71st STREET UNDERPASS LIGHTING PLANS.

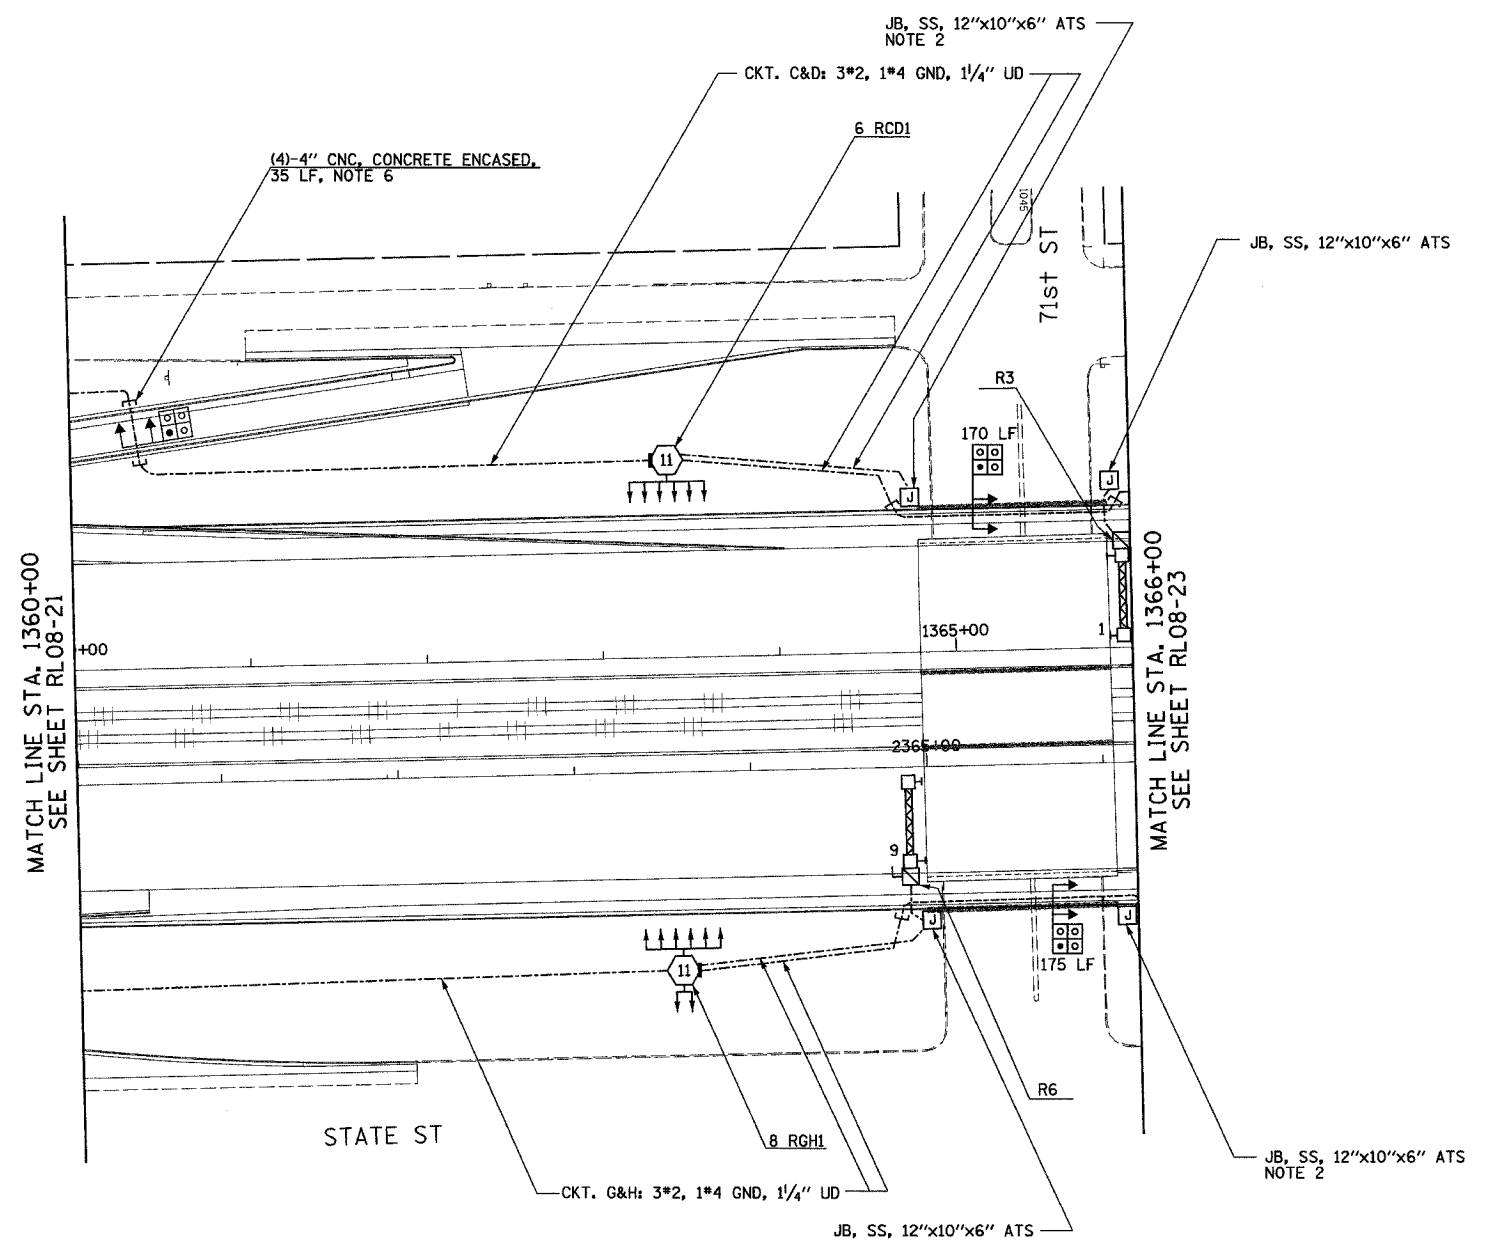

MATCH LINE STA. 1360+00
SEE SHEET RL08-21

 MATCH LINE STA. 1366+00
SEE SHEET RL08-23



RL08-22

REVISIONS	
NAME	DATE

ILLINOIS DEPARTMENT OF TRANSPORTATION
F.A.I. 90/94 (DAN RYAN EXPRESSWAY)
31st STREET TO I-57

ROADWAY LIGHTING PLANS
PROPOSED IMPROVEMENTS 2008

SCALE: 1"=50'

DRAWN BY: VG

DATE: OCTOBER 29, 2004

CHECKED BY: TM

SINGH 300 W. ADAMS ST.
CHICAGO, IL 60606
SINGH & ASSOCIATES, INC. TEL: (312) 629-0240
CONSULTING ENGINEERS FAX: (312) 629-8449

11/22/2004 5:38:35 PM