



F.A.I. RTE.	SECTION	COUNTY	TOTAL SHEETS	SHEET NO.
94/90	2003-0311	COOK	976	215
STA. 1536+00	TO STA. 1548+00			
FED. ROAD DIST. NO.	ILLINOIS	FED. AID PROJECT		
62583				

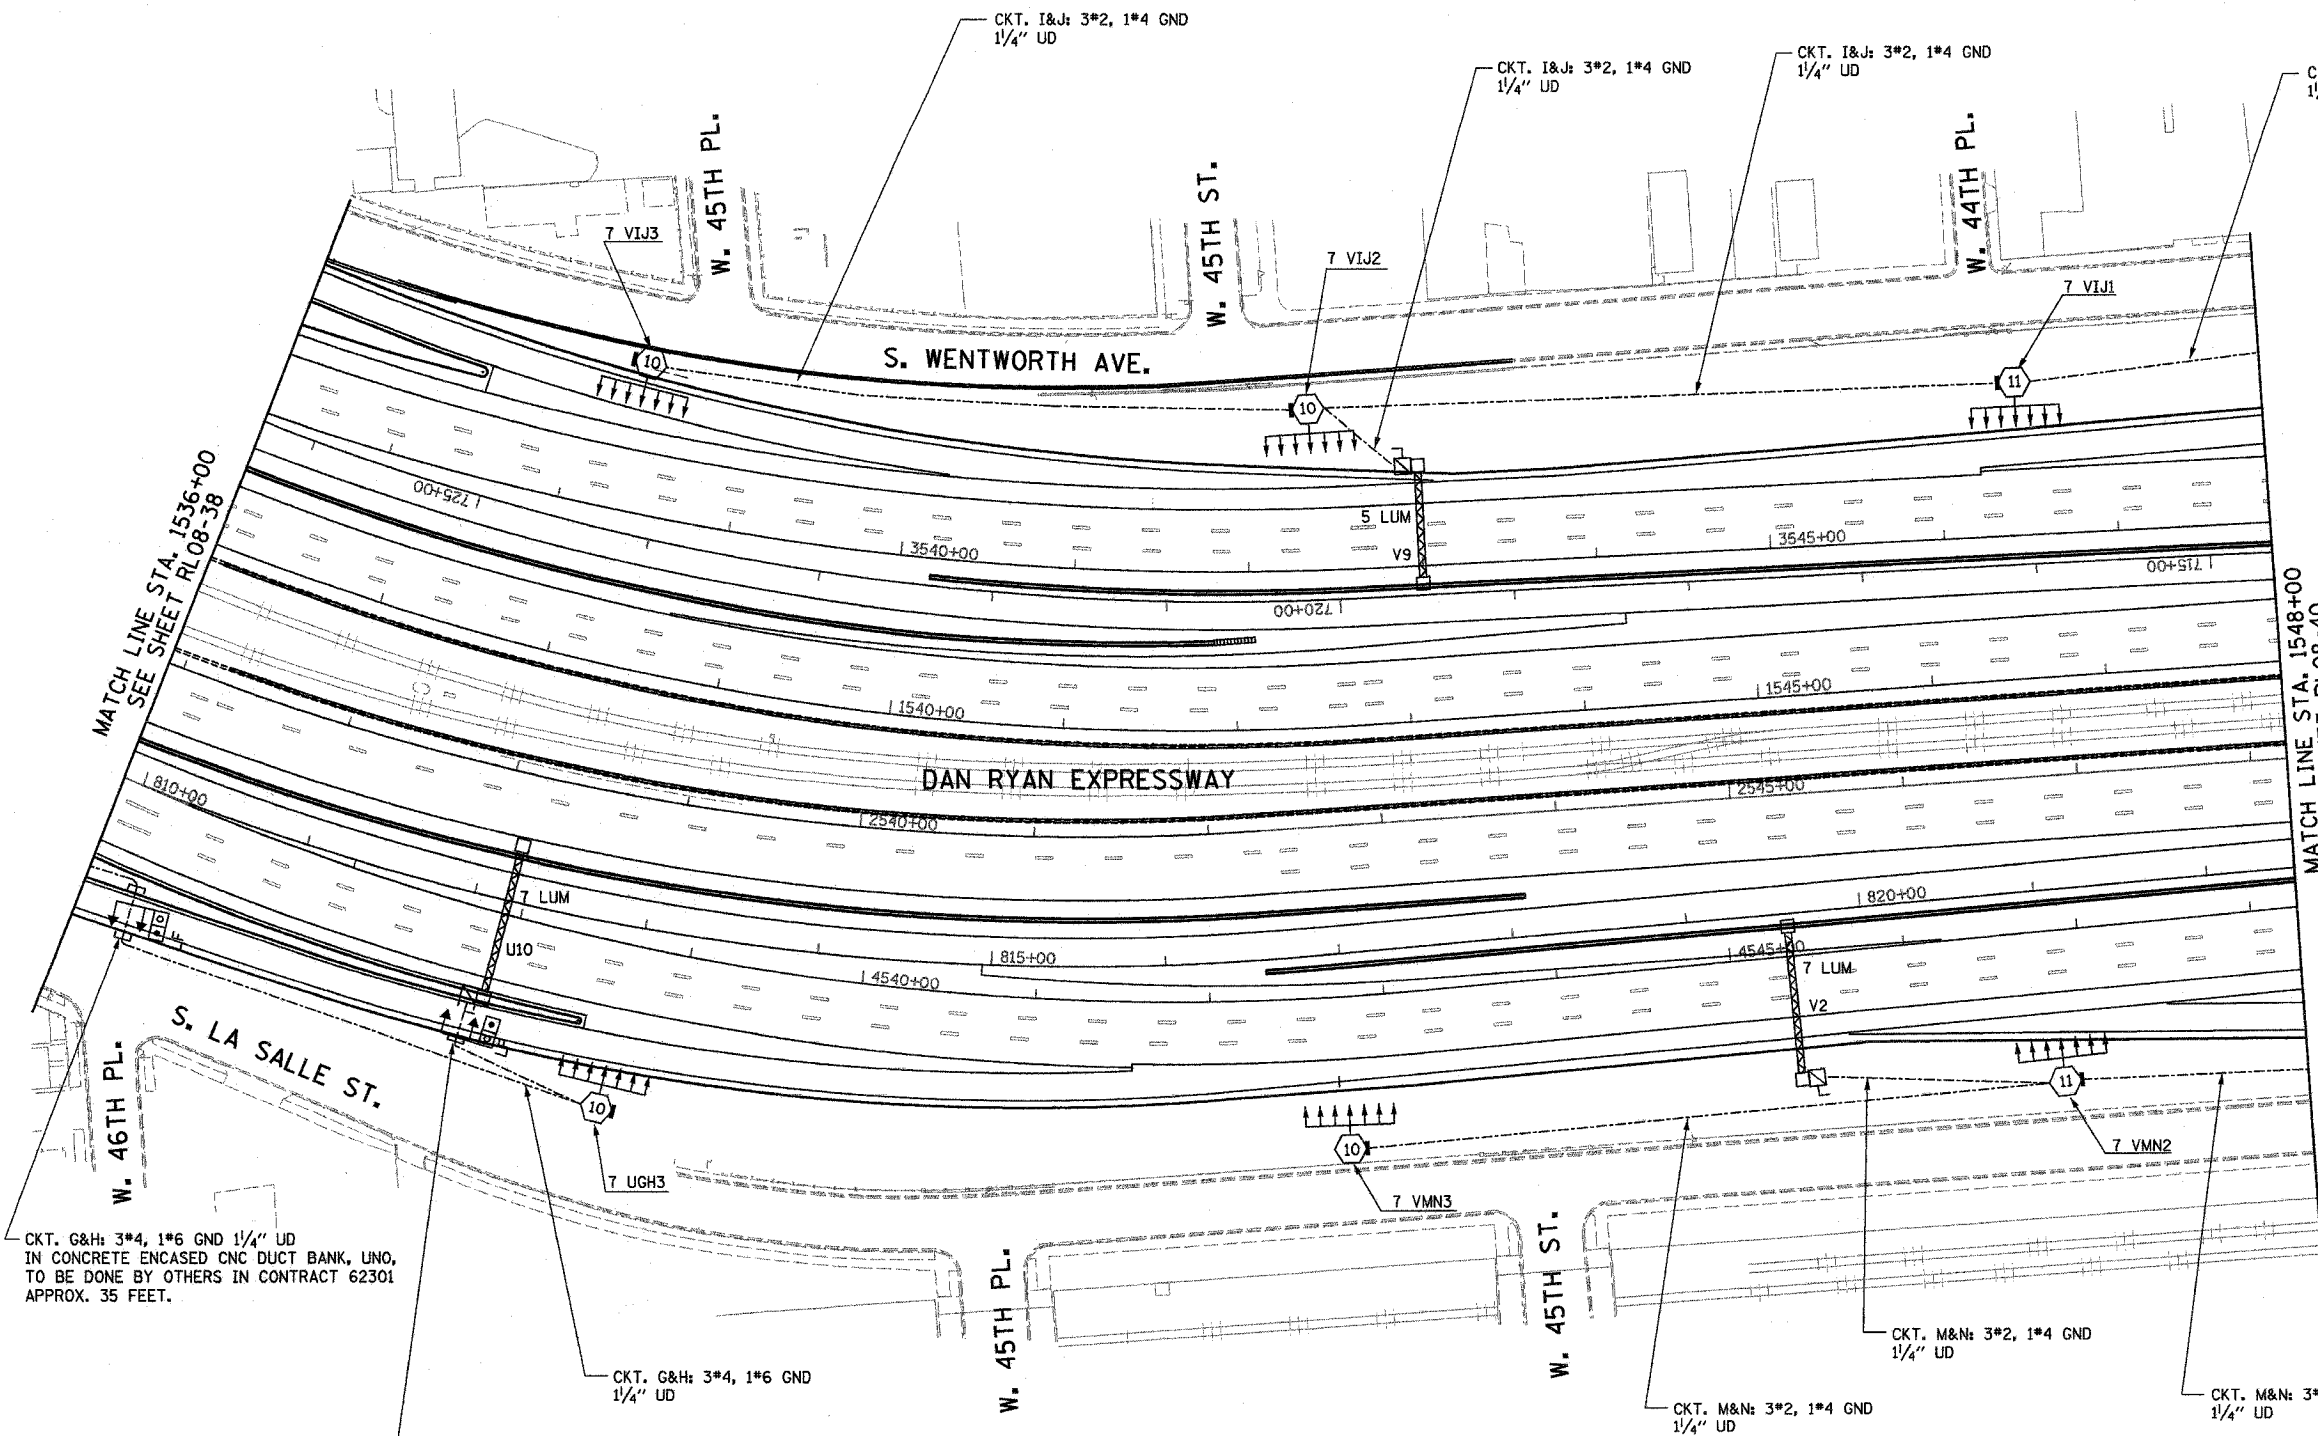

**NOTES:**  
 1. SEE SHEET ME-01 FOR ELECTRICAL SYMBOLS, ABBREVIATIONS, AND NOTES.

CKT. G&H: 3\*4, 1\*6 GND 1/4" UD  
 IN CONCRETE ENCASED CNC DUCT BANK, UNO,  
 TO BE DONE BY OTHERS IN CONTRACT 62301  
 APPROX. 35 FEET.

 CKT. G&H: 3\*4, 1\*6 GND 1/4" UD  
 IN CONCRETE ENCASED CNC DUCT BANK, UNO,  
 TO BE DONE BY OTHERS IN CONTRACT 62301  
 APPROX. 25 FEET.



REVISIONS	
NAME	DATE

ILLINOIS DEPARTMENT OF TRANSPORTATION  
 F.A.I. 94/90 (DAN RYAN EXPRESSWAY)  
 31st STREET TO I-57

**ROADWAY LIGHTING PLANS  
 FINAL IMPROVEMENTS**

SCALE: 1"=50'  
 DATE: OCTOBER 29, 2004  
 DRAWN BY: BL  
 CHECKED BY: SM

**K&J** KAM ENGINEERING, INC.  
 CONSULTING ENGINEERS  
 707A Davis Road, Suite 205  
 Elgin, Illinois 60123-1369

RL08-39

03/25/2004 03:54:47 PM