


F.A.I. RTE.	SECTION	COUNTY	TOTAL SHEETS	SHEET NO.
94/90	2003-0311	COOK	976	299
STA. 1584+00	TO STA. 1596+00			
FED. ROAD DIST. NO.	ILLINOIS	FED. AID PROJECT		
62583				



NOTES:  
 1. SEE SHEET ME-01 FOR ELECTRICAL SYMBOLS, ABBREVIATIONS, AND NOTES.

 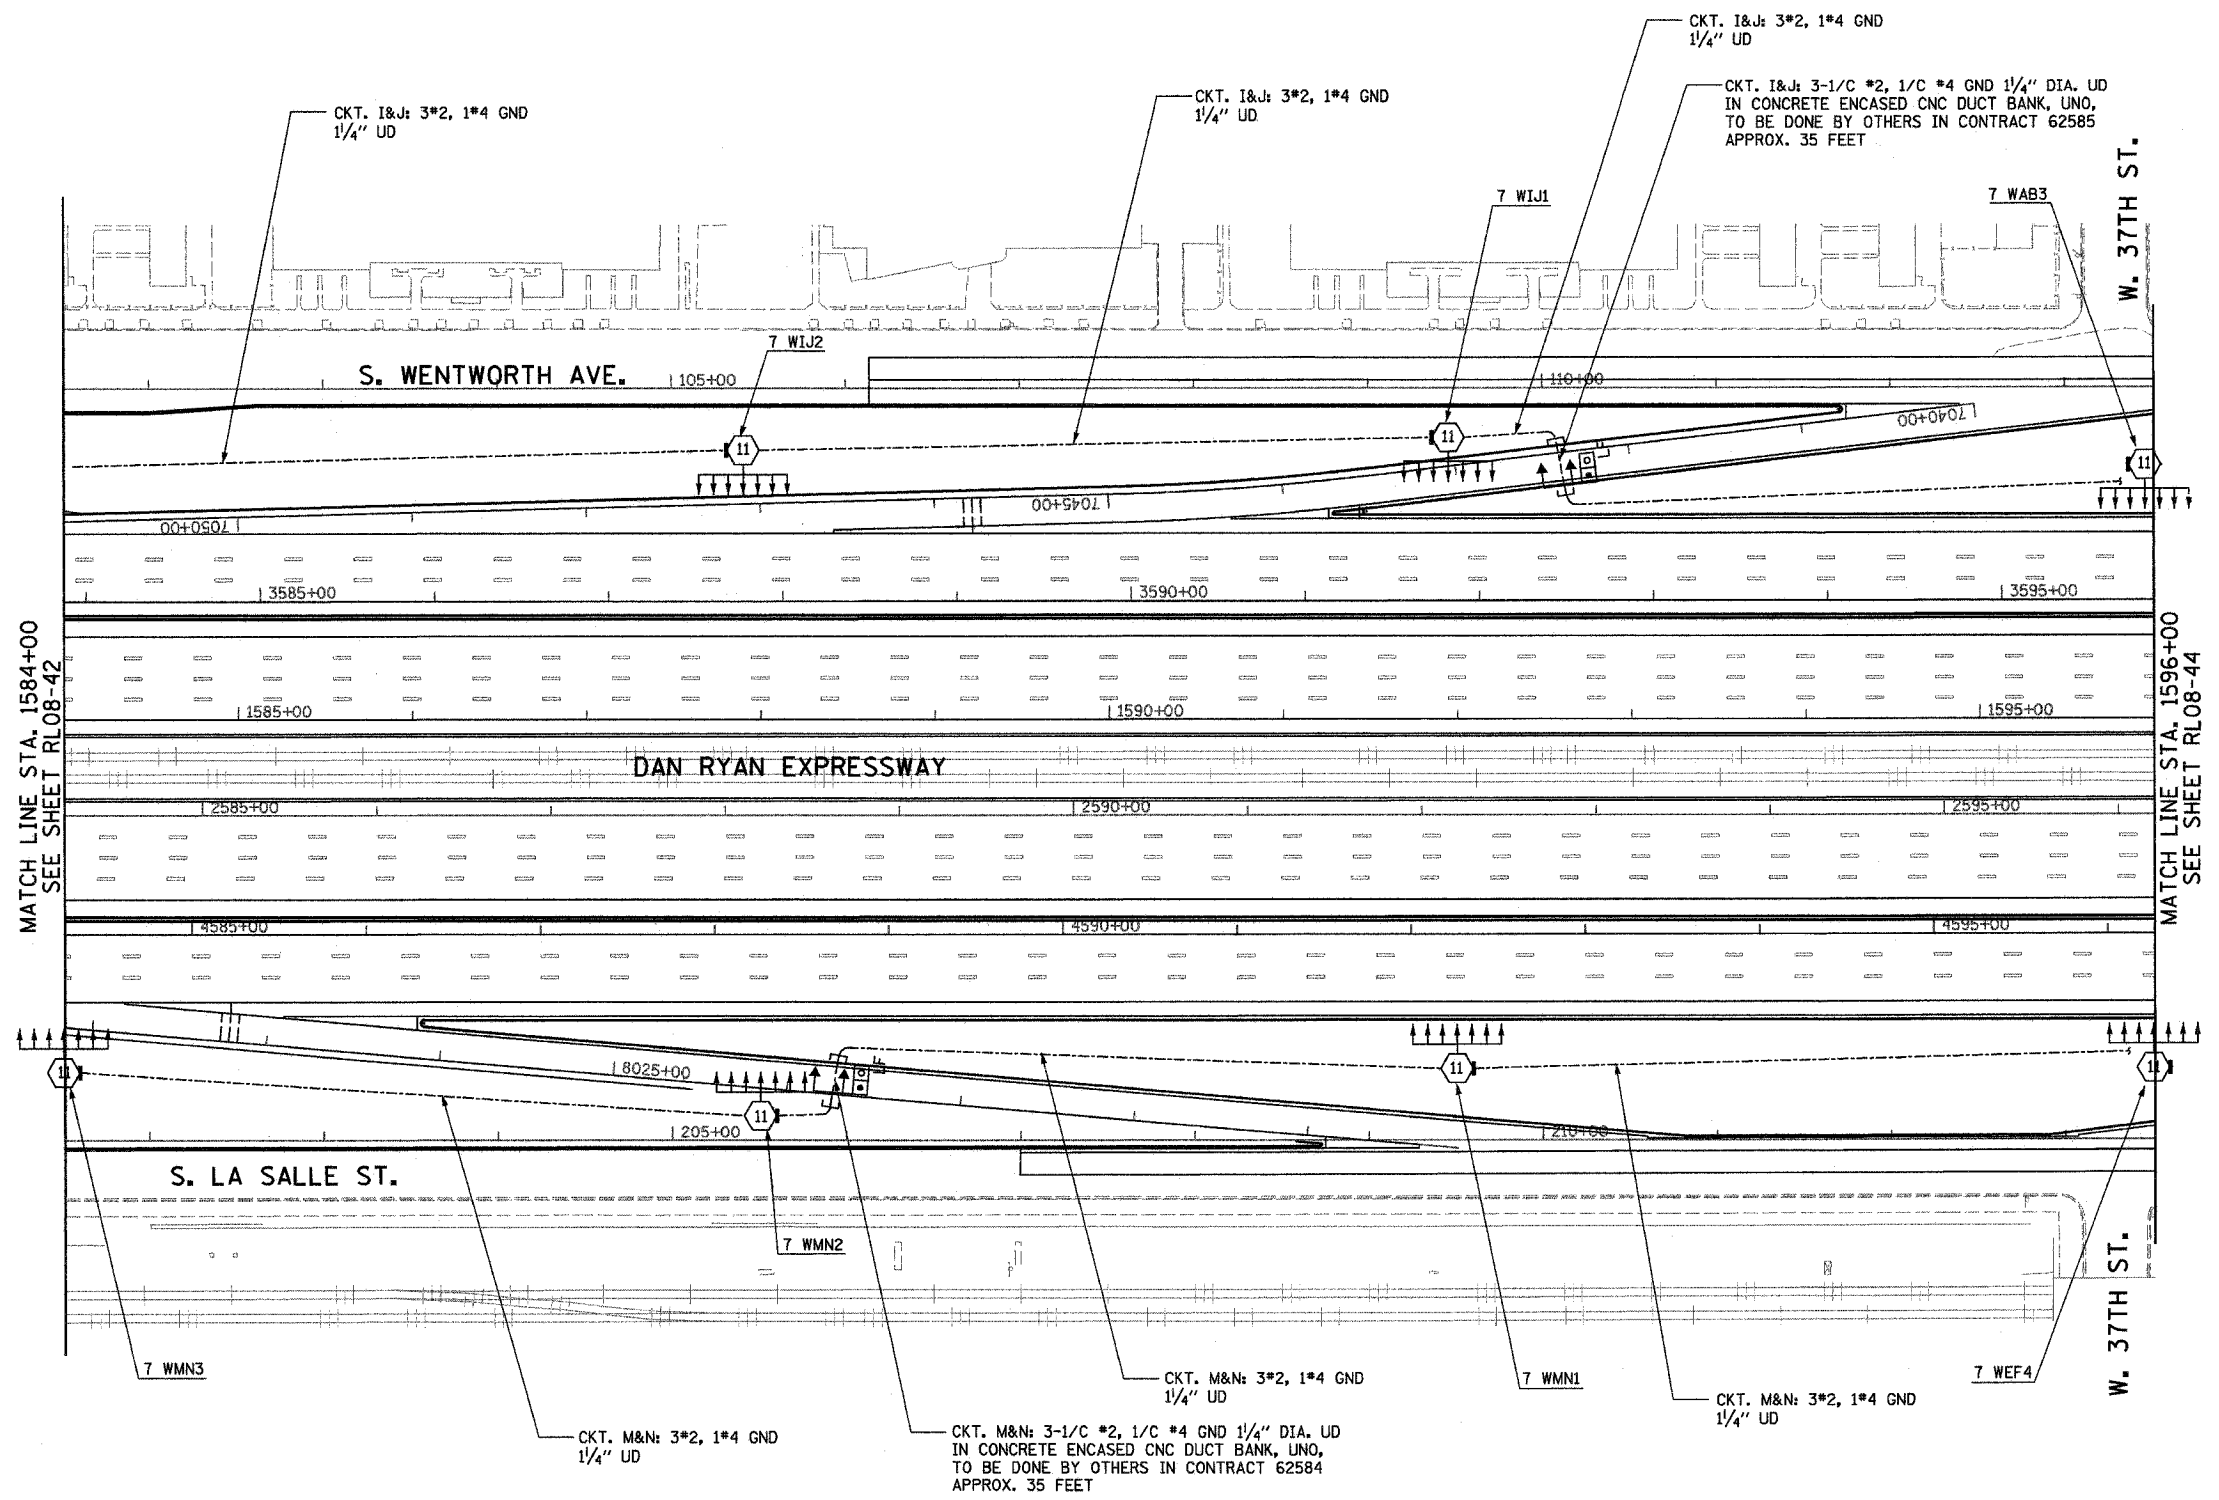


MATCH LINE STA. 1584+00  
SEE SHEET RL08-42

MATCH LINE STA. 1596+00  
SEE SHEET RL08-44

RL08-43

**KAM ENGINEERING, INC.**  
 CONSULTING ENGINEERS  
 707A Davis Road, Suite 205  
 Elgin, Illinois 60123-1369



REVISIONS	
NAME	DATE

ILLINOIS DEPARTMENT OF TRANSPORTATION  
 F.A.I. 94/90 (DAN RYAN EXPRESSWAY)  
 31st STREET TO I-57

**ROADWAY LIGHTING PLANS  
 FINAL IMPROVEMENTS**

SCALE: 1"=50'  
 DATE: OCTOBER 29, 2004

DRAWN BY: BL  
 CHECKED BY: SM

03.26.09 PM 10/15/2004