


F.A.I. RTE.	SECTION	COUNTY	TOTAL SHEETS	SHEET NO.
94/90	2003-0311	COOK	976	340
STA.	TO STA.			
FED. ROAD DIST. NO.	ILLINOIS	FED. AID PROJECT		
62583				

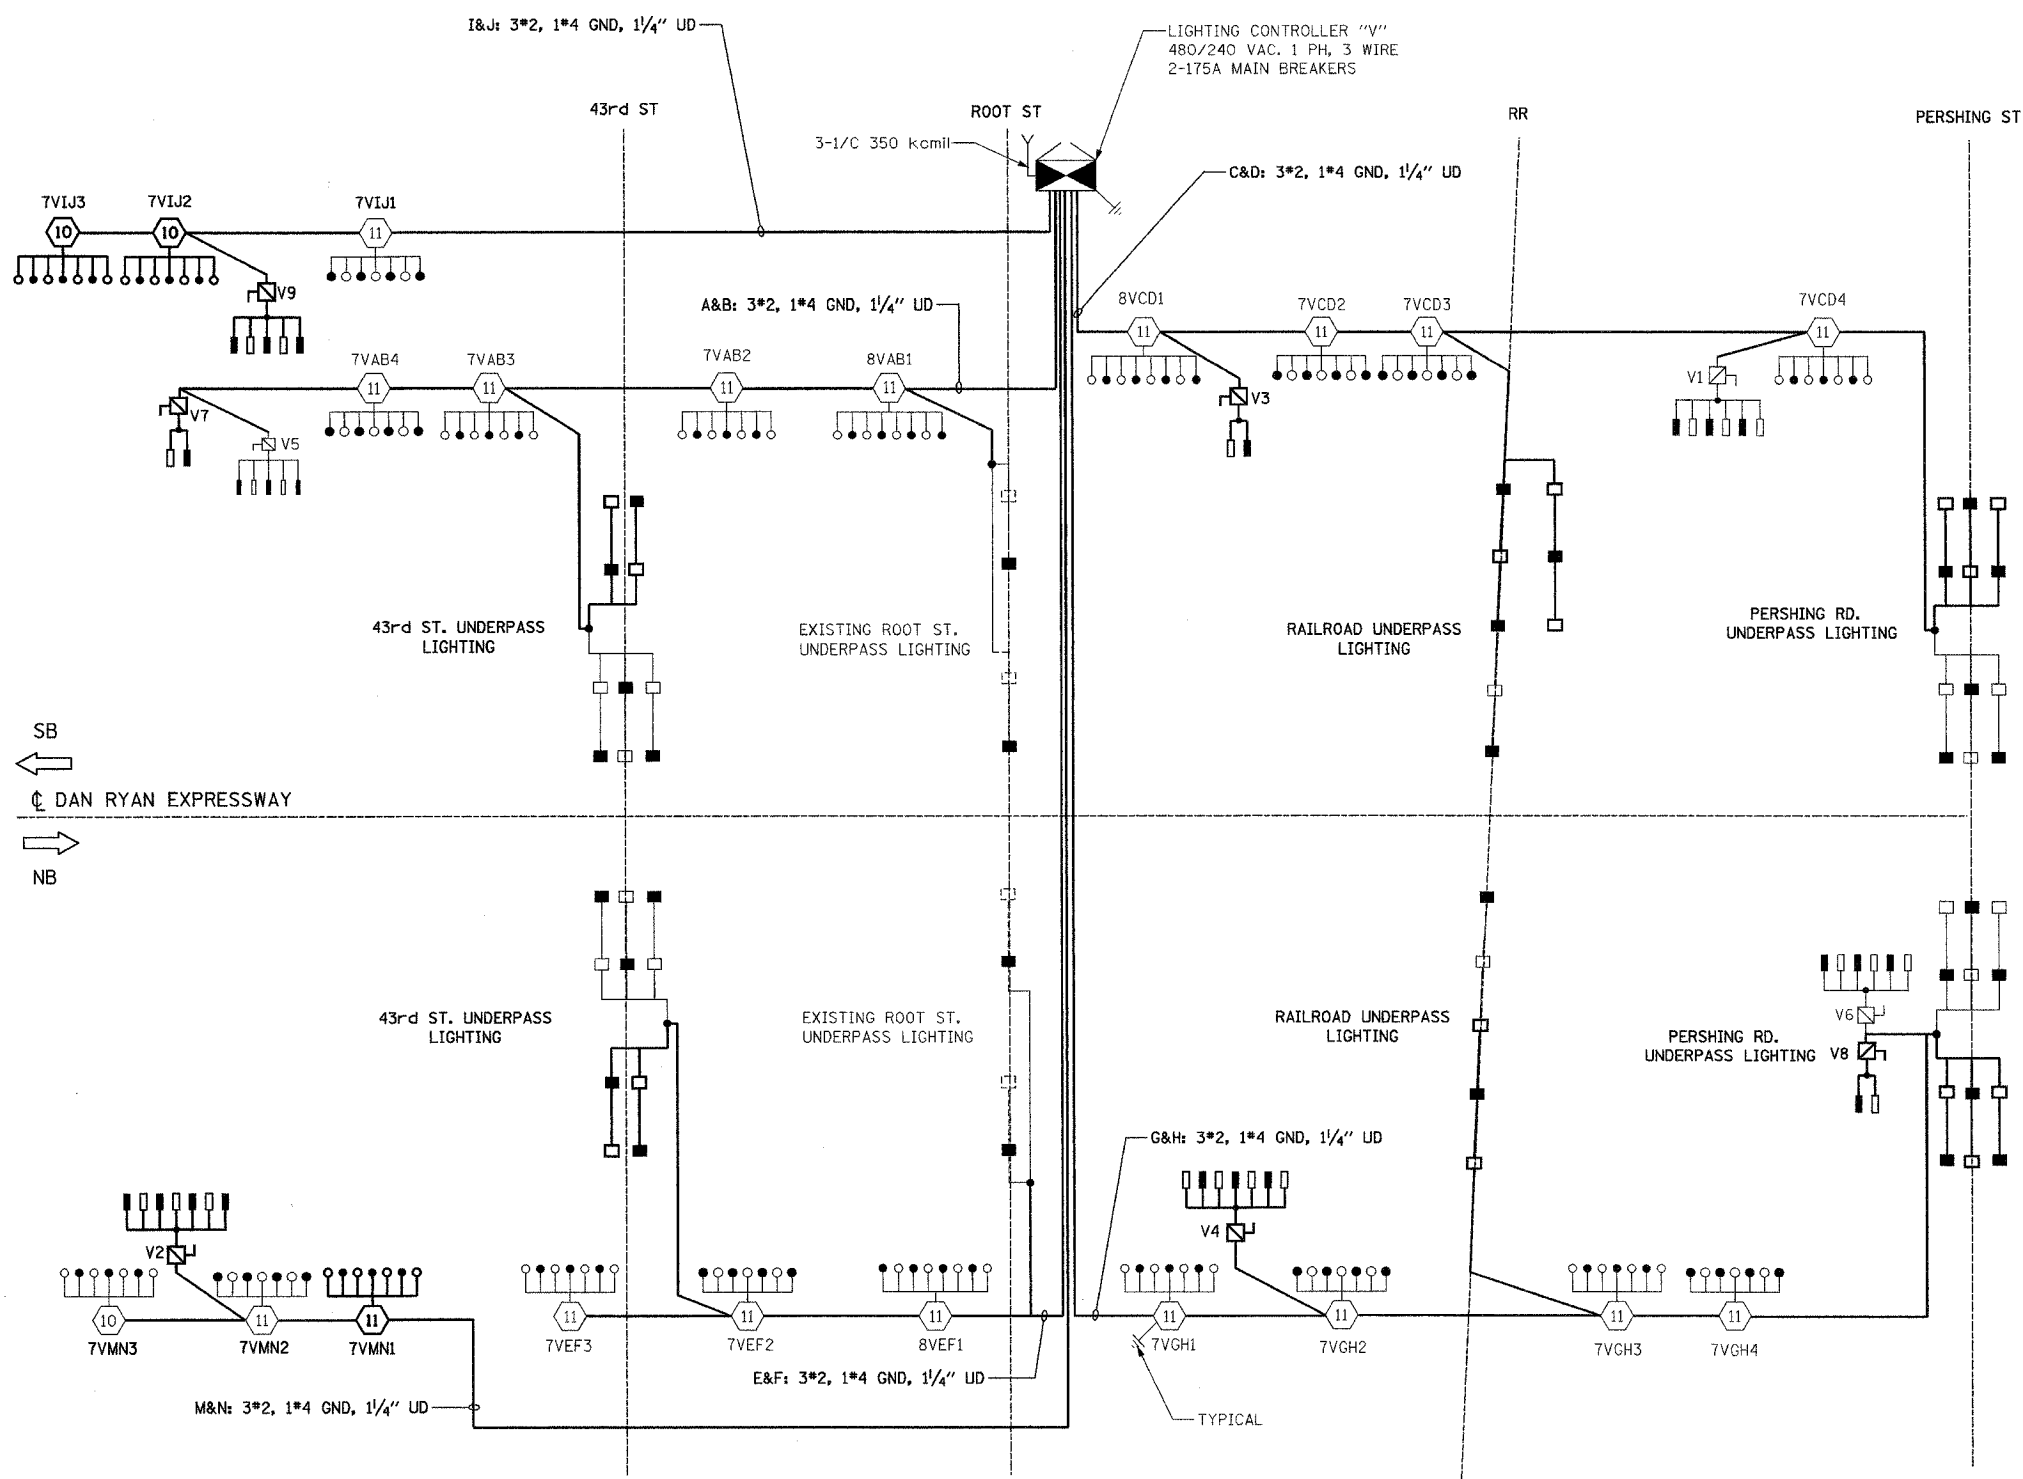

- LEGEND:**
- HIGH MAST LIGHT TOWER
 - 400W. HPS LUMINAIRE (BLACK PHASE- SOLID SYMBOLS, RED PHASE-OPEN SYMBOL)
 - 7VCD1 HIGH MAST TOWER DESIGNATION
 - LIGHTING CONTROLLER
 - GROUND FIELD
 - ELECTRIC UTILITY SERVICE
 - UNIT DUCT, 3-1/C #2 WITH 1/C #4 GROUND, 1/4"
 - LIGHTED SIGN STRUCTURE WITH 170 W. FLUORESCENT LUMINAIRE. QUANTITY OF LUMINAIRE AS REQUIRED. (BLACK PHASE- SOLID SYMBOLS, RED PHASE, OPEN SYMBOL)
 - 3 POLE SAFETY SWITCH
 - UNDERPASS LIGHTING UNIT, 70W HPS LUMINAIRE. (BLACK PHASE- SOLID SYMBOL, RED PHASE-OPEN SYMBOL)
 - UNDERPASS LIGHTING UNIT, 55W HPS LUMINAIRE. (BLACK PHASE- SOLID SYMBOL, RED PHASE-OPEN SYMBOL)

**LOAD TABLE
LIGHTING CONTROLLER "V"**

CIRCUIT	RED PHASE		BLACK PHASE		
	AMPS	WATTS	CIRCUIT	AMPS	WATTS
A	35.10	6970	B	33.90	6740
C	35.20	6980	D	37.20	7380
E	24.00	4750	F	24.00	4750
G	38.00	7590	H	36.80	7350
I	23.60	4740	J	22.40	4510
K	SPARE	SPARE	L	SPARE	SPARE
M	24.40	4910	N	23.20	4680
O	SPARE	SPARE	P	SPARE	SPARE
TOTAL	180.30A	35,940	TOTAL	177.50A	35,410

REVISIONS	
NAME	DATE

ILLINOIS DEPARTMENT OF TRANSPORTATION
 F.A.I. 94/90 (DAN RYAN EXPRESSWAY)
 31st STREET TO I-57

**SINGLE LINE DIAGRAM
 LIGHTING CONTROLLER "V"
 PROPOSED IMPROVEMENTS 2007**

SCALE: NONE DRAWN BY: BL
 DATE: OCTOBER 29, 2004 CHECKED BY: SM

K&E KAM ENGINEERING, INC.
 CONSULTING ENGINEERS
 707A Davis Road, Suite 205
 Elgin, Illinois 60123-1369

SL07-11

11/30/2004 11:30:24 AM