


SECTION	COUNTY	TOTAL SHEETS	SHEET NO.
2003-031I	COOK	976	823
STA.	TO STA.		
FED. ROAD DIST. NO. - ILLINOIS	FED. AID PROJECT		
62583			

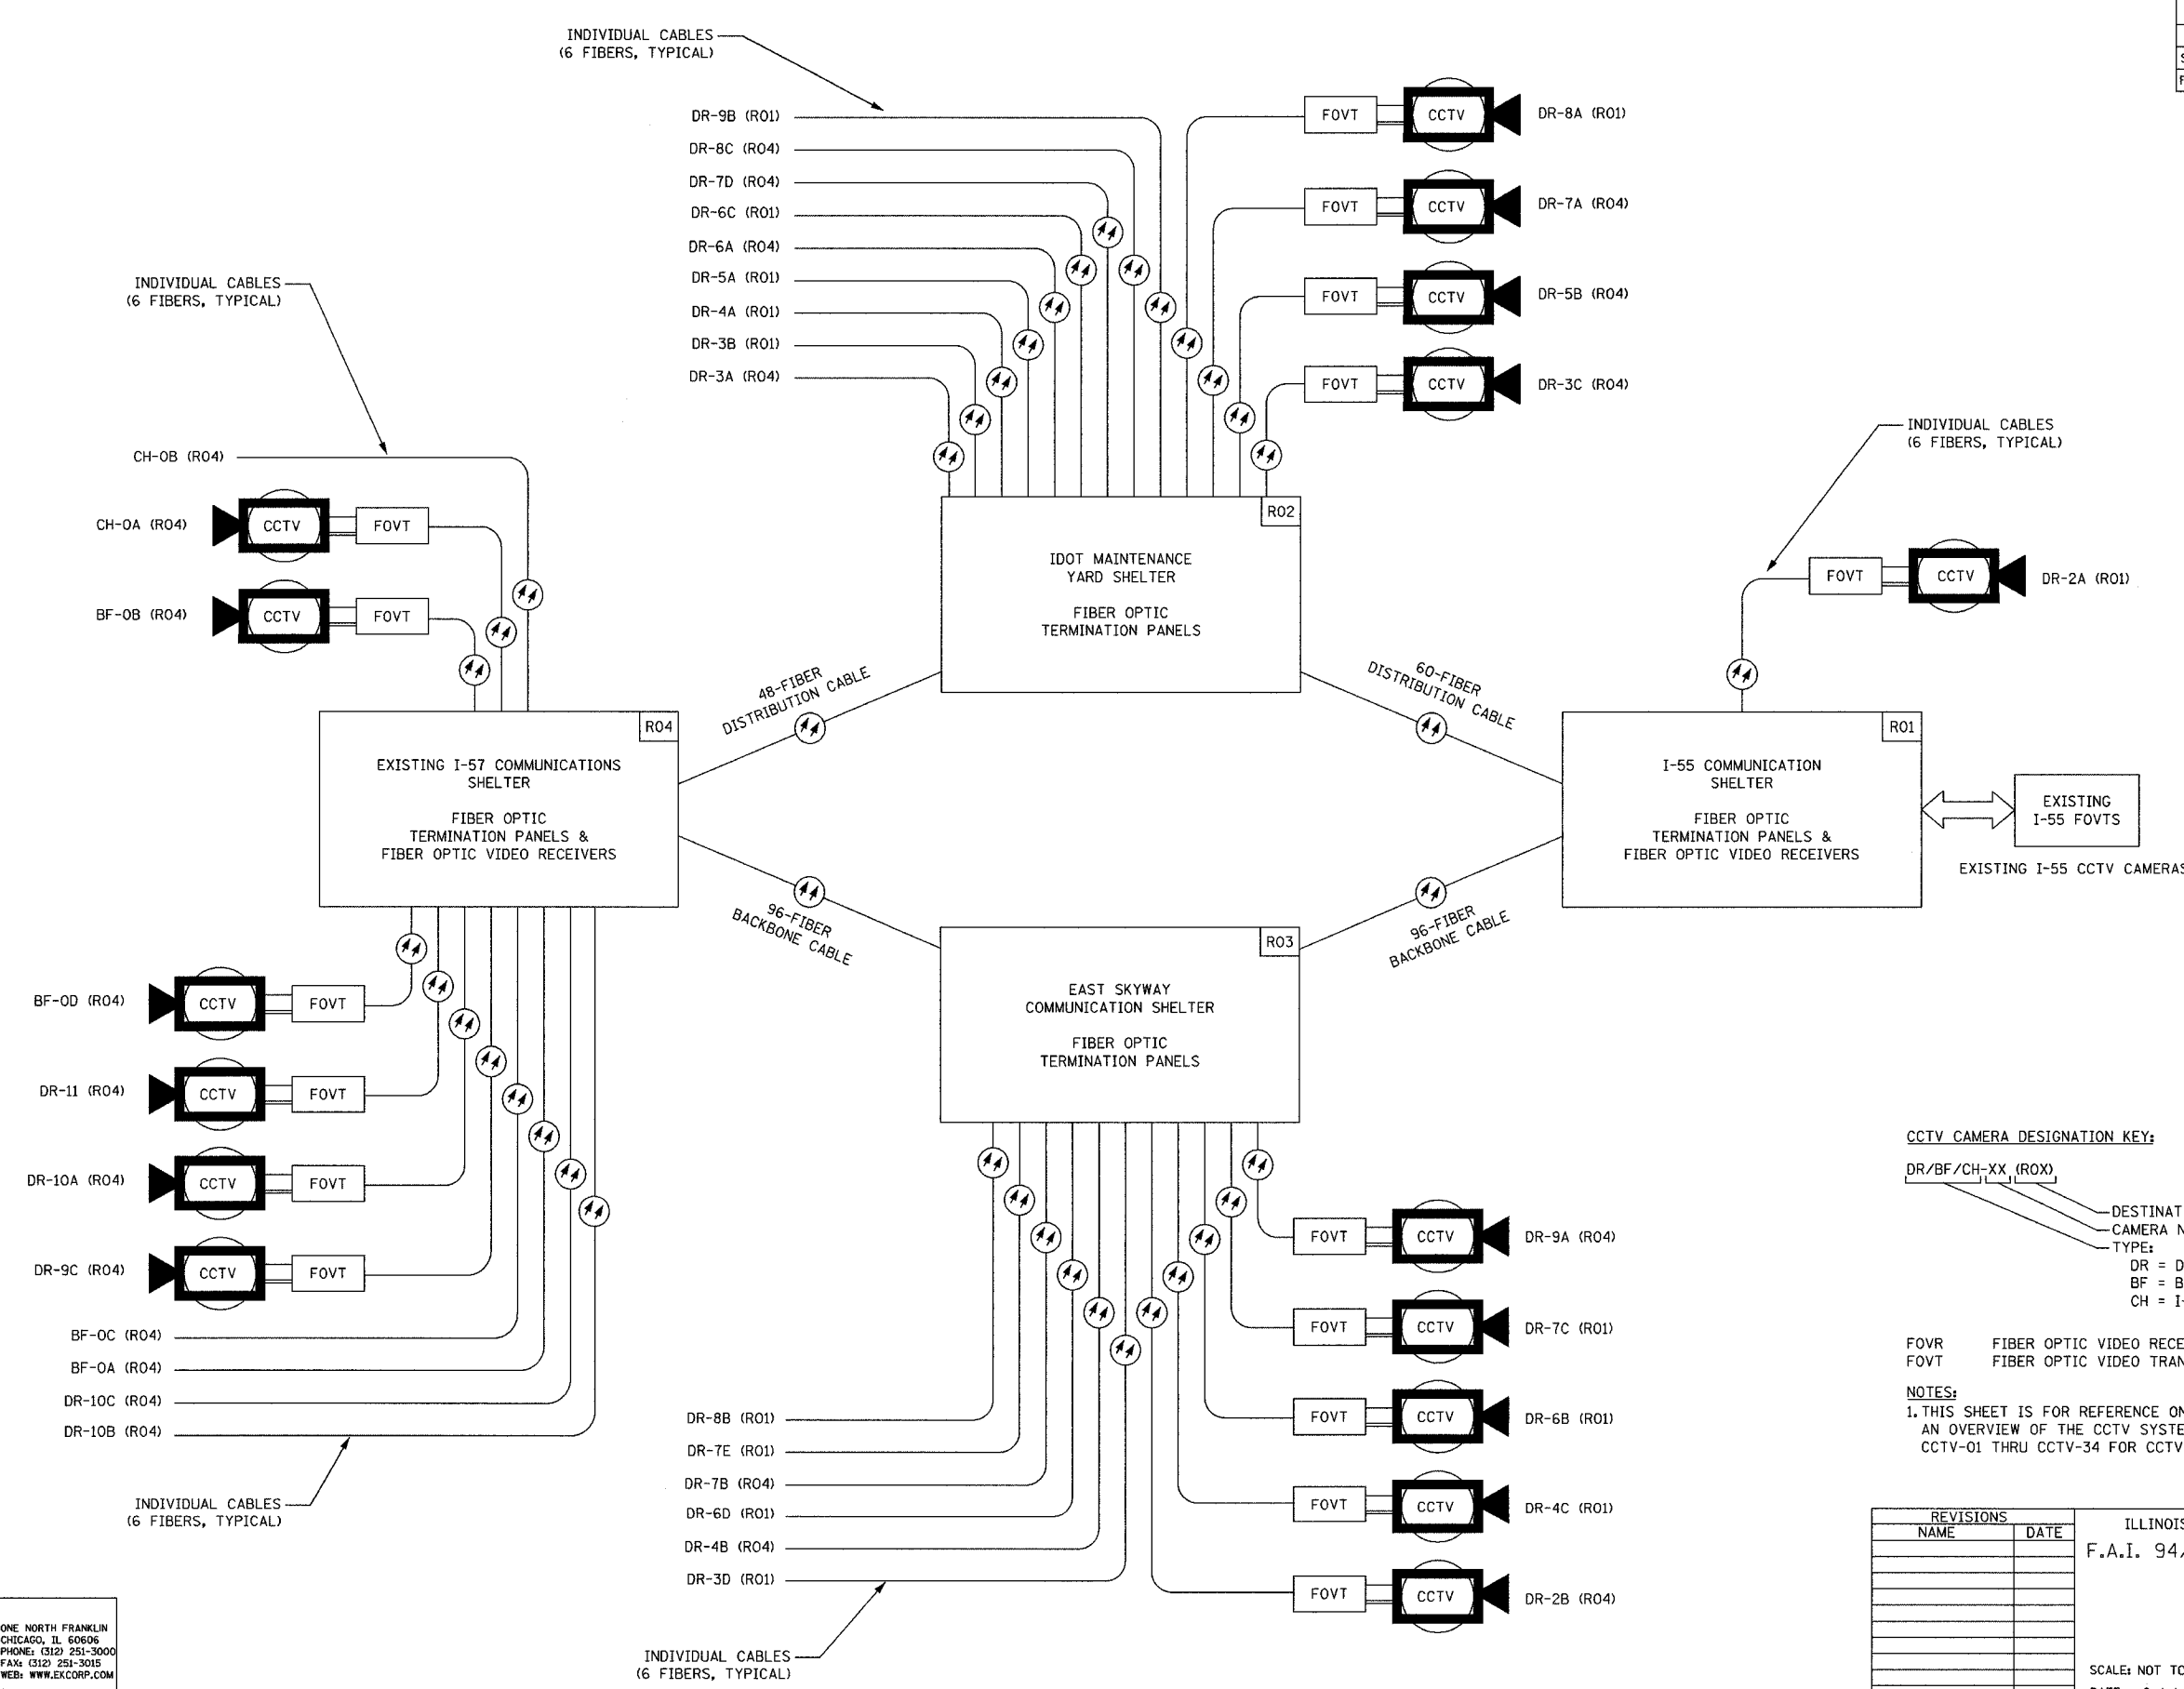

CCTV CAMERA DESIGNATION KEY:
 DR/BF/CH-XX (ROX)
 DESTINATION NODE
 CAMERA NUMBER
 TYPE:
 DR = DAN RYAN
 BF = BISHOP FORD
 CH = I-57

FOVR FIBER OPTIC VIDEO RECEIVER
 FOVT FIBER OPTIC VIDEO TRANSMITTER

NOTES:
 1. THIS SHEET IS FOR REFERENCE ONLY AND PROVIDES AN OVERVIEW OF THE CCTV SYSTEM. SEE SHEETS CCTV-01 THRU CCTV-34 FOR CCTV PLAN DRAWINGS.

REVISIONS	
NAME	DATE

ILLINOIS DEPARTMENT OF TRANSPORTATION
 F.A.I. 94/90 (DAN RYAN EXPRESSWAY)
 31st STREET to I-57
 CCTV VIDEO OVERVIEW
 SCALE: NOT TO SCALE
 DATE: October 29, 2004
 DRAWN BY: DH1
 CHECKED BY: JEZ

Edwards AND Kelcey
 ONE NORTH FRANKLIN
 CHICAGO, IL 60606
 PHONE: (312) 251-3000
 FAX: (312) 251-3015
 WEB: WWW.EKCORP.COM

COMM-57

11/22/2004 04:32 PM