
 
 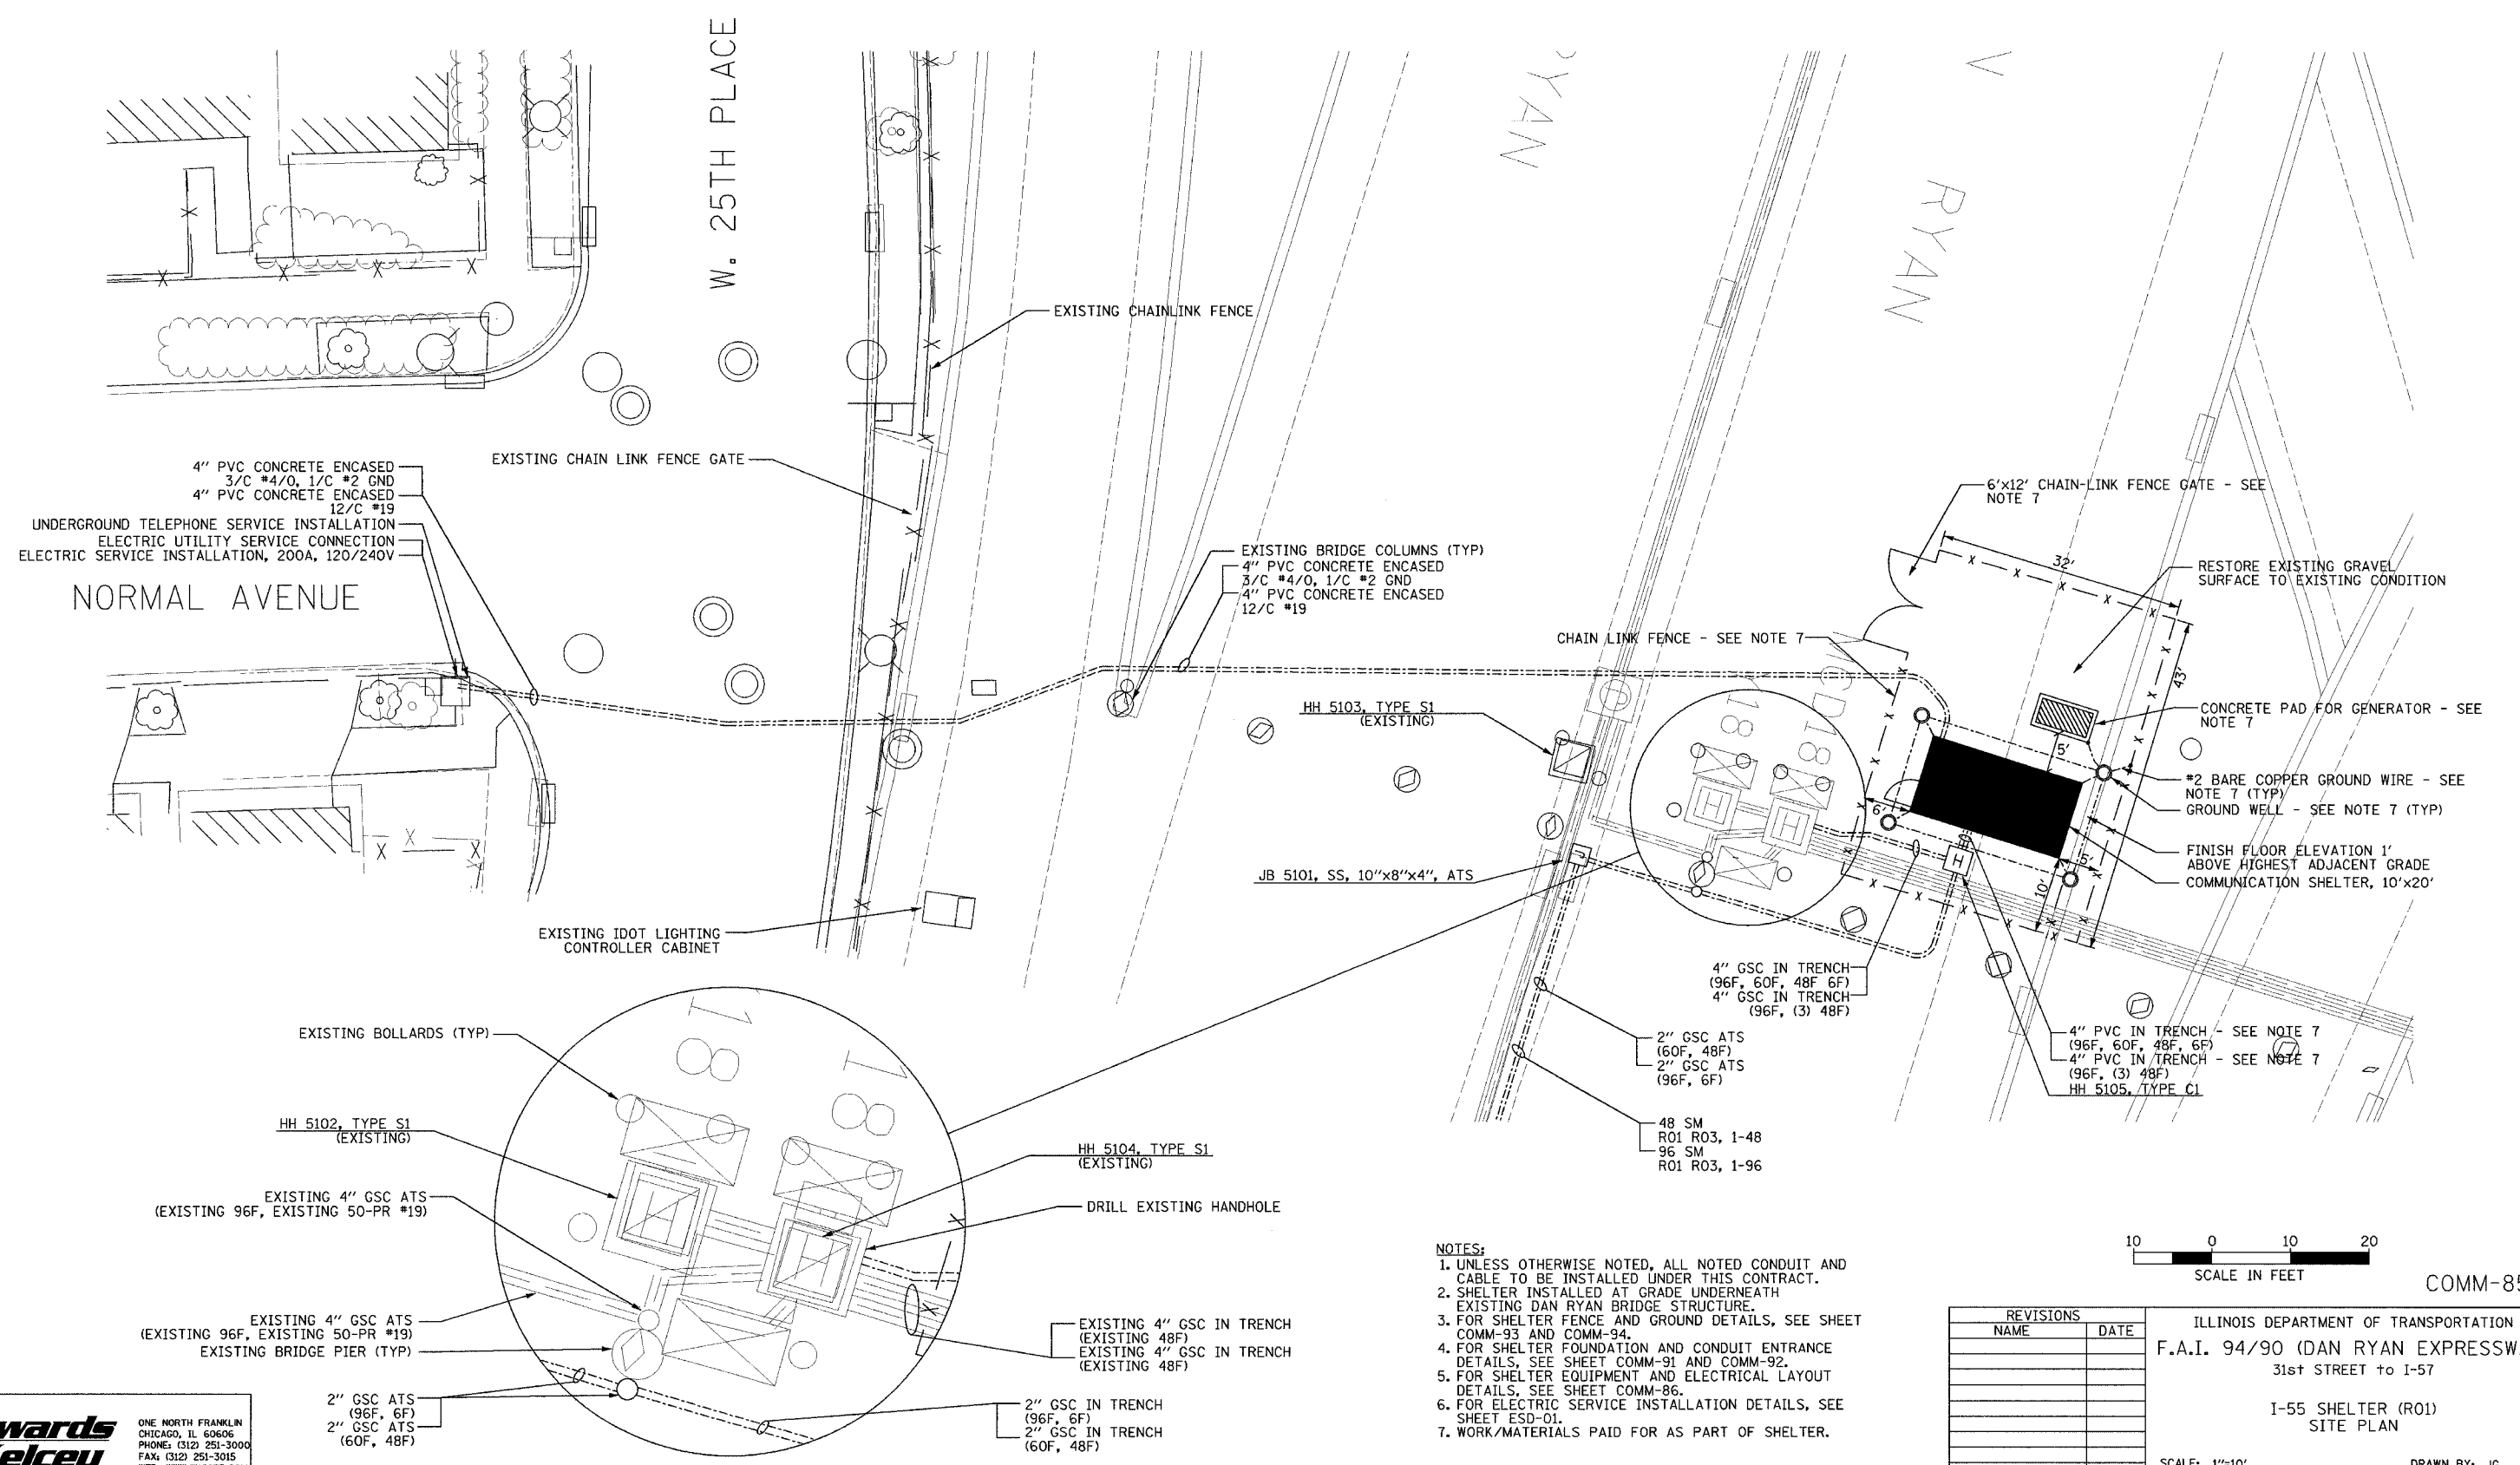


SECTION	COUNTY	TOTAL SHEETS	SHEET NO.
2003-0311	COOK	976	851
STA.	TO STA.		
FED. ROAD DIST. NO.	ILLINOIS	FED. AID PROJECT	
		62583	



- NOTES:**
1. UNLESS OTHERWISE NOTED, ALL NOTED CONDUIT AND CABLE TO BE INSTALLED UNDER THIS CONTRACT.
 2. SHELTER INSTALLED AT GRADE UNDERNEATH EXISTING DAN RYAN BRIDGE STRUCTURE.
 3. FOR SHELTER FENCE AND GROUND DETAILS, SEE SHEET COMM-93 AND COMM-94.
 4. FOR SHELTER FOUNDATION AND CONDUIT ENTRANCE DETAILS, SEE SHEET COMM-91 AND COMM-92.
 5. FOR SHELTER EQUIPMENT AND ELECTRICAL LAYOUT DETAILS, SEE SHEET COMM-86.
 6. FOR ELECTRIC SERVICE INSTALLATION DETAILS, SEE SHEET ESD-01.
 7. WORK/MATERIALS PAID FOR AS PART OF SHELTER.



COMM-85

REVISIONS	
NAME	DATE

ILLINOIS DEPARTMENT OF TRANSPORTATION
F.A.I. 94/90 (DAN RYAN EXPRESSWAY)
 31st STREET to I-57

I-55 SHELTER (R01)
SITE PLAN

 SCALE: 1"=10'
 DATE: October 29, 2004
 DRAWN BY: JG
 CHECKED BY: MJL/JEZ

Edwards and Kelcey
 ONE NORTH FRANKLIN
 CHICAGO, IL 60606
 PHONE: (312) 251-3000
 FAX: (312) 251-3015
 WEB: WWW.EKCORP.COM

P:\030019\03035\7\5\CA40\PP020032E.SHT 11/23/2004 11:23:55 AM