


F.A.I. RTE.	SECTION	COUNTY	TOTAL SHEETS	SHEET NO.
94/90	2003-0311	COOK	976	861
STA.		TO STA.		
FED. ROAD DIST. NO.	ILLINOIS	FED. AID PROJECT		
62583				

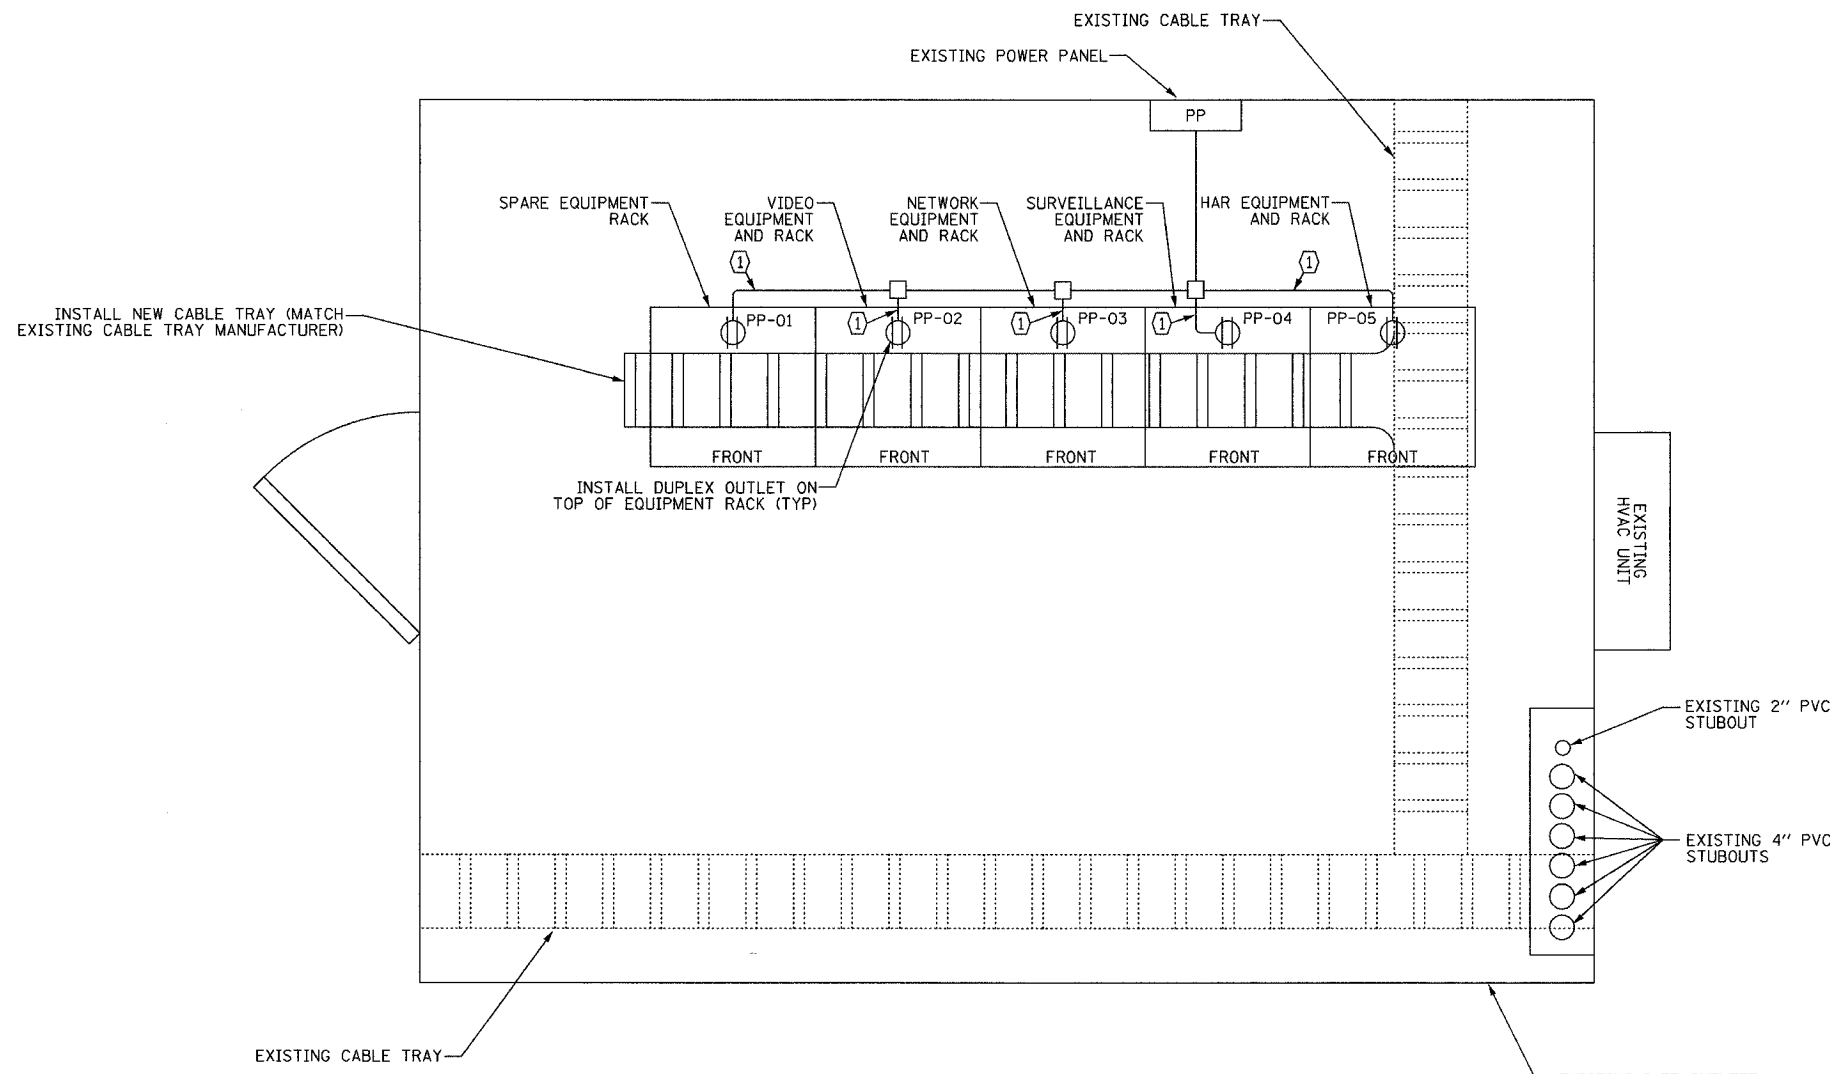

I-57 SHELTER FLOOR PLAN  
NOT TO SCALE

- NOTES:**
- EQUIPMENT LAYOUT BASED ON PRELIMINARY SHELTER INSPECTION. CONTRACTOR MAY NEED TO FIELD LOCATE EQUIPMENT RACKS AND EQUIPMENT. COORDINATE WITH THE ENGINEER THE FINAL LOCATION OF ALL EQUIPMENT.
  - CONTRACTOR SHALL MAINTAIN A MINIMUM OF 36" CLEARANCE WHEN INSTALLING NEW RACKS AND EQUIPMENT.

(1) (2) #12, (1) #12 GND, 3/4" EMT CONDUIT

REVISIONS	
NAME	DATE

ILLINOIS DEPARTMENT OF TRANSPORTATION  
F.A.I. 94/90 (DAN RYAN EXPRESSWAY)  
31st STREET to I-57  
  
I-57 SHELTER (R04)  
EQUIPMENT LAYOUT  
  
SCALE: NOT TO SCALE  
DATE: October 29, 2004  
  
DRAWN BY: DHI  
CHECKED BY: JEZ

**Edwards AND Kelcey**  
ONE NORTH FRANKLIN  
CHICAGO, IL 60606  
PHONE: (312) 251-3000  
FAX: (312) 251-3015  
WEB: WWW.EKCORP.COM

F:\030019\035\TSCADD\0120342E.SHT 11/23/2004 12:45:05 PM