
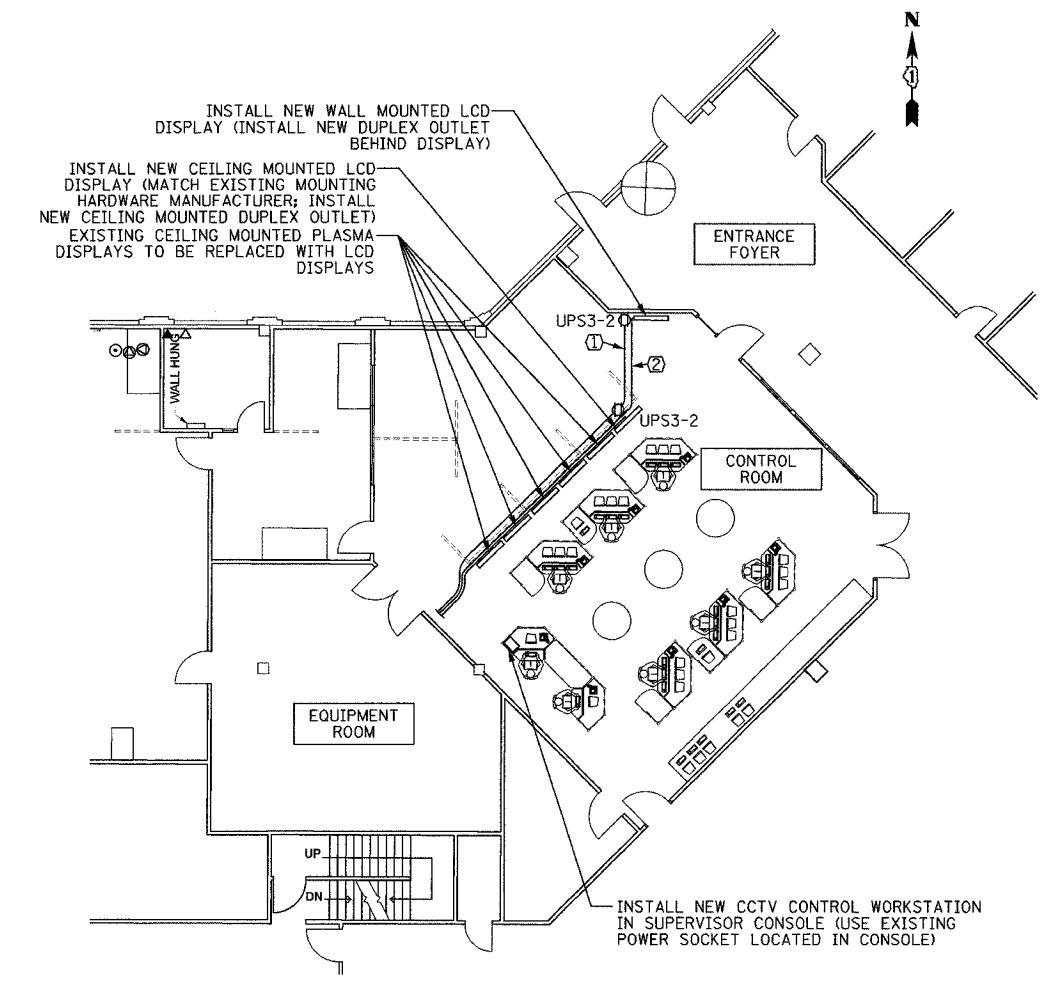


SECTION	COUNTY	TOTAL SHEETS	SHEET NO.
2003-03II	COOK	976	867
STA.	TO STA.		
FED. ROAD DIST. NO.	ILLINOIS	FED. AID PROJECT	
62583			

NOTES:

- FINAL LOCATION OF CABINETS AND EQUIPMENT SHALL BE COORDINATED AND APPROVED BY THE ENGINEER.
- CONTRACTOR SHALL PROVIDE ADDITIONAL CABLE TO MOVE RACKS FORWARD TO PROVIDE ACCESS TO REAR OF CABINET.
- MOBILE SYSTEM TESTER TO BE RELOCATED BY IDOT.

- ① (2) #12 & (1) #12 GND, 3/4" C
- ② PLENUM RATED COAX CABLE
- ③ PLENUM RATED CAT-5 CABLE

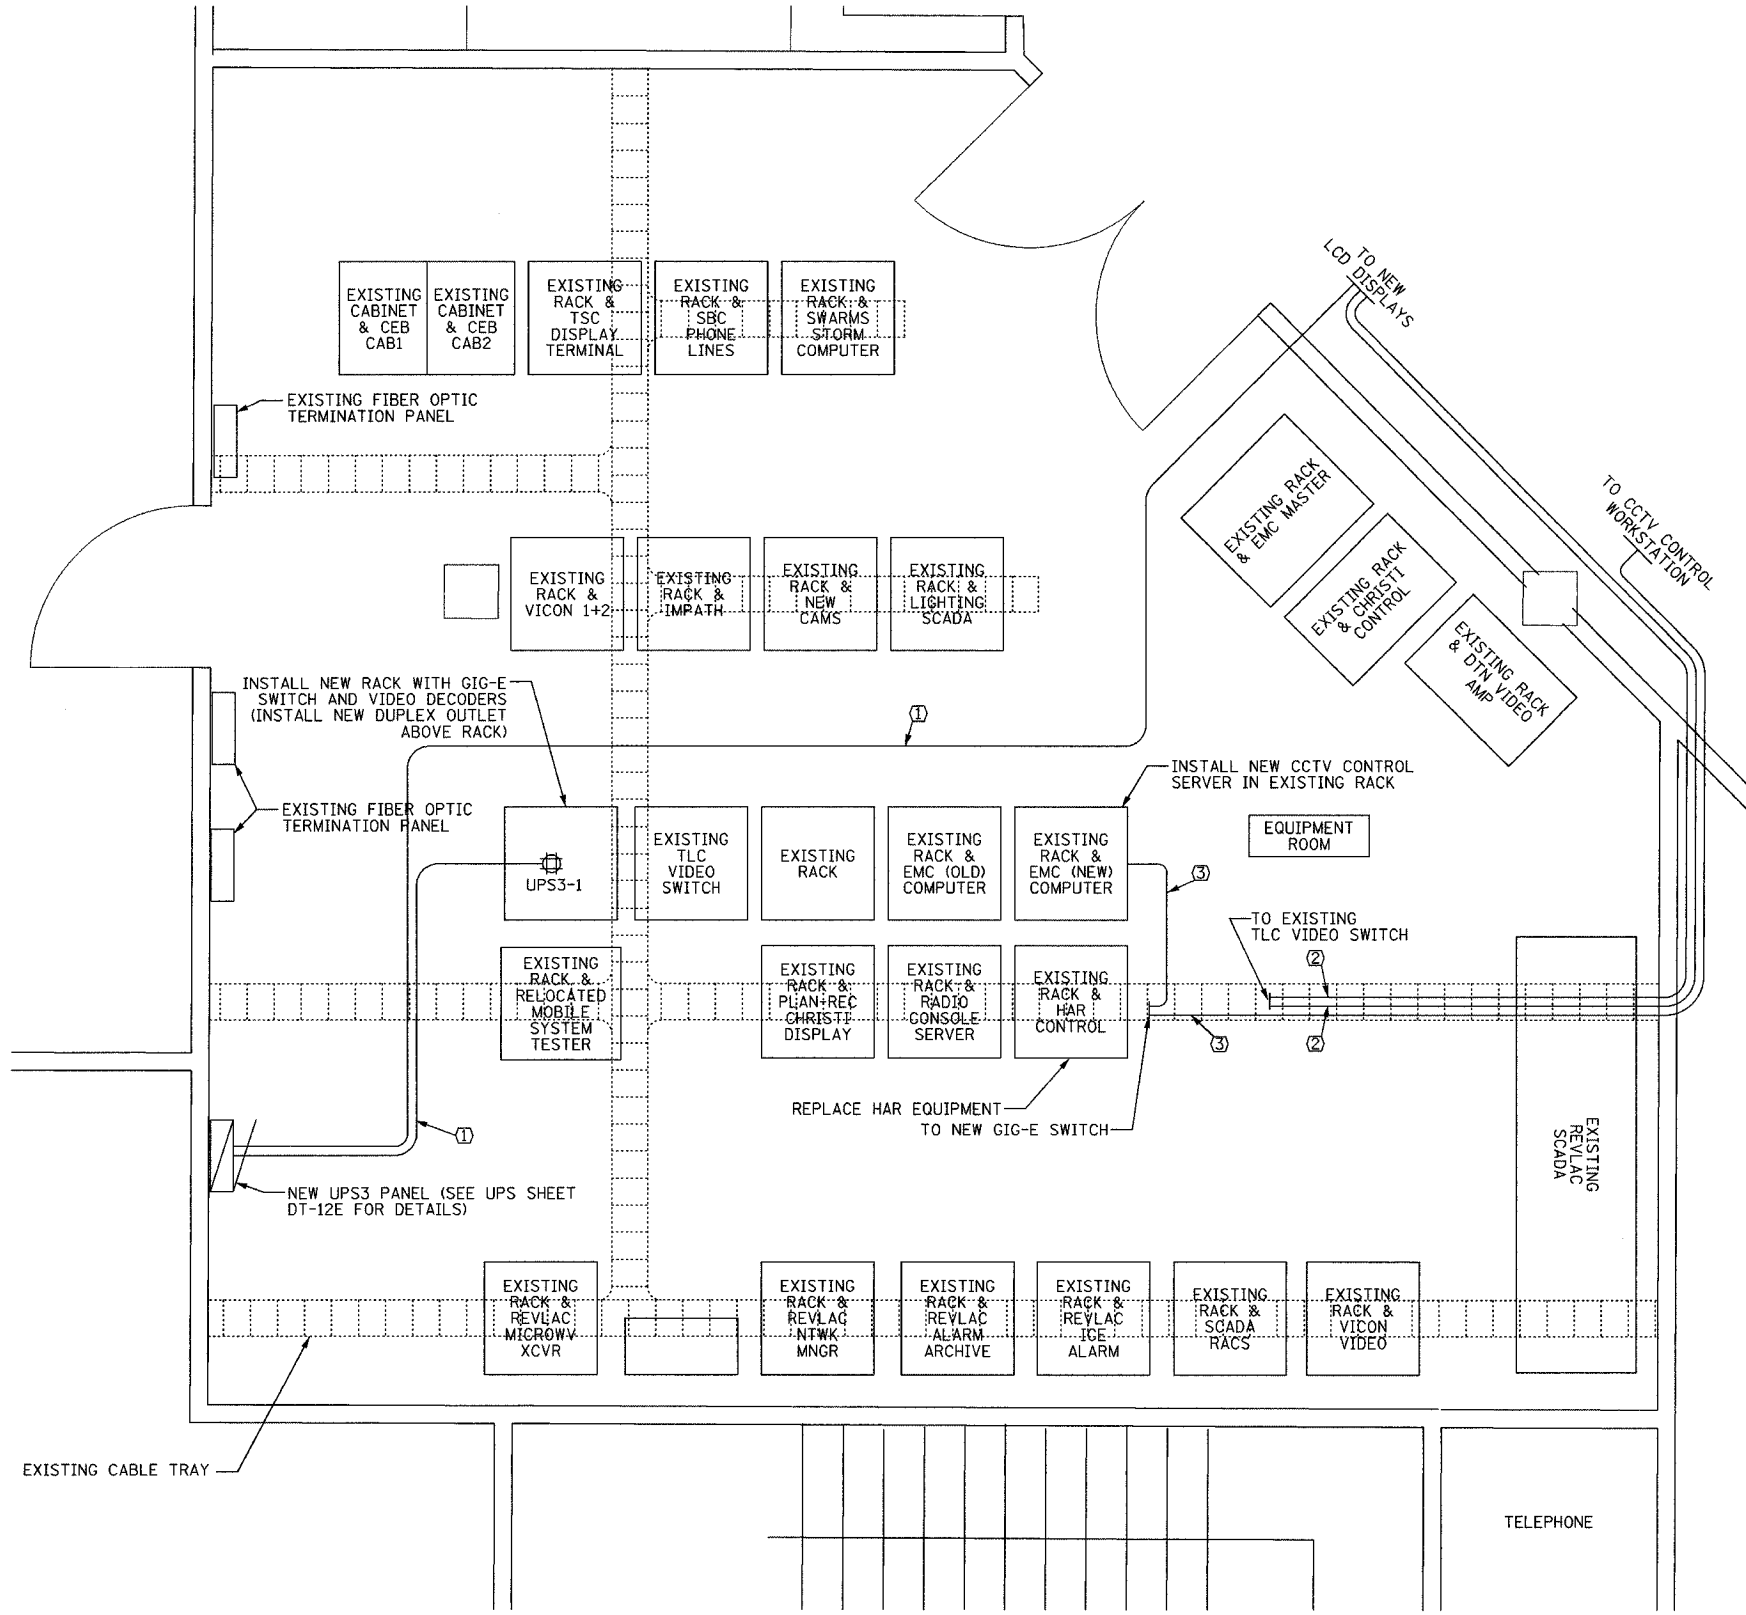

Edwards AND Kelcey
 ONE NORTH FRANKLIN
 CHICAGO, IL 60606
 PHONE: (312) 251-3000
 FAX: (312) 251-3015
 WEB: WWW.EKCORP.COM

REVISIONS	
NAME	DATE

ILLINOIS DEPARTMENT OF TRANSPORTATION
 F.A.I. 94/90 (DAN RYAN EXPRESSWAY)
 31st STREET to I-57
 COMMUNICATIONS CENTER (SCHAUMBURG)
 SITE PLAN

SCALE: NOT TO SCALE
 DATE: October 29, 2004

DRAWN BY: DHI
 CHECKED BY: JEZ

P:\03009035\NT\SCAD\VP\020052E.SHT 11/23/2004 12:44:26 PM