
 


SECTION	COUNTY	TOTAL SHEETS	SHEET NO.
2003-0311	COOK	976	873
STA.	TO STA.		
FED. ROAD DIST. NO.	ILLINOIS FED. AID PROJECT		
62583			

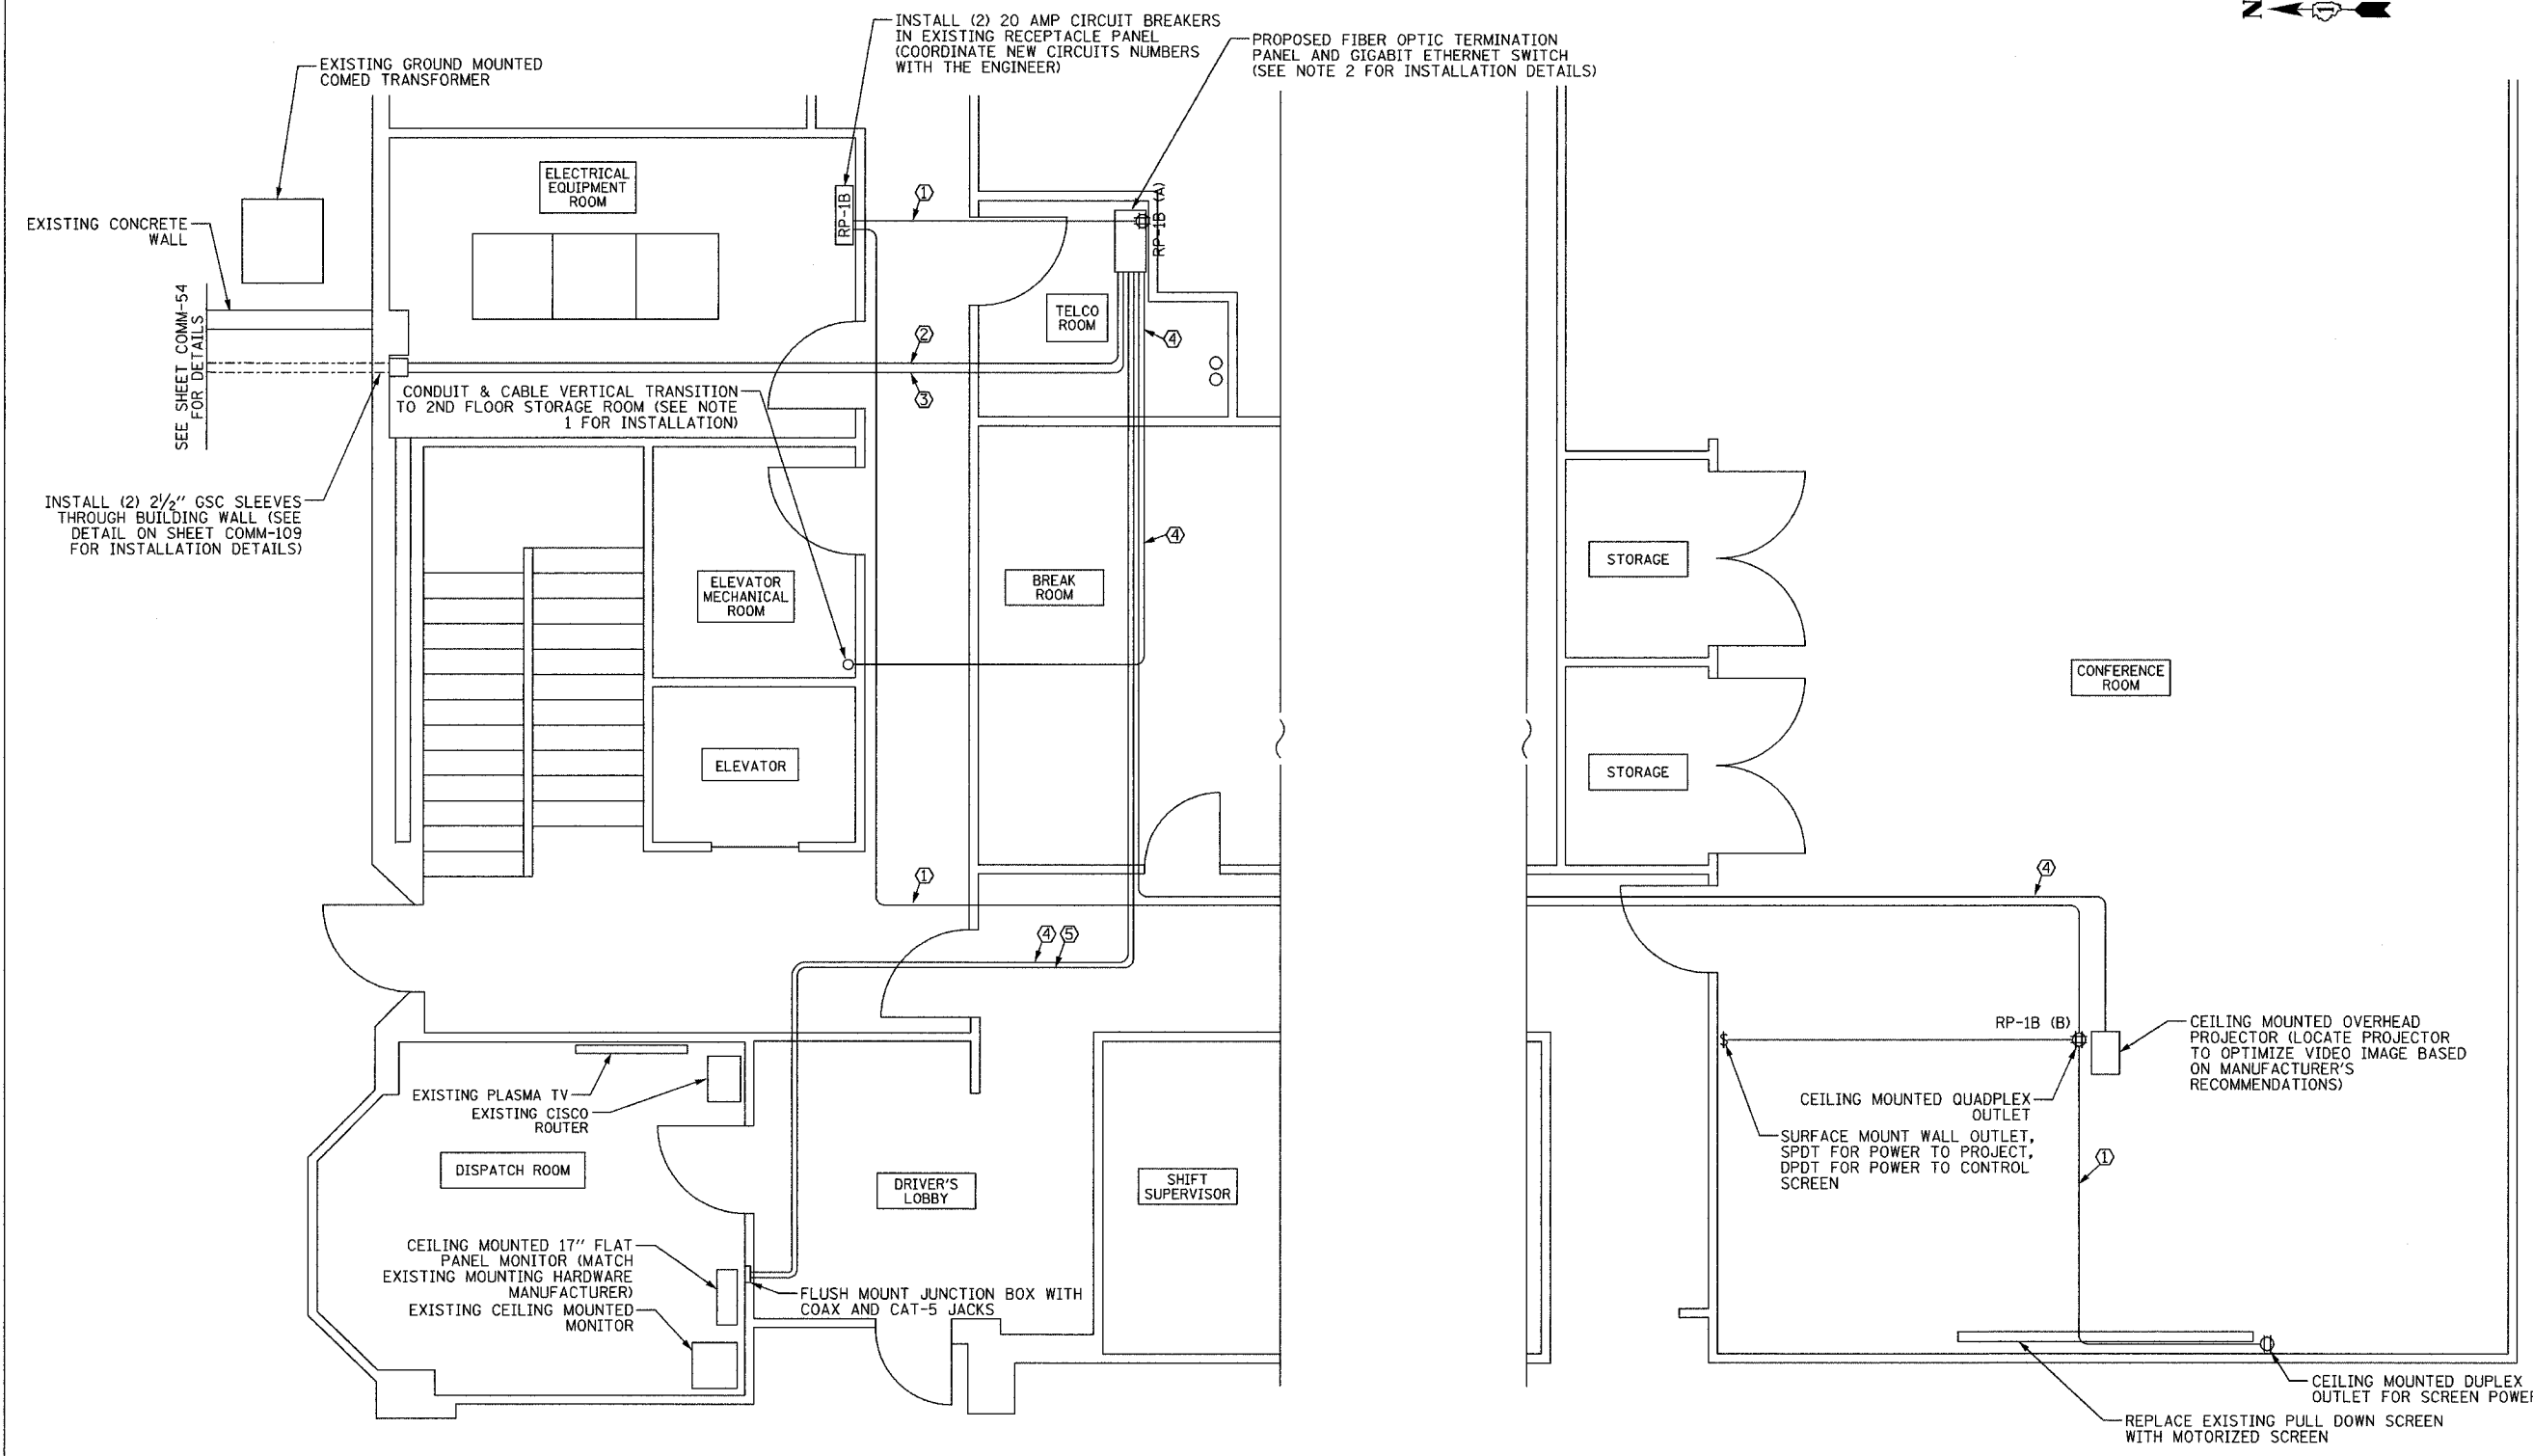

PARTIAL FIRST FLOOR PLAN
NOT TO SCALE



NOTES:

- CONTRACTOR SHALL COORDINATE WITH EMERGENCY TRAFFIC PATROL (ETP) BUILDING ENGINEER PRIOR TO PERFORMING ANY WORK. CONTRACTOR SHALL COORDINATE THE CONDUIT AND CABLE ROUTING WITHIN THE ETP BUILDING.
- CONTRACTOR SHALL INSTALL NEW COMMUNICATION EQUIPMENT IN WALL MOUNTED EQUIPMENT RACK. SEE SHEET COMM-109 FOR EQUIPMENT ELEVATION DETAILS.
- WHEN POSSIBLE, CONTRACTOR SHALL CONCEAL CABLE AND CONDUIT INSTALLATION IN CEILING SPACE.
- APPROXIMATELY 62' FROM BREAK ROOM DOOR TO CONFERENCE ROOM DOOR

CABLE/CONDUIT IDENTIFIERS

- ① (2) #12 AND (1) #12 GND, 3/4" EMT
- ② 24-FIBER OPTIC CABLE, 2" EMT
- ③ SPARE, 2" EMT
- ④ COAX CABLE
- ⑤ UTP CAT-5 CABLE

REVISIONS	
NAME	DATE

ILLINOIS DEPARTMENT OF TRANSPORTATION
F.A.I. 94/90 (DAN RYAN EXPRESSWAY)
31st STREET to I-57
EMERGENCY TRAFFIC PATROL (ETP)
SITE PLAN
SCALE: NOT TO SCALE
DATE: October 29, 2004
DRAWN BY: DHI
CHECKED BY: JEZ

Edwards AND Kelcey
ONE NORTH FRANKLIN
CHICAGO, IL 60606
PHONE: (312) 251-3000
FAX: (312) 251-3015
WEB: WWW.EKCORP.COM

11/23/2004 02:40:32 PM