


SECTION	COUNTY	TOTAL SHEETS	SHEET NO.
2003-0311	COOK	976	874
STA. TO STA.		FED. ROAD DIST. NO. ILLINOIS FED. AID PROJECT	
		62583	

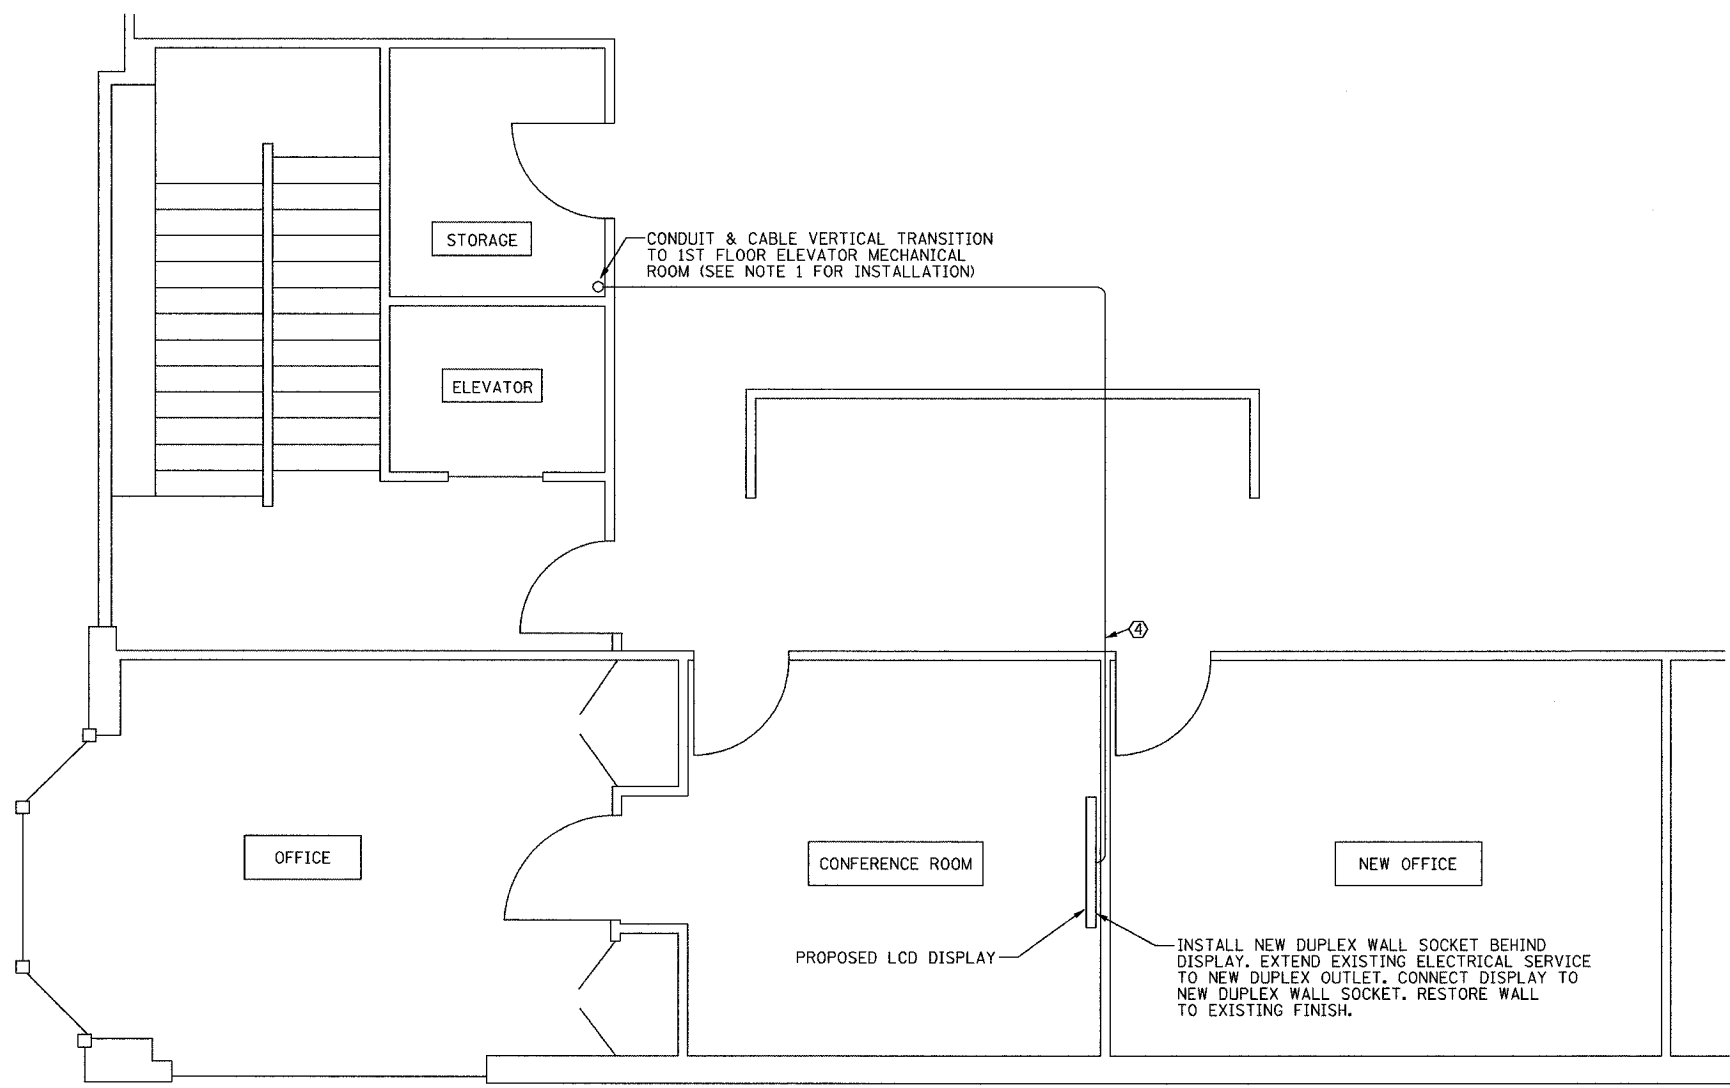

PARTIAL SECOND FLOOR PLAN



- NOTES:**
- CONTRACTOR SHALL COORDINATE WITH EMERGENCY TRAFFIC PATROL (ETP) BUILDING ENGINEER PRIOR TO PERFORMING ANY WORK. CONTRACTOR SHALL COORDINATE THE CONDUIT AND CABLE ROUTING WITHIN THE ETP BUILDING.
 - WHEN POSSIBLE, CONTRACTOR SHALL CONCEAL CABLE AND CONDUIT INSTALLATION IN CEILING SPACE.

- CABLE/CONDUIT IDENTIFIERS**
- ① (2) #12 AND (1) #12 GND, 3/4" C
 - ② 24-FIBER OPTIC CABLE, 2" C
 - ③ SPARE, 2" C
 - ④ RG-6 COAX CABLE, 3/4" C

REVISIONS	
NAME	DATE

ILLINOIS DEPARTMENT OF TRANSPORTATION
 F.A.I. 94/90 (DAN RYAN EXPRESSWAY)
 31st STREET to I-57
 EMERGENCY TRAFFIC PATROL (ETP)
 SITE PLAN
 SCALE: NOT TO SCALE
 DATE: October 29, 2004
 DRAWN BY: DHI
 CHECKED BY: JEZ

Edwards AND Kelcey
 ONE NORTH FRANKLIN
 CHICAGO, IL 60606
 PHONE: (312) 251-3000
 FAX: (312) 251-3015
 WEB: WWW.EKCORP.COM

11/23/2004 02:40:47 PM