


| | | | | |
|---------------------------|-----------|---------------------------|--------------|-----------|
| F.A.I. RTE. | SECTION | COUNTY | TOTAL SHEETS | SHEET NO. |
| 94/90 | 2003-0311 | COOK | 976 | 294 |
| STA. | | TO STA. | | |
| FED. ROAD DIST. NO. 62583 | | ILLINOIS FED. AID PROJECT | | |

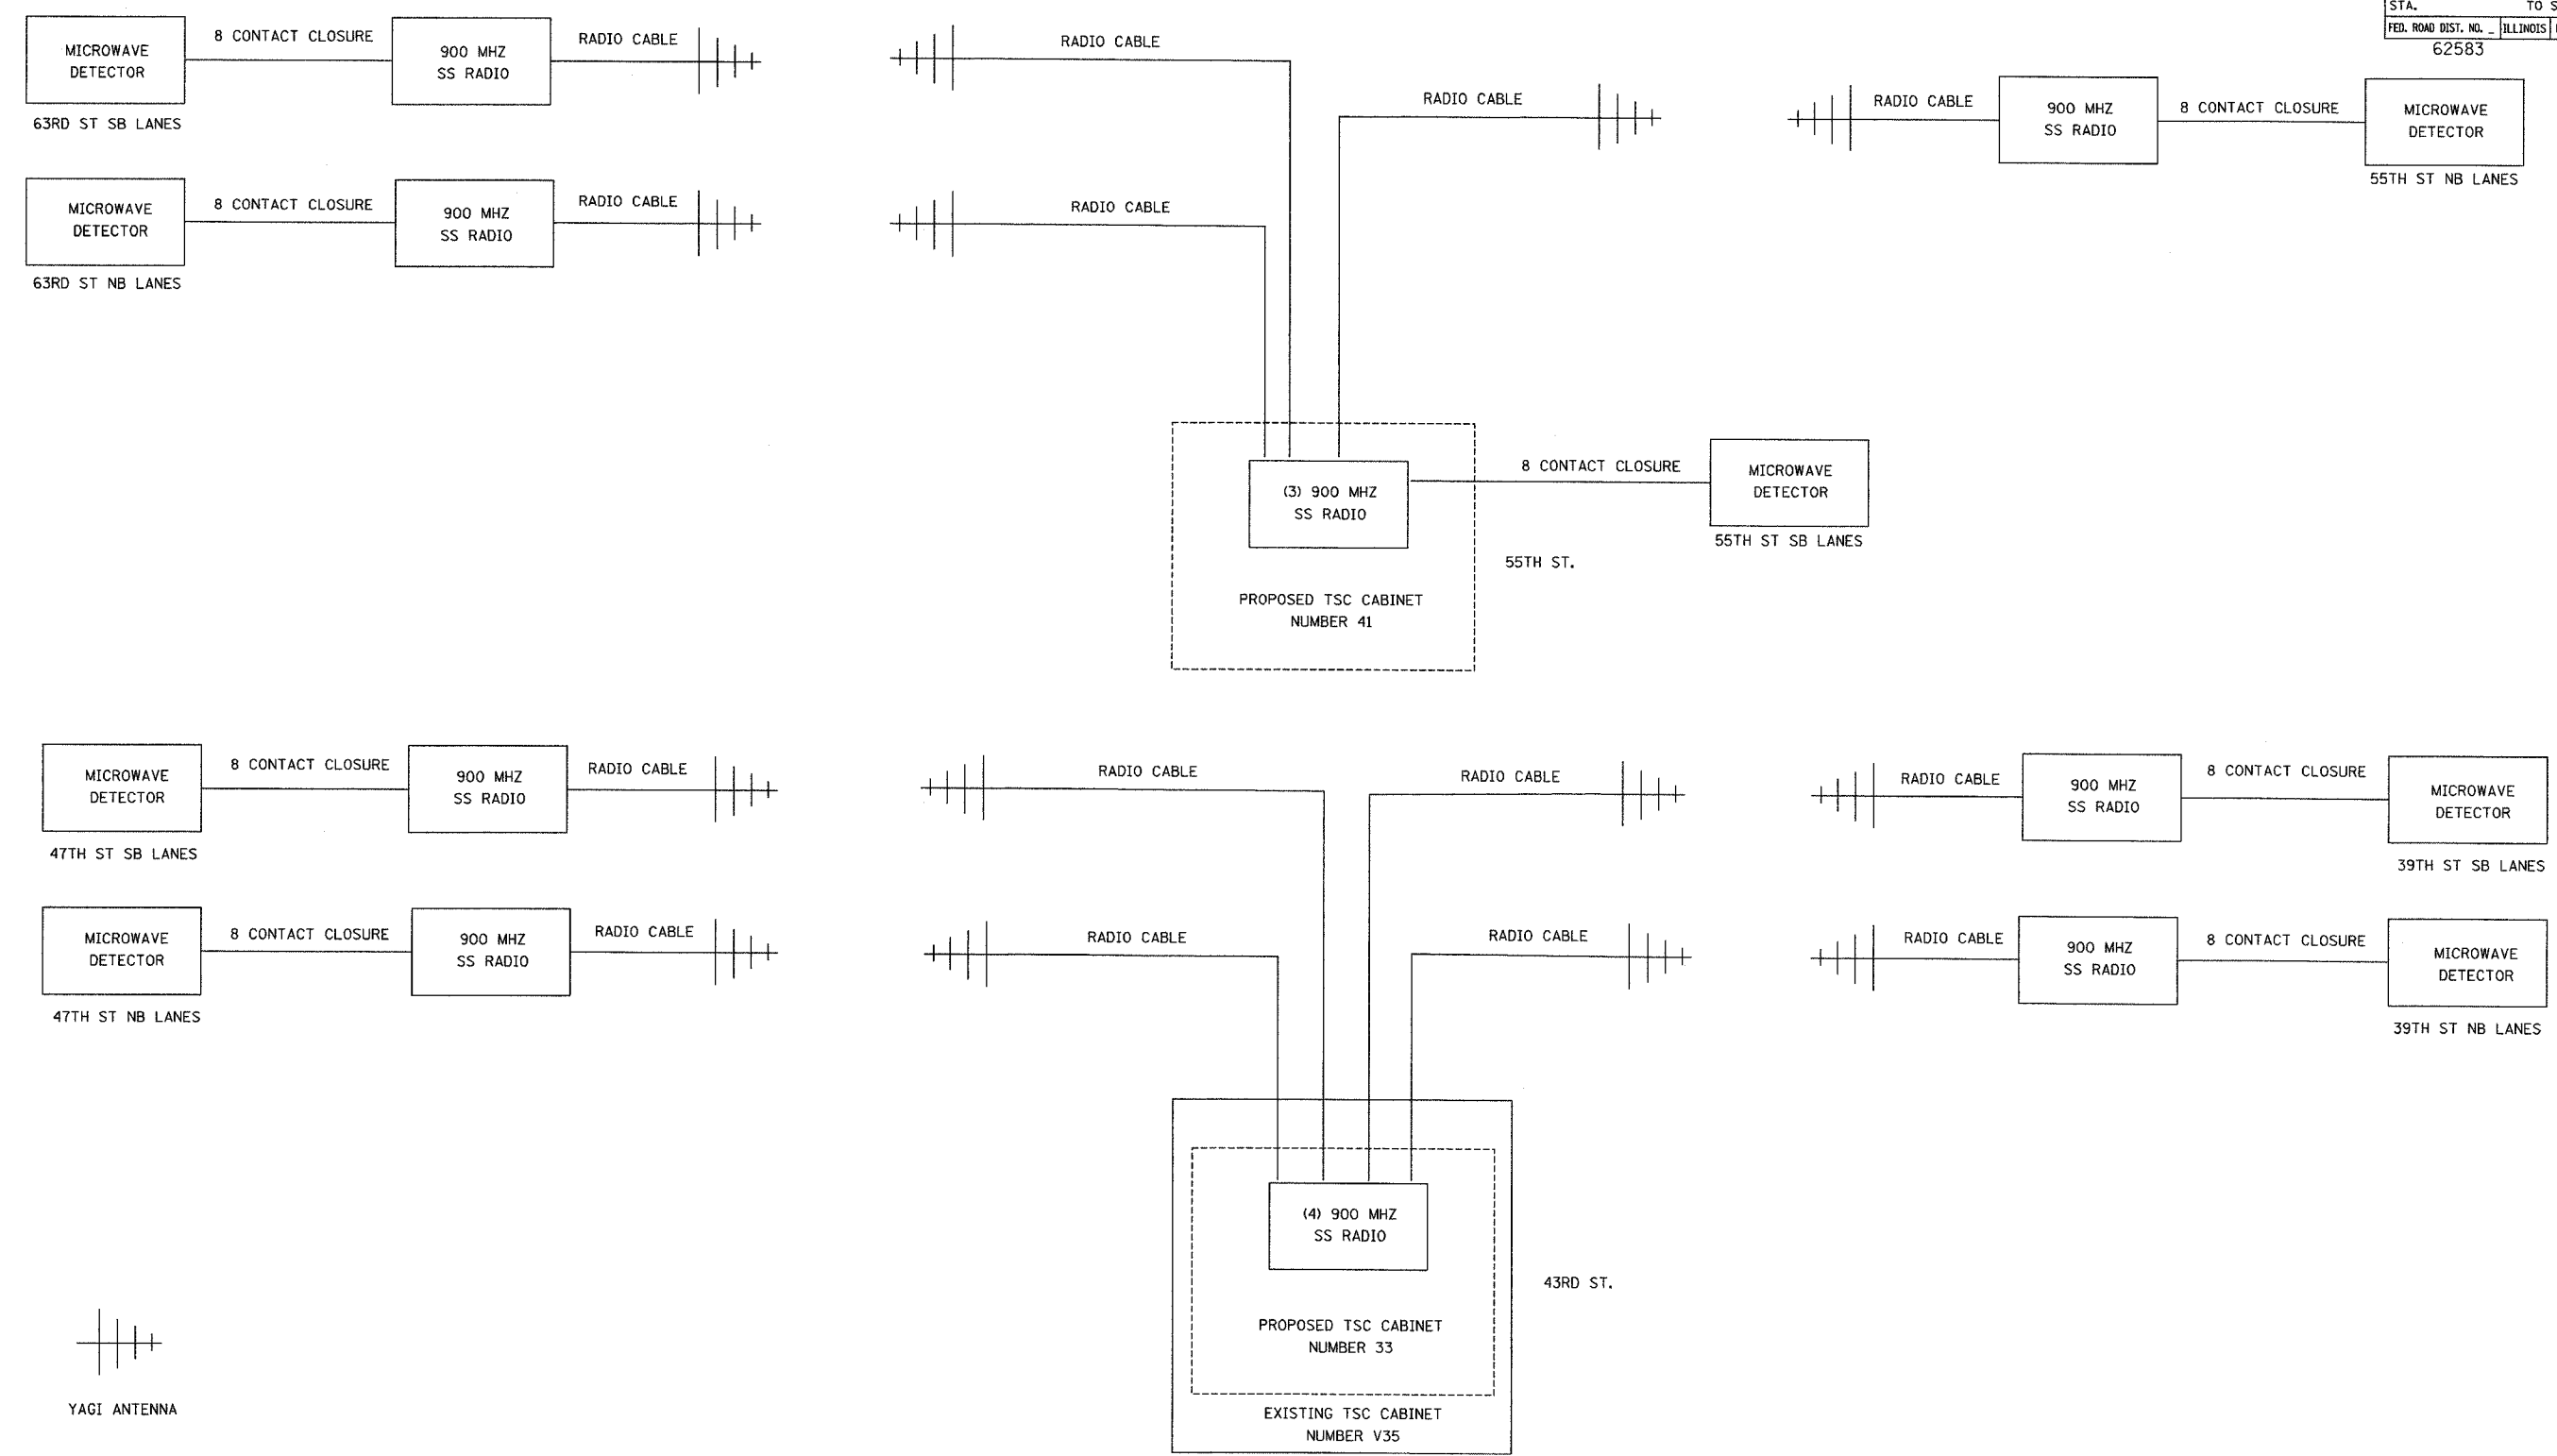

YAGI ANTENNA

NOTE:
 1. SEE SHEETS DT-53, DT-54, DT-55 FOR SITE INSTALLATION DETAILS.
 2. EXISTING TSC CABINETS TO BE UTILIZED UNTIL REMOVAL.

| REVISIONS | |
|-----------|------|
| NAME | DATE |
| | |
| | |
ILLINOIS DEPARTMENT OF TRANSPORTATION
 F.A.I. 94/90 (DAN RYAN EXPRESSWAY)
 31st STREET to I-57
 TEMPORARY DETECTION
 COMMUNICATIONS LAYOUT
 (Sheet 2 of 3)
 SCALE: N.T.S. DRAWN BY: DHI
 DATE: October 29, 2004 CHECKED BY: JEZ

Edwards AND Kelcey
 ONE NORTH FRANKLIN
 CHICAGO, IL 60606
 PHONE: (312) 251-3000
 FAX: (312) 251-3015
 WEB: WWW.EDKORP.COM

COMM-128

P:\030019035\116\road\01020362.dwg 10/19/2004 01:49:40 PM