



F.A.I. RTE.	SECTION	COUNTY	TOTAL SHEETS	SHEET NO.
90/94	2004-075RS	COOK	65	32
STA. 133+00		TO STA. 138+00		
FED. ROAD DIST. NO. 1		ILLINOIS		FED. AID PROJECT

62814

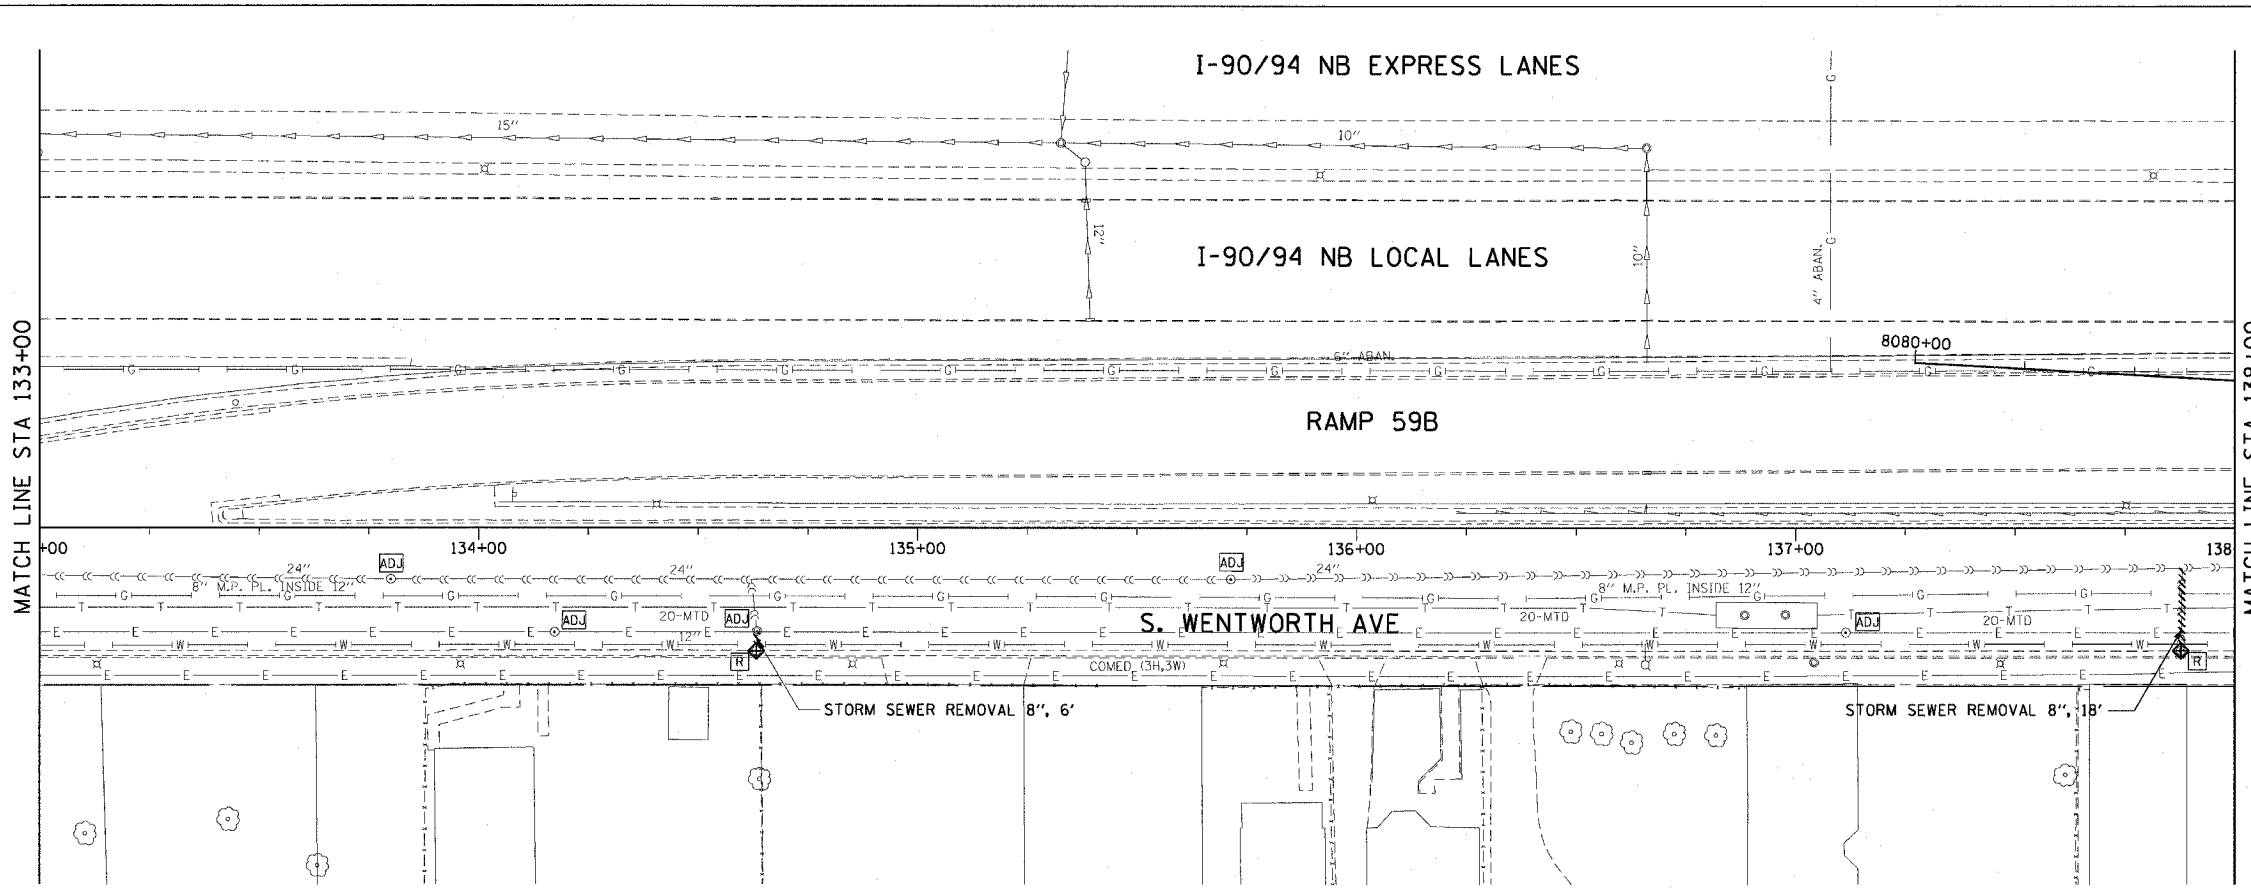

- LEGEND: EXISTING**
- INLET
 - CATCH BASIN
 - MANHOLE
 - STORM SEWER
 - COMBINED SEWER
 - PIPE UNDERDRAIN
 - [R] STRUCTURE TO BE REMOVED
 - [ADJ] STRUCTURE TO BE ADJUSTED
 - ||||| STORM SEWER REMOVAL
 - ||||| COMBINED SEWER REMOVAL

NOTE:
ALL EXISTING OPEN LID DRAINAGE STRUCTURES TO REMAIN THRU STAGE 1 SHALL HAVE INLET FILTERS INSTALLED.

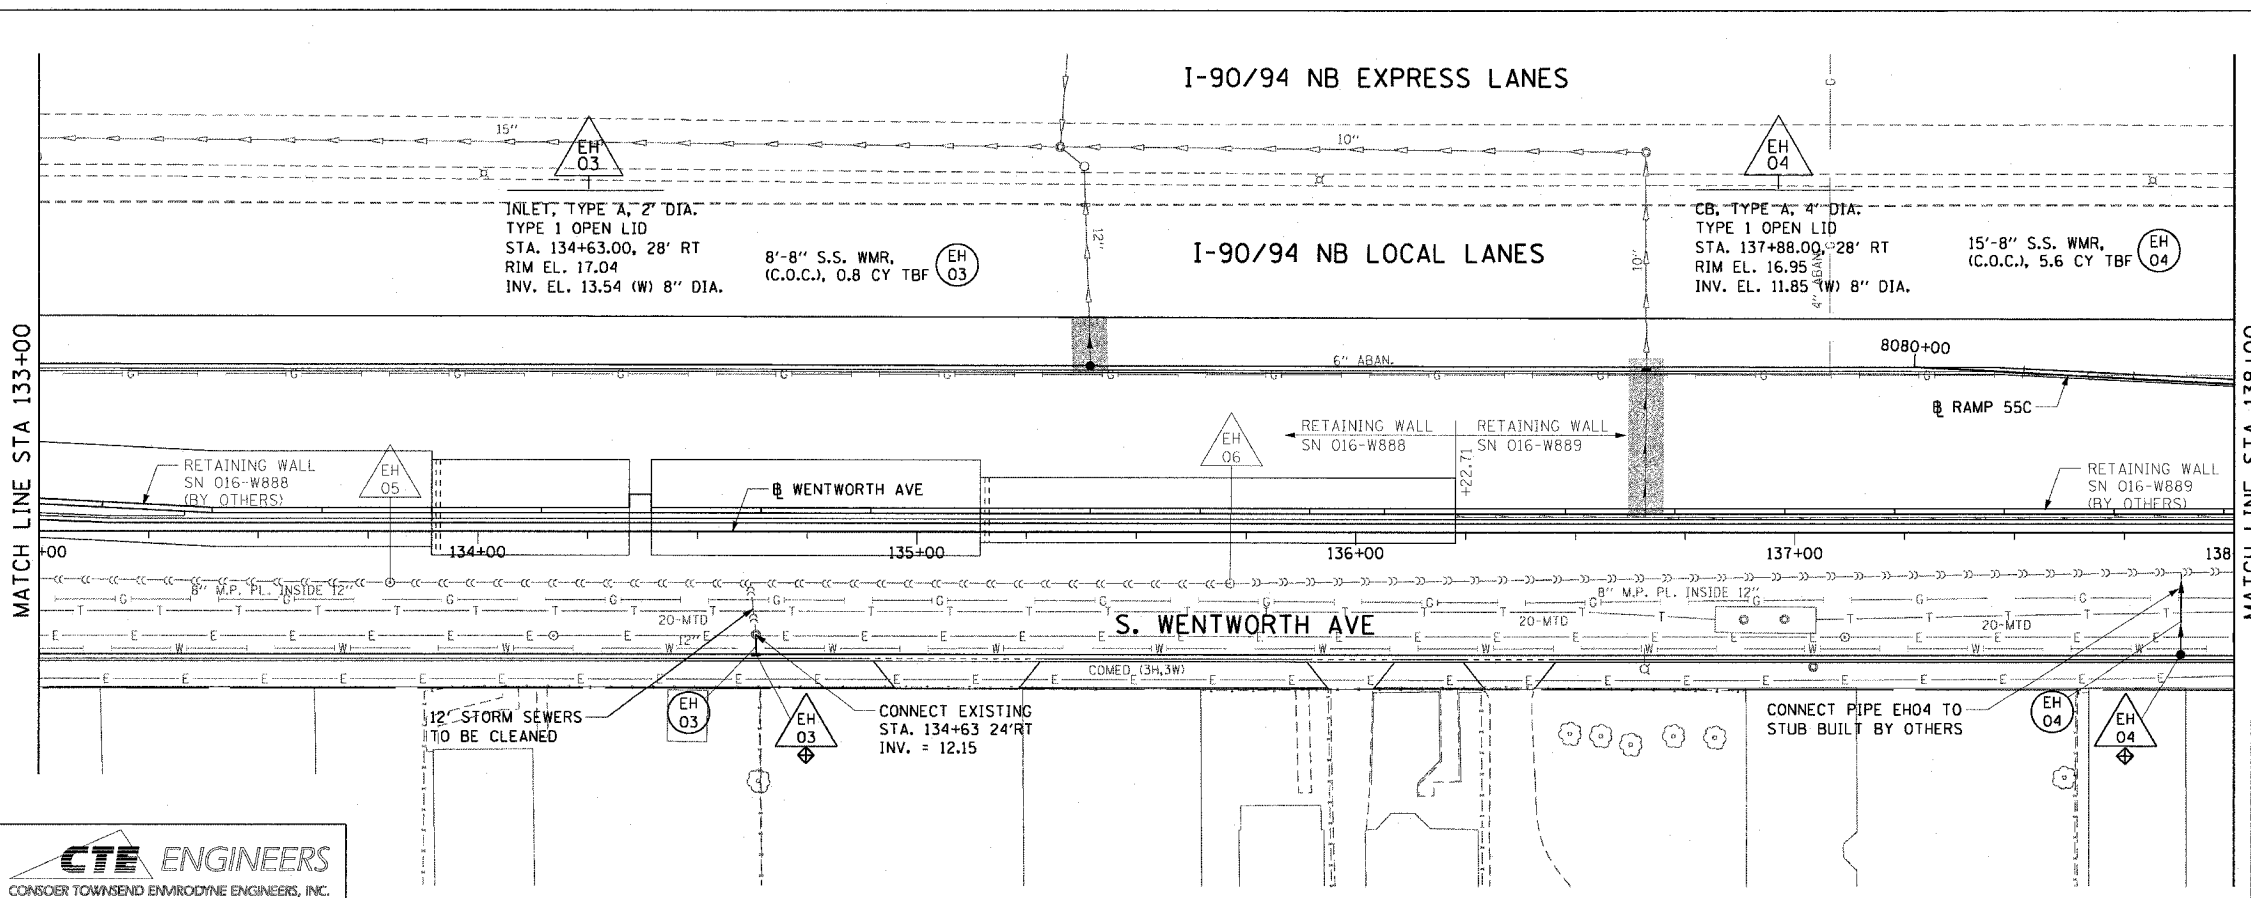

- EXISTING CONDITIONS AND REMOVAL**
- PROPOSED IMPROVEMENTS**
- LEGEND: PROPOSED**
- INLET
 - CATCH BASIN
 - MANHOLE
 - STORM SEWER
 - COMBINED SEWER
 - PIPE UNDERDRAIN
 - PROPOSED SWALE
 - (EA 01) PROPOSED STORM SEWER PIPE
 - (EA 01) PROPOSED STRUCTURE
 - WORK TO BE DONE BY OTHERS

NOTES:

- SEE DRAINAGE SCHEDULES FOR STRUCTURE AND PIPE INFORMATION.
- INLET FILTERS TO BE INSTALLED ON ALL PROPOSED DRAINAGE STRUCTURES.

REVISIONS	
NAME	DATE

ILLINOIS DEPARTMENT OF TRANSPORTATION
F.A.I. 90/94 (DAN RYAN EXPRESSWAY)
59th ST TO 57th ST (WENTWORTH AVENUE)

**DRAINAGE AND UTILITY PLANS
WENTWORTH AVENUE**

SCALE: 1"=20'
DATE: OCTOBER 29, 2004

DRAWN BY: JB
CHECKED BY: EBY

CTE ENGINEERS
CONSOER TOWNSEND ENVIRODYNE ENGINEERS, INC.
303 EAST WACKER DRIVE, SUITE 600
CHICAGO ILLINOIS 60601-5262, PHONE: (312) 938-0300

11/23/2004 08:34:44 AM