



| | | | | |
|-----------------------|------------|----------|------------------|-----------|
| F.A.I. RTE. | SECTION | COUNTY | TOTAL SHEETS | SHEET NO. |
| 90/94 | 2004-099TS | COOK | 65 | 29 |
| STA. | TO STA. | | | |
| FED. ROAD DIST. NO. 1 | | ILLINOIS | FED. AID PROJECT | |
| 62840 | | | | |

NOTES:


1. SEE DRAWINGS E-1 AND E-2 FOR CDOT ELECTRICAL GENERAL NOTES, SYMBOLS, AND ABBREVIATIONS.
2. NOT USED.
3. NOT USED.
4. NOT USED.
5. NOT USED.
6. NOT USED.

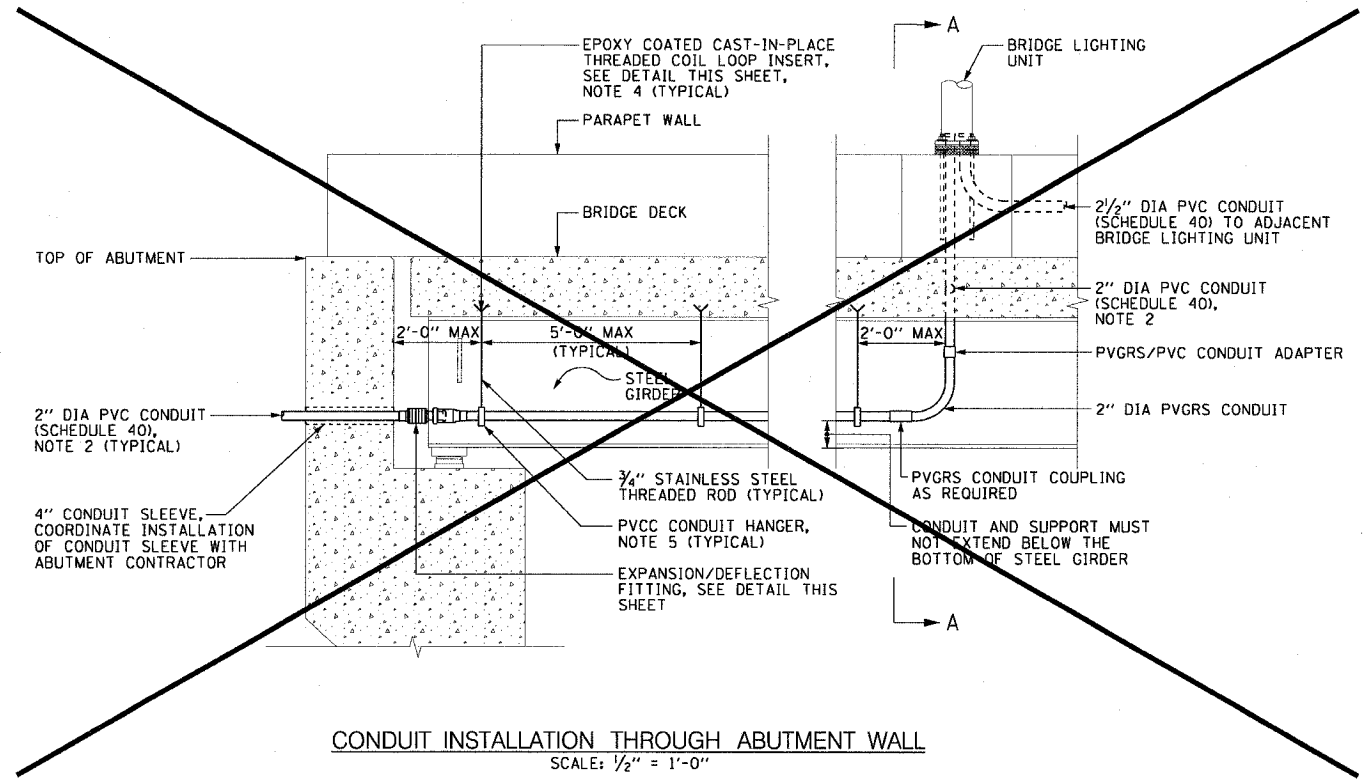


CONDUIT INSTALLATION THROUGH ABUTMENT WALL
SCALE: 1/2" = 1'-0"

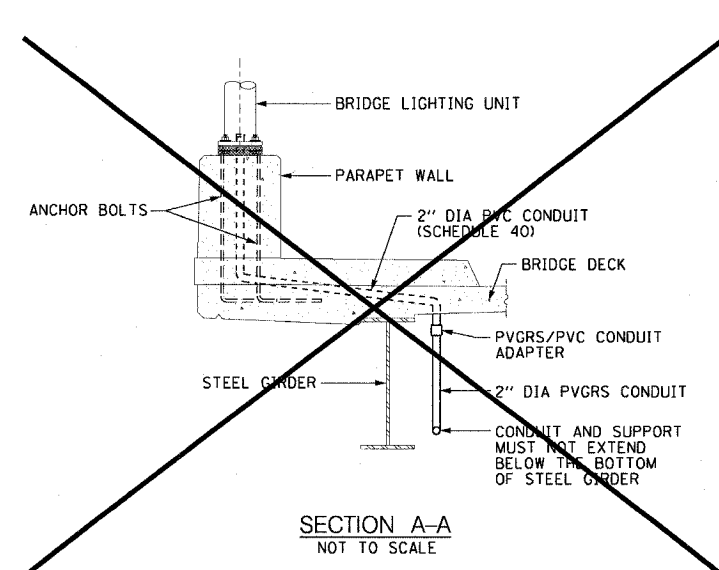


SECTION A-A
NOT TO SCALE

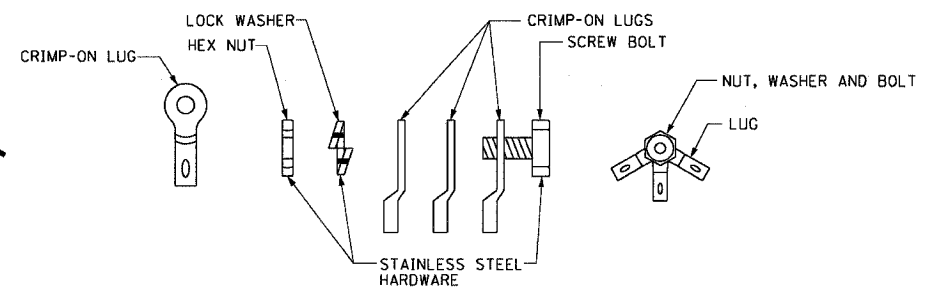


JOINT ASSEMBLY DETAILS
NOT TO SCALE

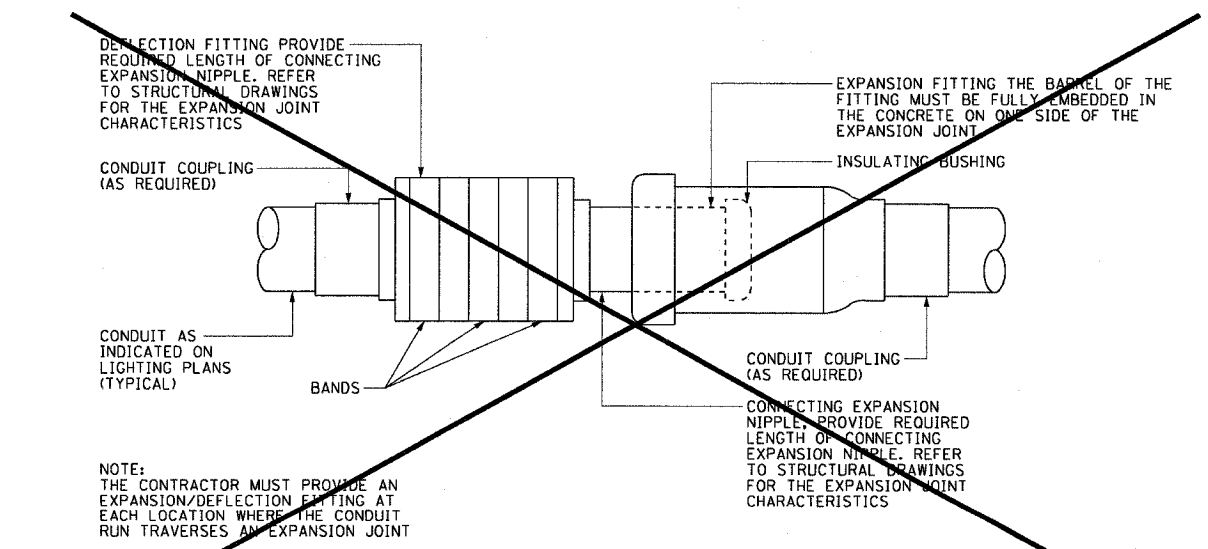

CONDUIT EXPANSION / DEFLECTION COUPLING DETAIL
EXPANSION/DEFLECTION FITTING, 0-2/GEDNEY AX/DX OR APPROVED EQUAL
NOT TO SCALE

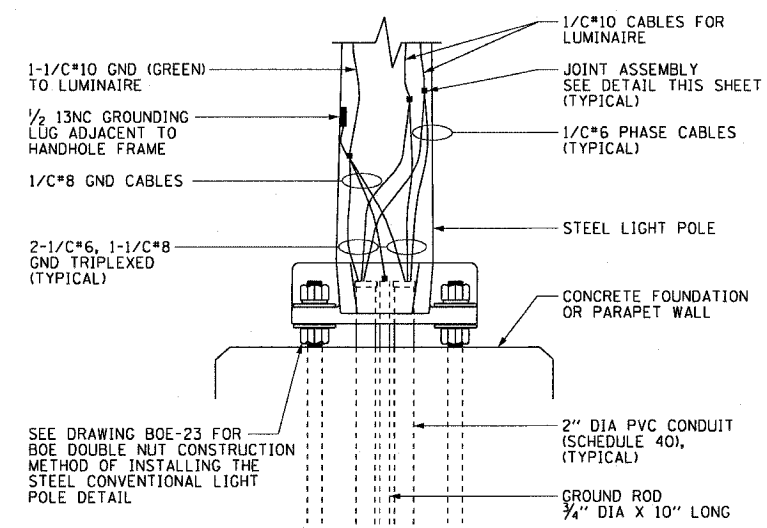

CDOT CONVENTIONAL POLE BASE WIRING DETAIL
NOT TO SCALE

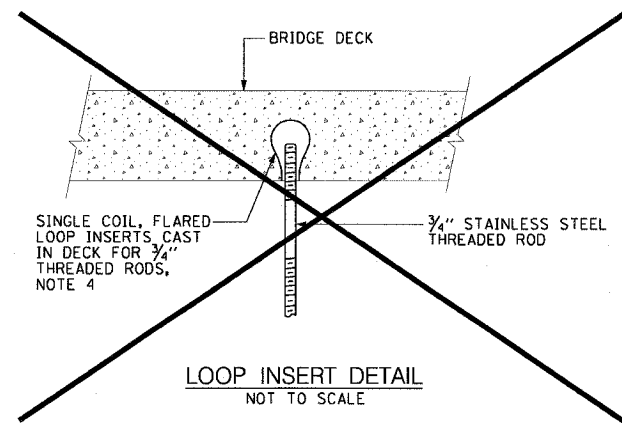

LOOP INSERT DETAIL
NOT TO SCALE



| REVISIONS | |
|-----------|------|
| NAME | DATE |
| | |
| | |
ILLINOIS DEPARTMENT OF TRANSPORTATION
F.A.I. 90/94 (DAN RYAN EXPRESSWAY)
TRAFFIC SIGNALS AT 63RD STREET AND
WENTWORTH AVENUE/ WELLS STREET
MISCELLANEOUS ELECTRICAL DETAILS

SCALE: AS SHOWN DRAWN BY: HAR
DATE: November 05, 2004 CHECKED BY: WDS

11/04/2004 09:01:31 AM