



MATCHLINE NB STA. 2207+00.00

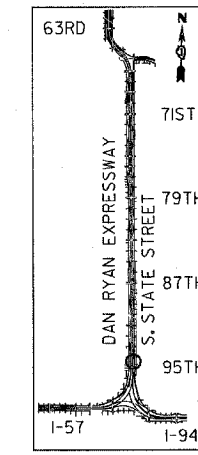

LOCATION MAP

- ① WM. BID ITEM NO. 1b
SET: 1-24" x 1/8 2BMJ BEND
AT STA. 2211+03.00, 155.00' RIGHT
TEMPORARILY PLUG THE S.W. END ON BEND WITH:
1-24" MJ PLUG
START LAYING PIPE TOWARDS NORTH.
 - ② WM. BID ITEM NO. 9
SET: 1" PITOMETER TAP AT STA. 2211+18.00, 155.00' RIGHT
 - ③ WM. BID ITEM NO. 2c
SET: 1-24" MJ BUTTERFLY VALVE AT STA. 2211+28.00, 155.00' RIGHT
 - ④ WM. BID ITEM NO. 9
SET: 1" PITOMETER TAP AT STA. 2211+38.00, 155.00' RIGHT
 - ⑬ WM. BID ITEM NO. 3c, 4a, 4b, 7c
CUT, CAP AND BRACE THE EXISTING 24" WATER MAIN TO THE NORTH WITH:
1-24" MJ CAP
BUILD THRUST RESTRAINT STRUCTURE TYPE A, AS PER DETAIL FOR CAP.
REMOVE TEMPORARY PLUG OF NOTE 1 AND THE EXISTING BEND AND
CONNECT THE EXISTING 24" WATER MAIN TO THE NEW 24" PIPE
WITH: 1-24" TRANSITION SLEEVE
1-24" x 1/8 2BMJ BEND AT STA. 2210+23.08, 122.00 RIGHT
BUILD THRUST RESTRAINT STRUCTURE TYPE B, AS PER DETAIL FOR BEND.
FLUSH, PRESSURE TEST AND CHLORINATE THE NEW WATER MAIN.
- FOR NOTE 5 SEE SHEET NO. C-4
 FOR NOTES 6 TO 9 SEE SHEET NO. C-5
 FOR NOTES 10 TO 12 SEE SHEET NO. C-6
 FOR NOTE 14 SEE SHEET NO. C-5

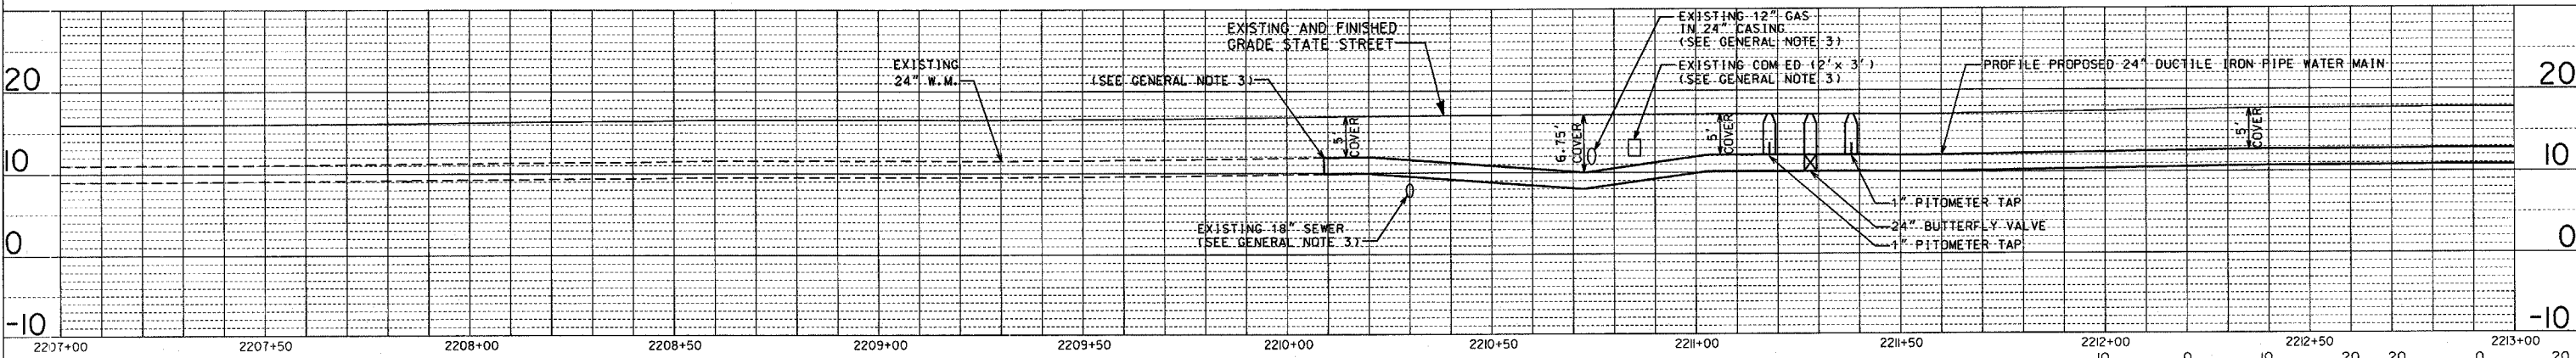

VERTICAL SCALE: 1" = 10'-0"
 HORIZONTAL SCALE: 1" = 20'-0"

REVISIONS	
NAME	DATE

ILLINOIS DEPARTMENT OF TRANSPORTATION
 F.A.I. 94 (DAN RYAN EXPRESSWAY)
 PLAN AND PROFILE
 24-INCH WATER MAIN RELOCATION
 S. STATE STREET
 NB I-94, STA. 2207+00 TO 2213+00

SCALE: 1"=20'
 DATE: SEPTEMBER 3, 2004

DRAWN BY:
 CHECKED BY:

BASE DRAWING SHOWING EXISTING
 CONDITIONS AND UTILITIES IS PREPARED BY:
TYLIN INTERNATIONAL