
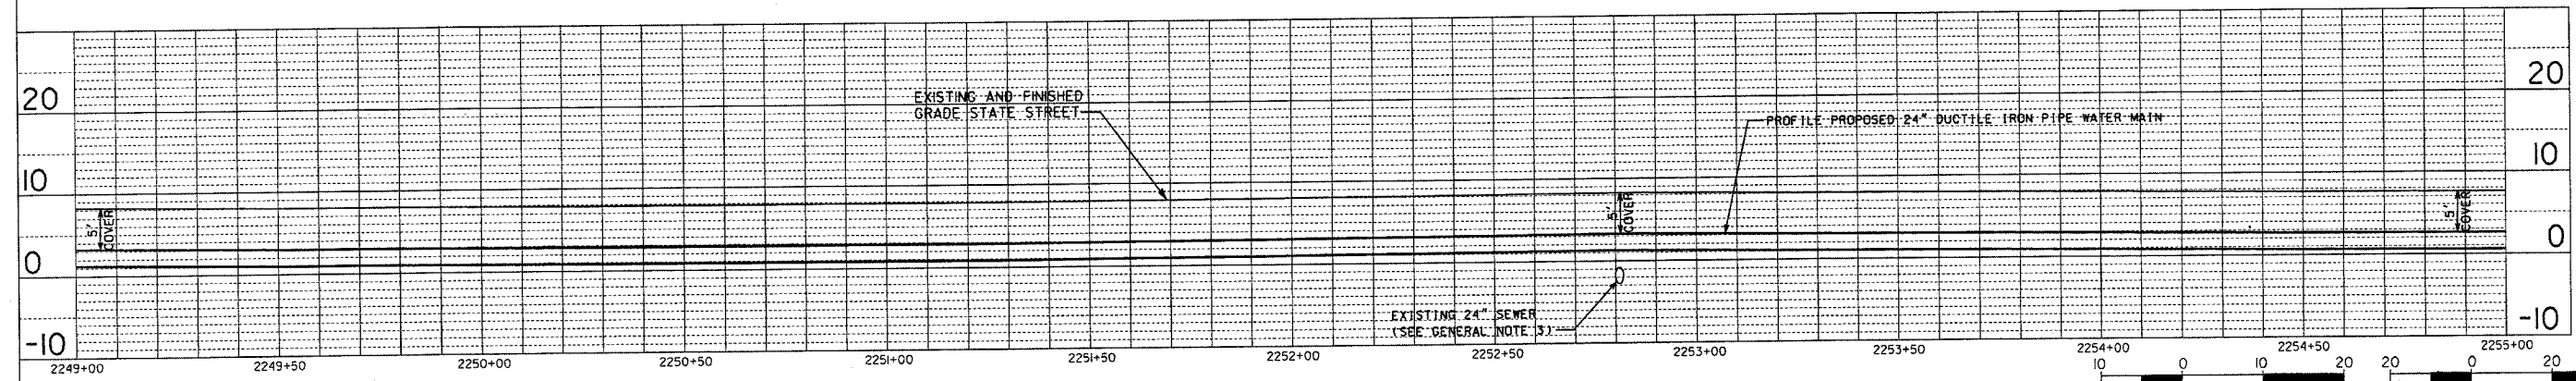
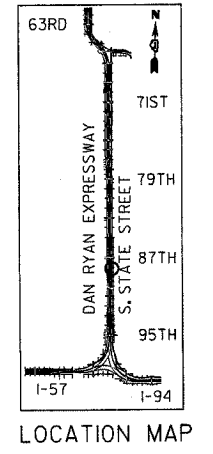


F.A.I. RTE.	SECTION	COUNTY	TOTAL SHEETS	SHEET NO.
94		COOK	115	133
STA. 2200+00.00 TO STA. 2362+00.00				
FED. ROAD DIST. NO.		ILLINOIS	FED. AID PROJECT.	
(0516,1,1717 & 1818) R-6		62872 (17D)		

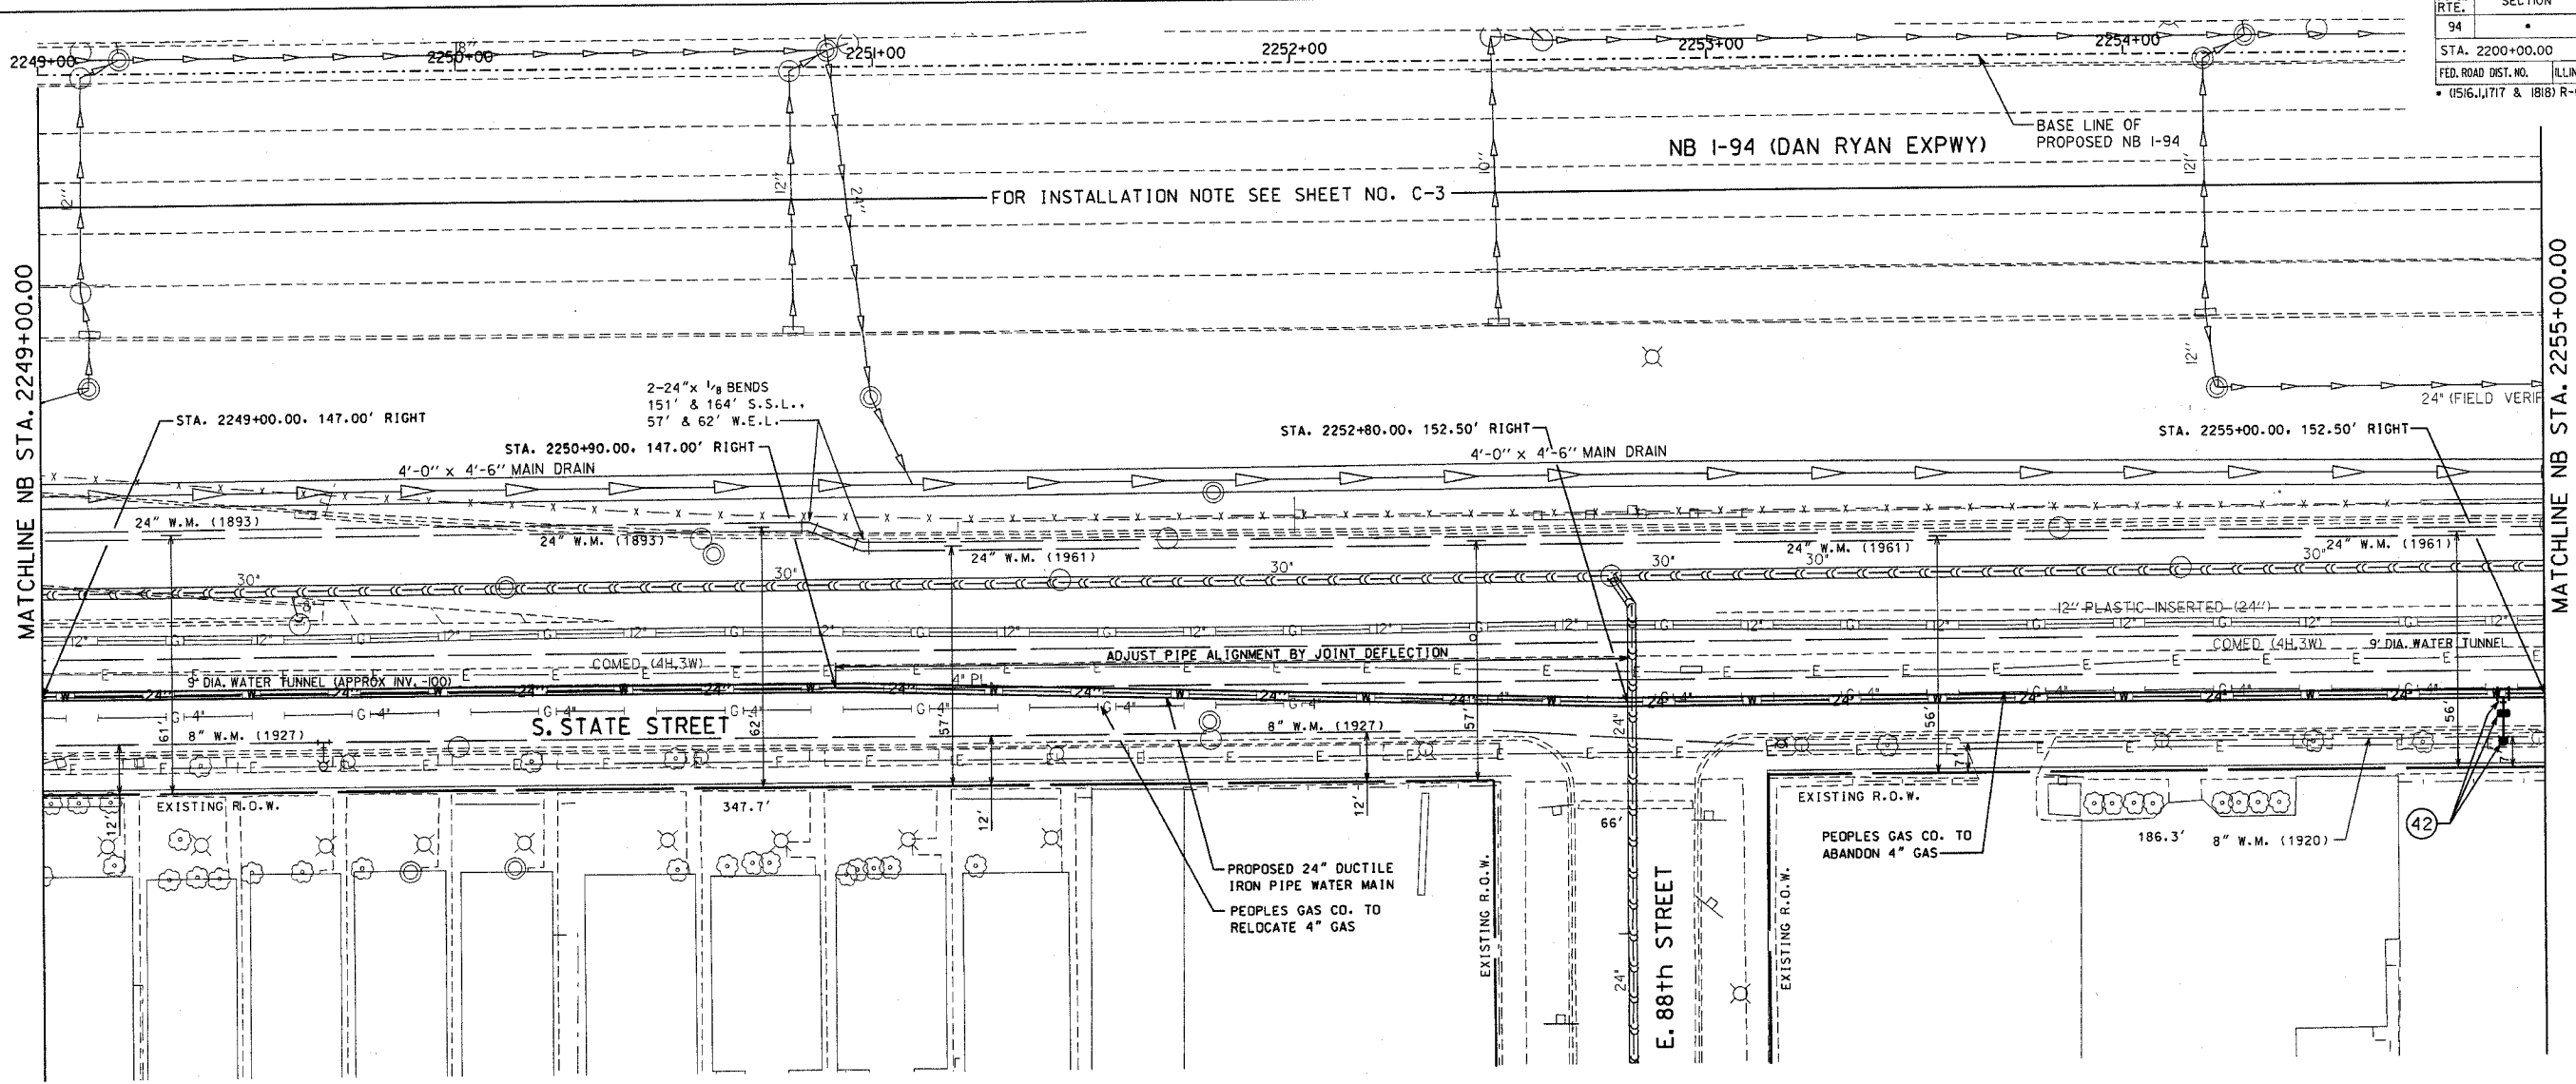

DATE	BY
DATE	BY

DATE	BY
DATE	BY

BASE DRAWING SHOWING EXISTING CONDITIONS AND UTILITIES IS PREPARED BY:  
**TYLIN INTERNATIONAL**

42  
WM. BID ITEM NO. 2a, 5  
SET: 1-4 1/2" MJ FIRE HYDRANT AT STA. 2254+90.00 AND  
2' BEHIND THE EXISTING CURB  
1-24" x 8" 3BMJ TEE AT STA. 2254+90.00, 152.50' RIGHT  
1-8" MJ VALVE AT STA. 2254+90.00, 157.00' RIGHT  
FLANGE COLOR CODE: BLUE

FOR NOTE 41 SEE SHEET NO. C-9

FOR NOTE 43 SEE SHEET NO. C-11

REVISIONS	
NAME	DATE

ILLINOIS DEPARTMENT OF TRANSPORTATION  
F.A.I. 94 (DAN RYAN EXPRESSWAY)  
PLAN AND PROFILE  
24-INCH WATER MAIN RELOCATION  
S. STATE STREET  
NB I-94, STA. 2249+00 TO 2255+00  
SCALE: 1"=20'  
DATE: SEPTEMBER 3, 2004  
DRAWN BY:  
CHECKED BY:

C-10