

F.A.U. RTE.	SECTION	COUNTY	TOTAL SHEETS	SHEET NO.
2652	00-00069-00-PV	DUPAGE	146	1
STA. 10+70.70		TO STA. 66+16.00		
FED. ROAD DIST. NO.		ILLINOIS	FED. AID PROJECT	
CONTRACT NO. 83781				

**INDEX OF SHEETS:**

- 1 COVER SHEET
- 2 GENERAL NOTES, STANDARDS
- 3-7 SUMMARY OF QUANTITIES
- 8-9 TYPICAL SECTIONS
- 10-13 SCHEDULE OF QUANTITIES
- 14 ALIGNMENT, TIES, AND BENCHMARKS
- 15-24 PLAN AND PROFILE
- 25-34 SUGGESTED MAINTENANCE OF TRAFFIC
- 35-39 EROSION CONTROL PLANS
- 40-55 DRAINAGE AND UTILITIES
- 56-60 WATER MAIN PLAN AND PROFILE
- 61-68 RIGHT-OF-WAY PLATS
- 69-73 PAVEMENT MARKING PLANS
- 74-82 LIGHTING PLANS
- 83-89 MISCELLANEOUS DETAILS
- 90-146 CROSS SECTIONS

**STATE OF ILLINOIS  
DEPARTMENT OF TRANSPORTATION  
DIVISION OF HIGHWAYS**


**PROPOSED  
HIGHWAY PLANS**

**FAU RTE 2652 - SOUTH VILLA AVENUE  
(ROOSEVELT ROAD TO MADISON STREET)**

**SECTION: 00-00069-00-PV**

**PROJECT: CMM-M-8003 (C334)**

**JOB NUMBER: C 91-052-04 VILLAGE OF VILLA PARK  
DU PAGE COUNTY**

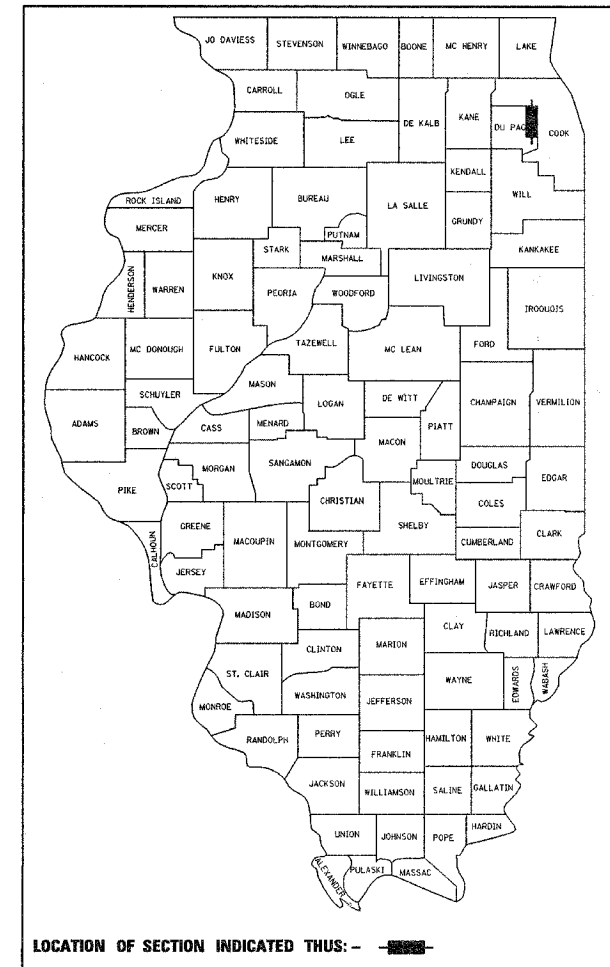

HIGHWAY STANDARDS: SHEET 2 OF 146

**TRAFFIC DATA:**

VILLA AVENUE:  
2,900-4,900 VEHICLES (2000)  
4,000-6,000 VEHICLES (2020)


**POSTED SPEED LIMIT:**

VILLA AVENUE:  
30 mph

**DESIGN DESIGNATION:**

600 (20) COLLECTOR 0.5 (FD-20)

THE WORK UNDER THIS CONTRACT SHALL CONSIST OF:  
STAGED RECONSTRUCTION AND WIDENING OF VILLA AVENUE  
INCLUDING ENCLOSED DRAINAGE, CURB AND GUTTER AND  
SIDEWALK.

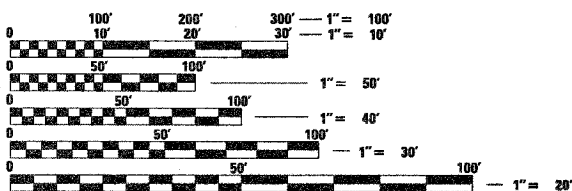


FULL SIZE PLANS HAVE BEEN PREPARED USING STANDARD  
ENGINEERING SCALES. REDUCED SIZED PLANS WILL NOT  
CONFORM TO STANDARD SCALES. IN MAKING MEASUREMENTS  
ON REDUCED PLANS, THE ABOVE SCALES MAY BE USED.

J.U.L.I.E.  
JOINT UTILITY LOCATION INFORMATION FOR EXCAVATION  
1-800-892-0123

**CONTRACT NO. 83781**



FEDERAL AID DESIGN ENGINEER: MAZHAR KHAN (847)705-4179

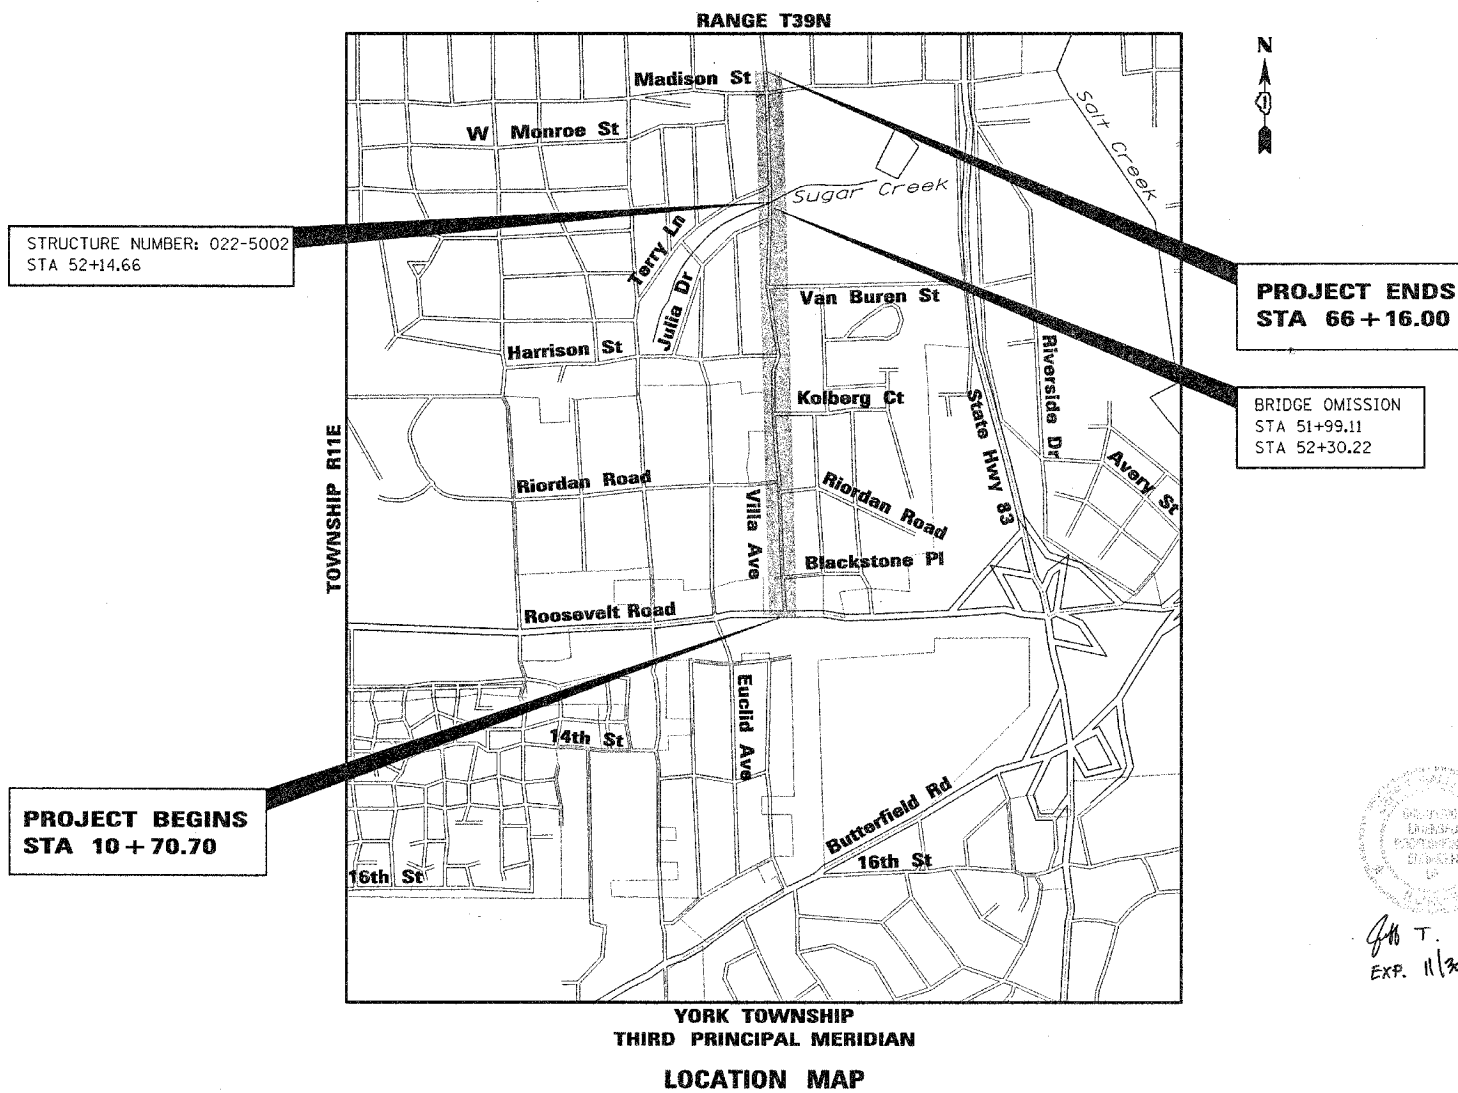

YORK TOWNSHIP  
THIRD PRINCIPAL MERIDIAN  
**LOCATION MAP**

MAP SCALE 0 0.5 MILE

GROSS LENGTH OF PROJECT: 5,545.3 FT (1.05 MILES)  
BRIDGE OMISSION: 31 FT (0.01 MILES)  
NET LENGTH OF PROJECT: 5,514.3 FT (1.04 MILES)

*John T. Callaghan*  
EXP. 11/30/05

STATE OF ILLINOIS  
DEPARTMENT OF TRANSPORTATION  
DIVISION OF HIGHWAYS

SUBMITTED 11-10 20 04

*Dydas Juskeles* DIRECTOR PUBLIC WORKS  
LOCAL AGENCY OFFICIAL

20

DISTRICT ENGINEER OF LOCAL ROADS AND STREETS

November 12, 20 04

*Dina O'Keefe* DISTRICT ENGINEER

**PRINTED BY THE AUTHORITY  
OF THE STATE OF ILLINOIS**