
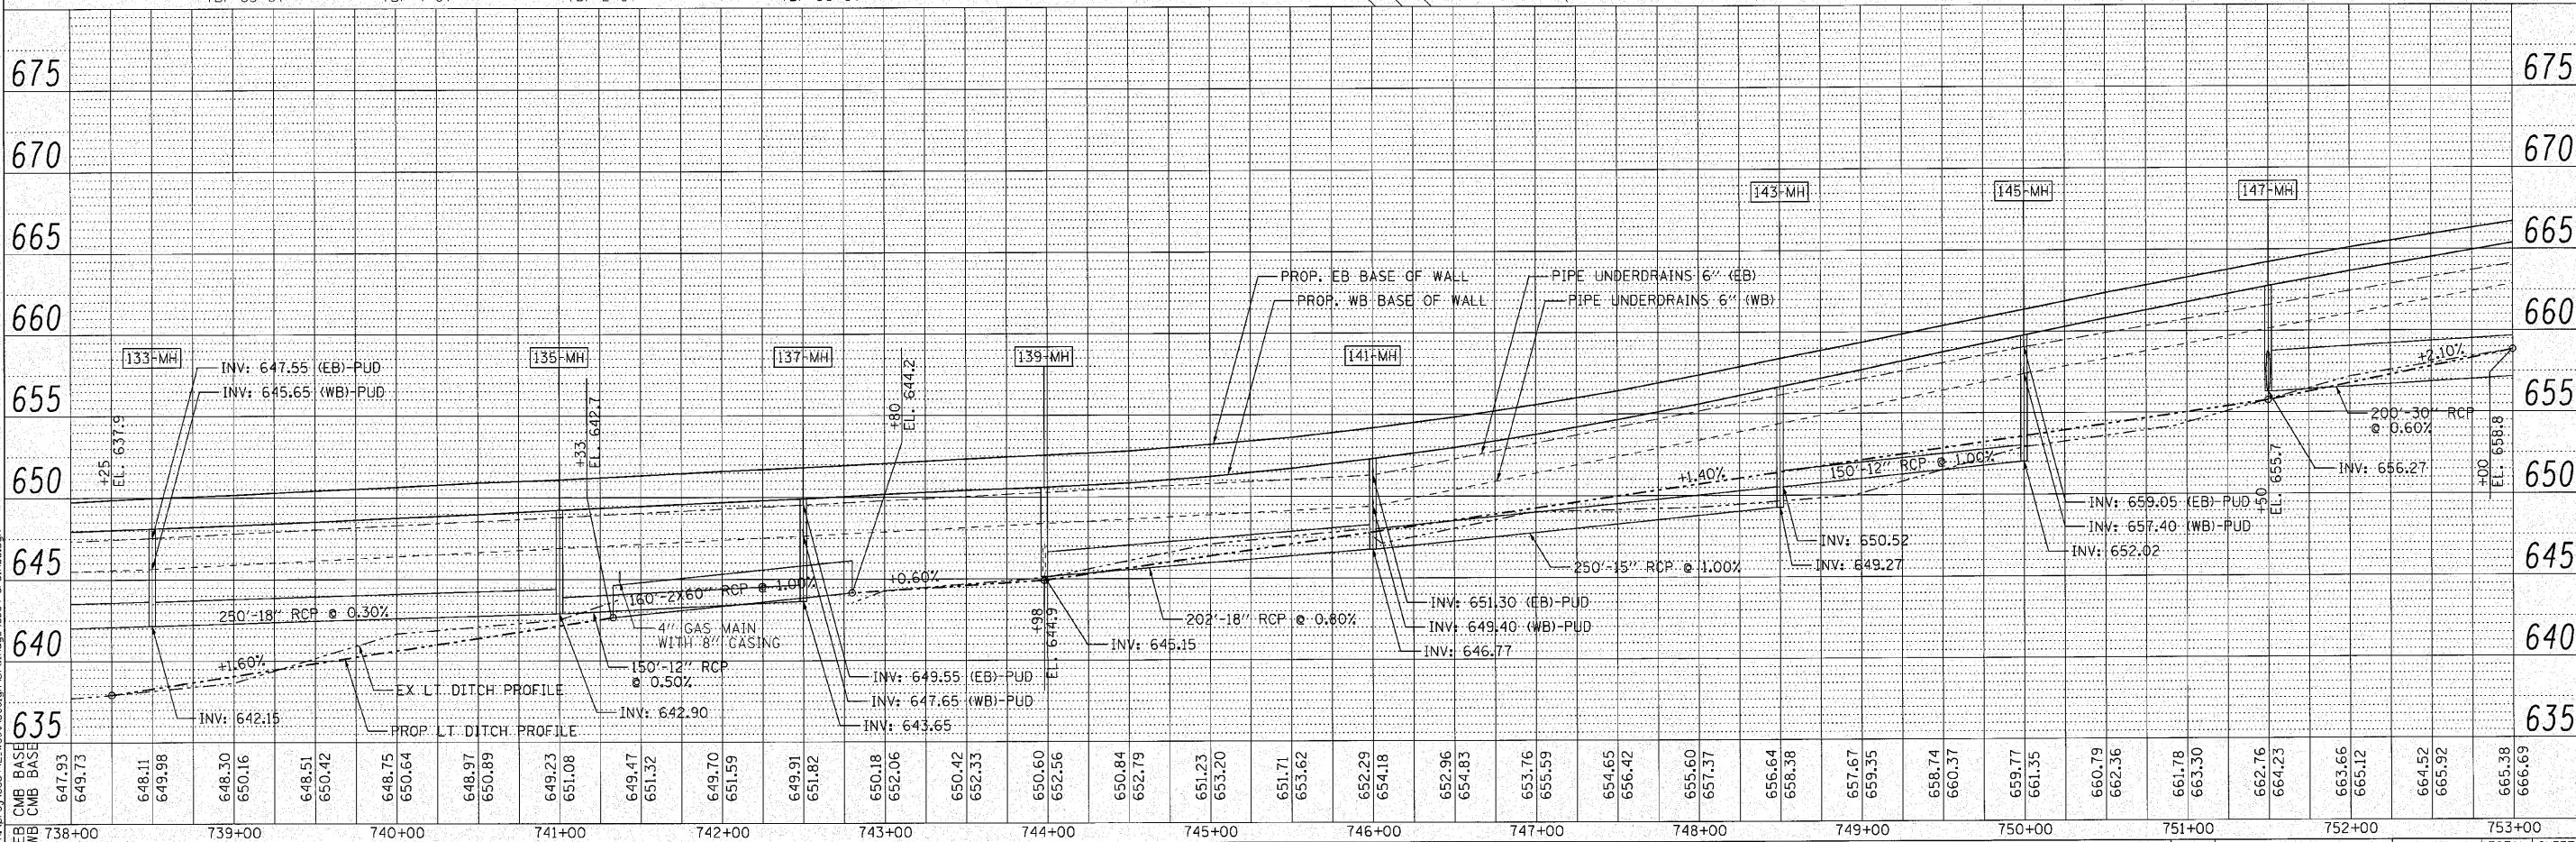


DATE	
BY	
REVISION	
NO.	
DESCRIPTION	

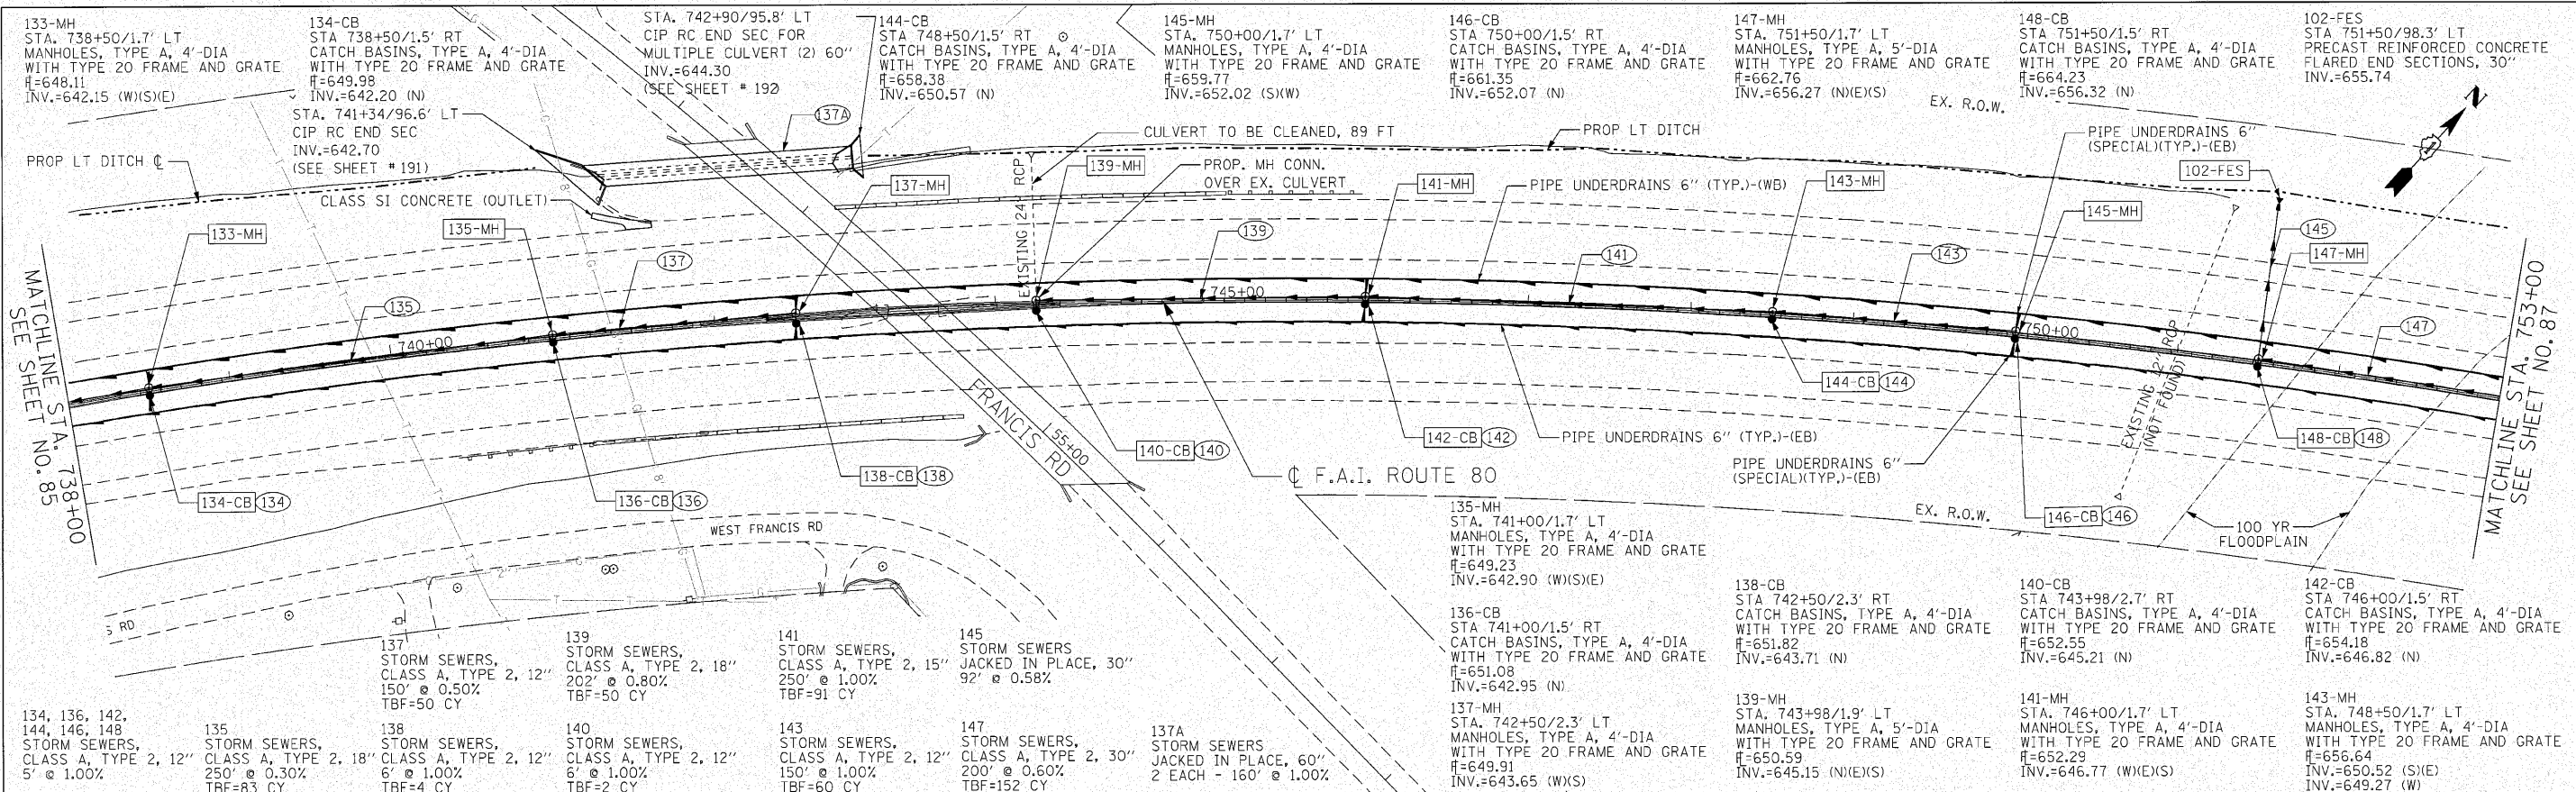

ENGINEERING CONSULTANT CG Corba Group, Inc. CONSULTING ENGINEERS 2507 North Lombard Avenue, Suite 402 Chicago, Illinois 60647 Tel. 773.772.4000 Fax 773.775.4014 Email: cgroup@corba.com	USER NAME = coornwell DESIGNED - CRC DRAWN - JMK CHECKED - MRJ DATE - 10/27/2010	REVISIONS REVISED - REVISED - REVISED - REVISED -	STATE OF ILLINOIS DEPARTMENT OF TRANSPORTATION	F.A.I. 80 FROM US 30 TO NS RAILROAD PROPOSED DRAINAGE PLAN AND PROFILE	F.A.I. 80 SECTION 99-5-Y COUNTY WILL SHEETS 276 SHEET NO. 86 CONTRACT NO. 60147
	PLOT SCALE = 50.0000" / IN. PLOT DATE = 10/27/2010	SCALE: 1" = 50' SHEET NO. 86 OF SHEETS STA. 738+00 TO STA. 753+00	ILLINOIS FED. AID PROJECT		