
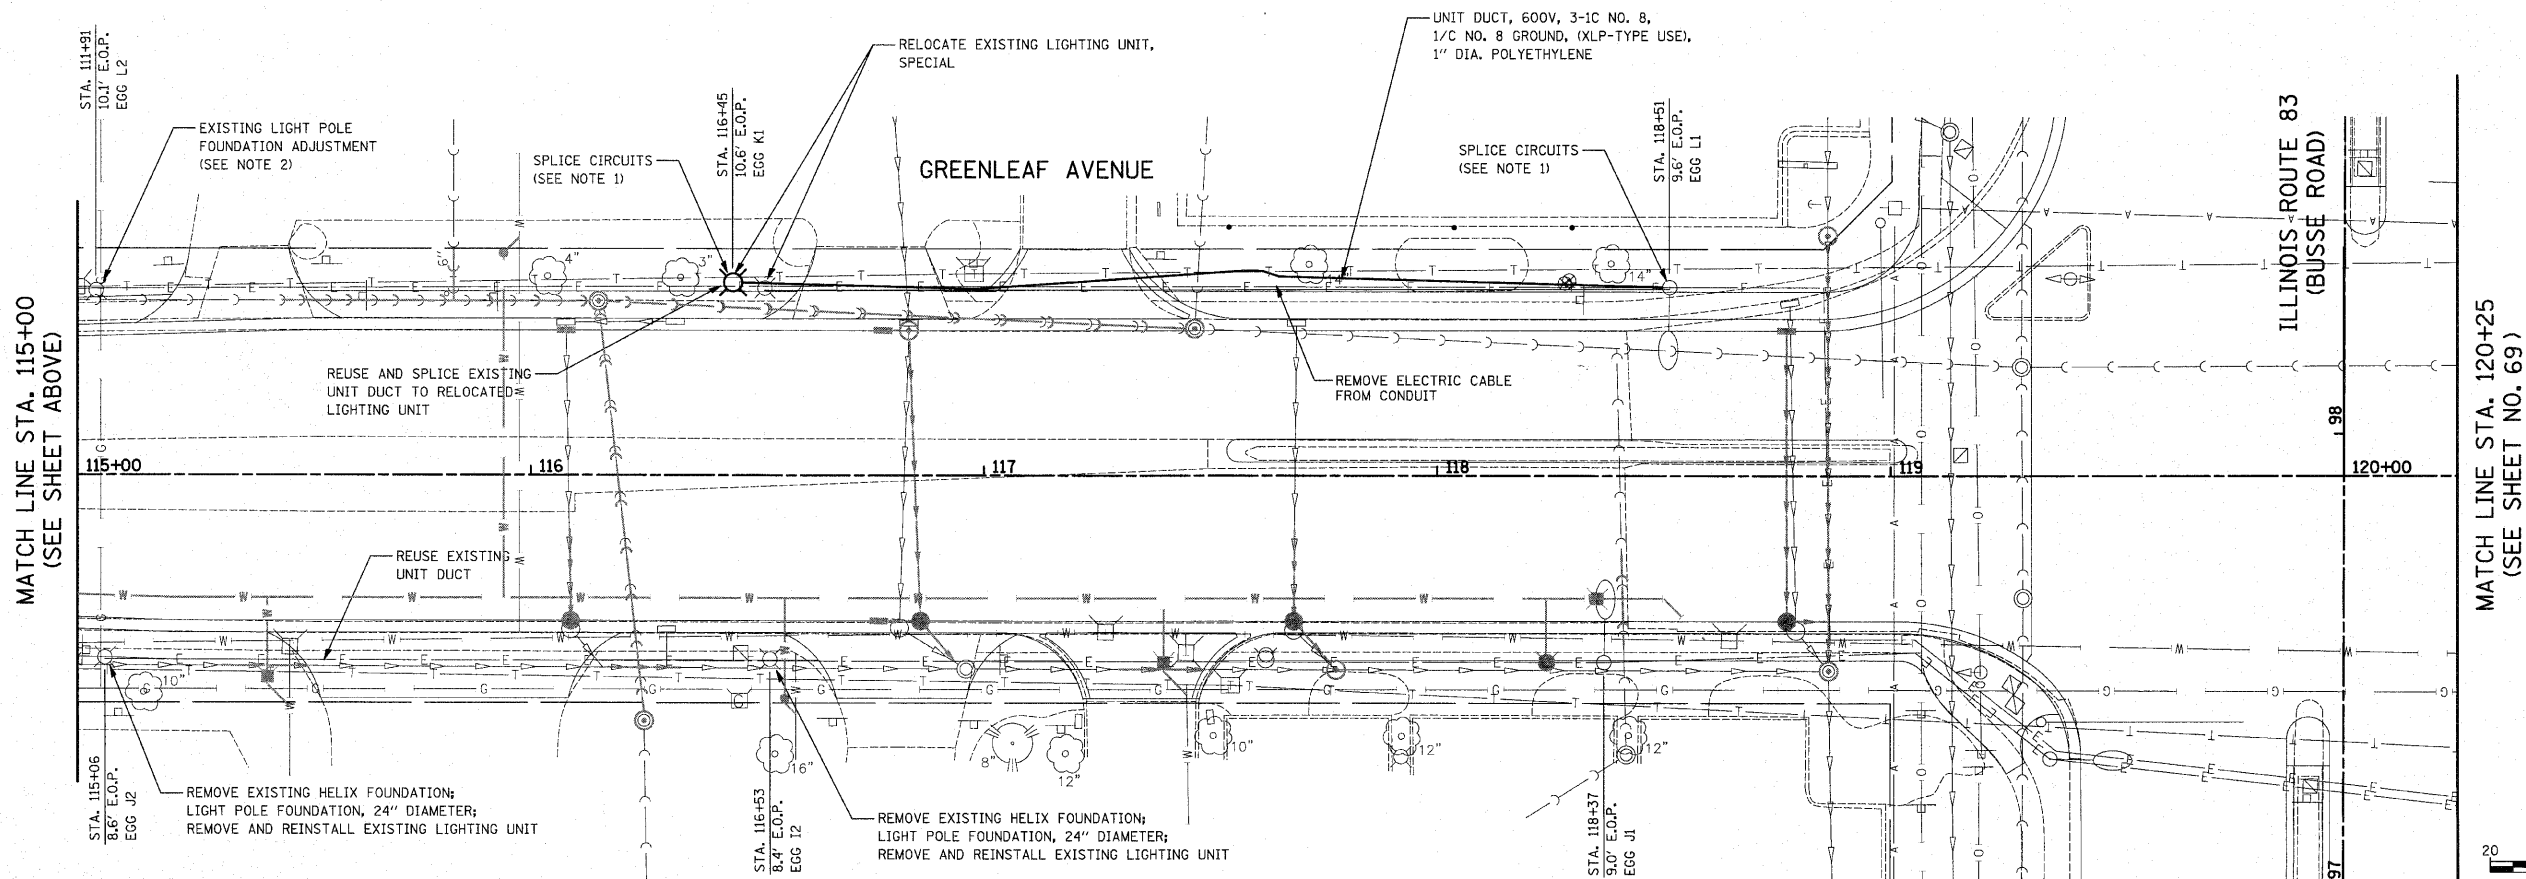


LEGEND

- | | | | |
|--|--|--|---|
| | EXISTING 400W HPS, 45' MH, 10' MA LIGHTING UNIT ON CONCRETE FOUNDATION | | RELOCATED 400W HPS, 45' MH, 10' MA LIGHTING UNIT ON CONCRETE FOUNDATION |
| | EXISTING 250W HPS, 30' MH, 0.67' MA LIGHTING UNIT ON HELIX FOUNDATION | | RELOCATED 250W HPS, 30' MH, 0.67' MA LIGHTING UNIT ON HELIX FOUNDATION |


NOTES:

- SEE EXISTING WIRING DIAGRAM ON SHEET 70 FOR CIRCUITRY.
- SEE LIGHT POLE FOUNDATION ADJUSTMENT DETAIL ON SHEET 71.
- THERE SHALL BE NO UNDERGROUND SPLICING OF UNIT DUCT CONDUCTORS EXCEPT AT THE POLE BASE.
- CONTINUITY OF EQUIPMENT GROUNDING CONDUCTOR FROM CONTROLLER TO THE LAST POLE OF EACH IMPACTED CIRCUIT SHALL BE CONFIRMED. THIS WORK WILL NOT BE PAID FOR SEPARATELY BUT SHALL BE INCLUDED IN 'MAINTENANCE OF LIGHTING SYSTEM'.

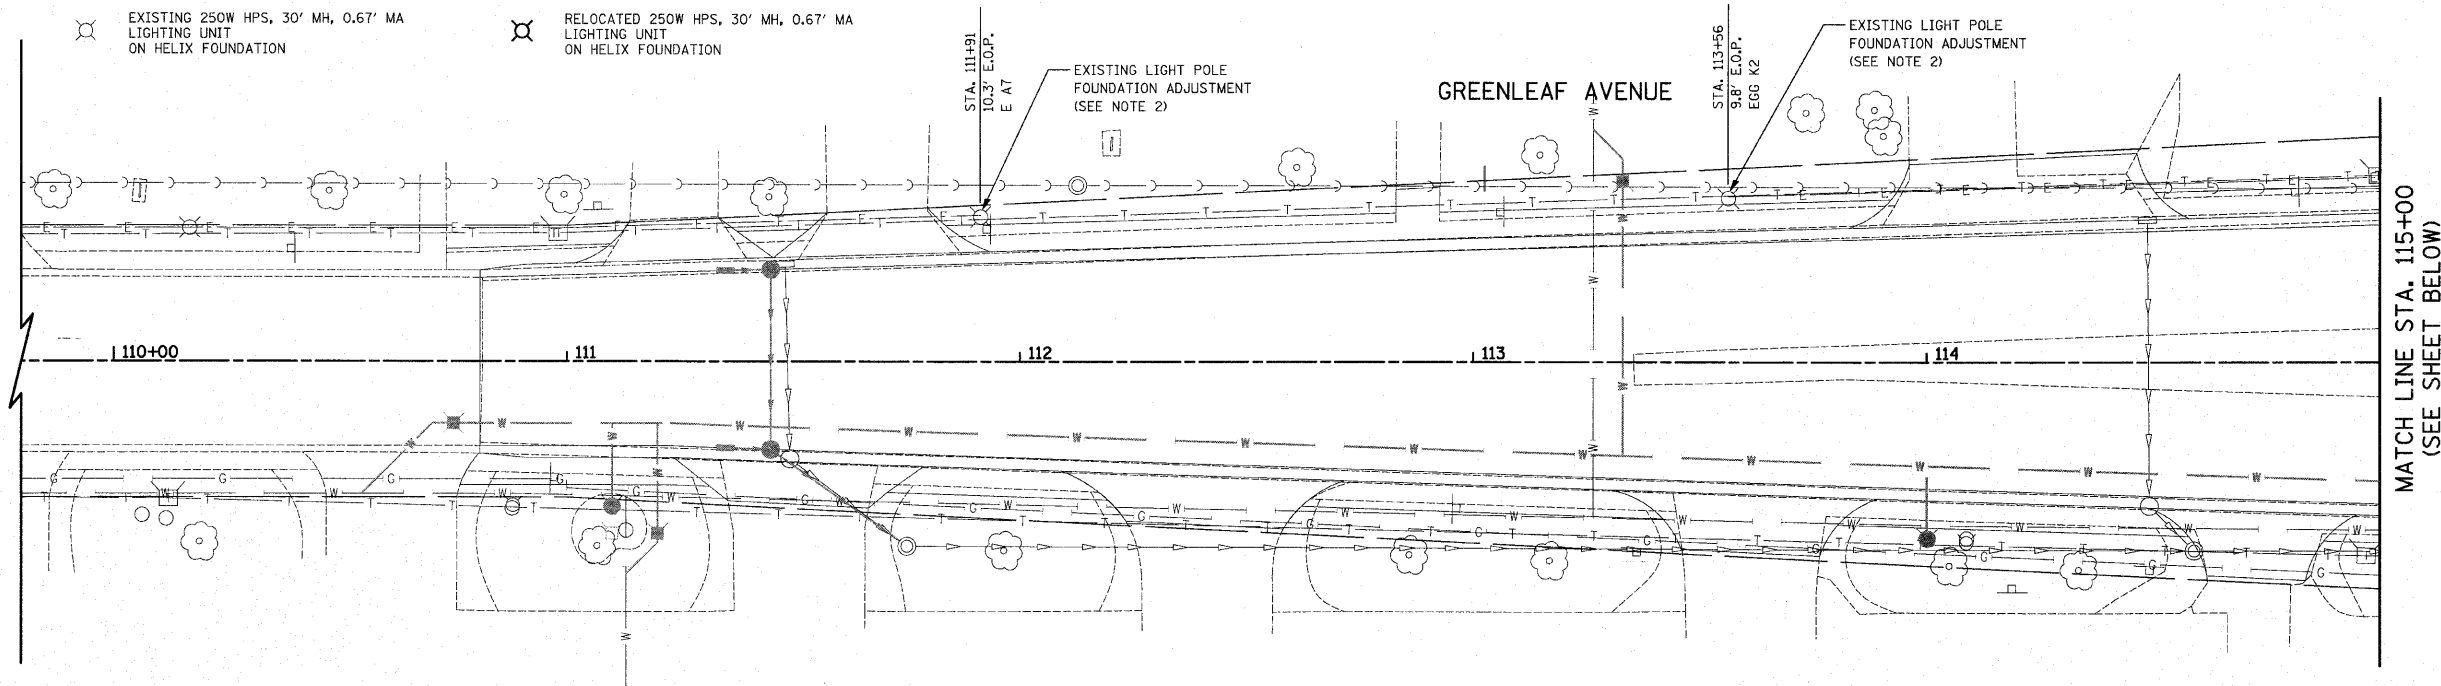

PLAN	DATE
BY	
DATE	
NO.	
NO.	
NO.	
NO.	

PROFILE	DATE
BY	
DATE	
NO.	
NO.	
NO.	
NO.	

 

FILE NAME = ...ced\sheet\2362_Light_01.dgn

USER NAME = djc	DESIGNED - SJC	REVISED -
	DRAWN - SJC	REVISED -
	CHECKED - DNM	REVISED -
	DATE - 10-22-10	REVISED -

**STATE OF ILLINOIS
DEPARTMENT OF TRANSPORTATION**

**IL ROUTE 83 (BUSSE ROAD) AND GREENLEAF AVENUE
LIGHTING PLAN**

SCALE: 1" = 20' SHEET NO. 1 OF 2 SHEETS STA. 110+80.83 TO STA. 120+25

F.A.P. RTE.	SECTION	COUNTY	TOTAL SHEETS	SHEET NO.
344	09-00056-00-CH	COOK	111	68
CONTRACT NO. 63527				
FED. ROAD DIST. NO. 1 ILLINOIS FED. AID PROJECT M-9003659				