
 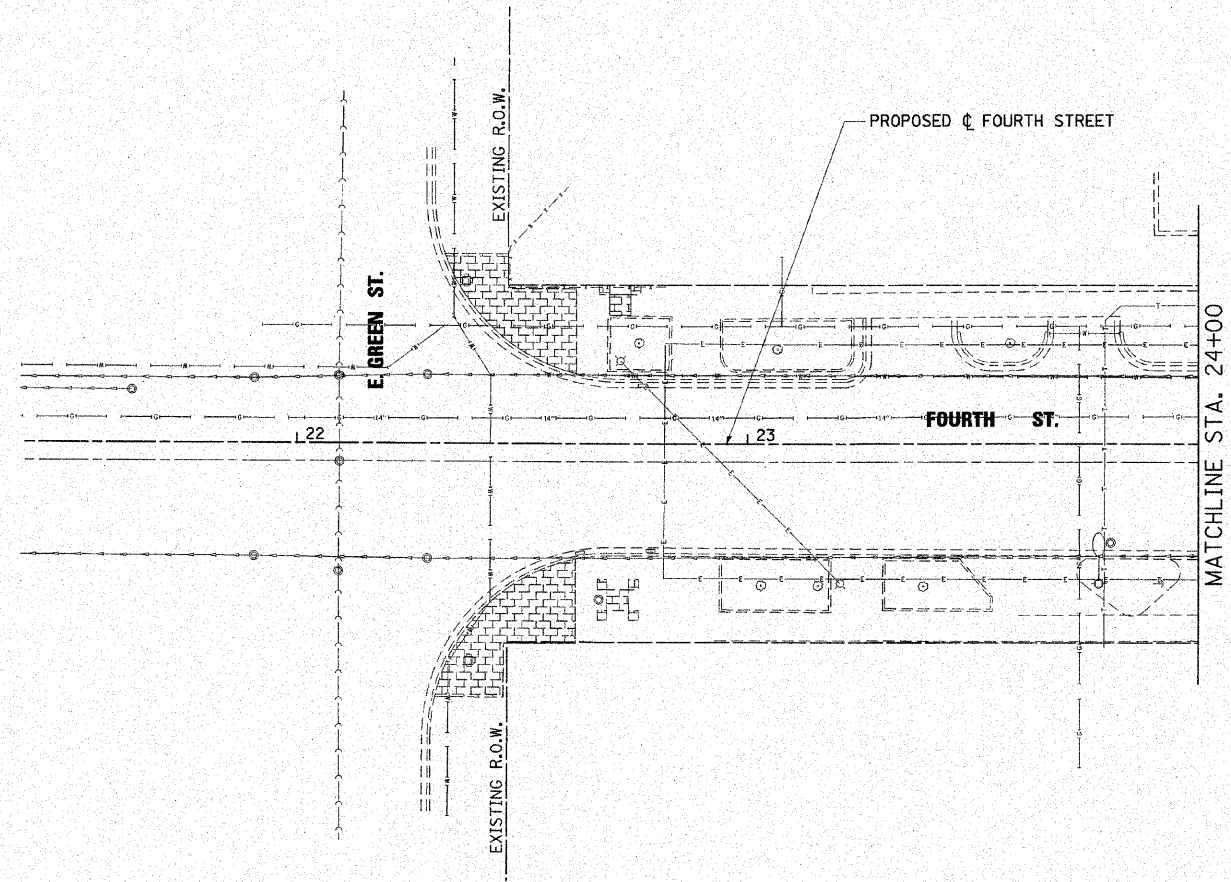



LIGHTING PLAN NOTES

1. THE CITY OF CHAMPAIGN SHALL SUPPLY ALL LIGHT POLES, DAVIT ARMS AND FIXTURES FOR THE CONTRACTOR TO INSTALL, WIRE AND TEST.
2. THE CONTRACTOR MAY ADJUST POLE LOCATIONS IN THE FIELD AS DIRECTED BY THE ENGINEER TO AVOID CONFLICTING UTILITIES. NO ADDITIONAL COST TO THE CONTRACT WILL BE ALLOWED FOR RELOCATION. MAINTAIN A MINIMUM 1.5' CLEARANCE FROM FOUNDATIONS TO BACK OF ADJACENT CURB UNLESS OTHERWISE DIRECTED BY THE ENGINEER.
3. INSTALL A 12"x12" GULFBOX WITHIN 5' OF EACH LIGHT POLE FOUNDATION. MAINTAIN MINIMUM 1.5' CLEARANCE TO BACK OF ADJACENT CURB. SEE POLE BASE DETAIL.



EXPIRES: 11/30/2011
Thomas Memminger
 THOMAS MEMMINGER
 ELECTRICAL ENGINEER
 10/15/2010
 DATE

FILE NAME = I:\champaign\100948100\draw\cedd_sheets	USER NAME = Jim Michael Lighting_Plans_01.dgn	DESIGNED - TM DRAWN - RAH CHECKED - JMM DATE - 10/15/2010	 CMT <small>CHAMFORD, MURPHY & TILLY, INC.</small> <small>CONSULTING ENGINEERS</small> <small>License No. 184-000613</small>	CITY OF CHAMPAIGN DEPARTMENT OF PUBLIC WORKS	ROADWAY LIGHTING PLAN FOURTH STREET IMPROVEMENT CHAMPAIGN, ILLINOIS	F.A.U. RTE. 7171 SECTION 10-00285-00-SP COUNTY CHAMPAIGN TOTAL SHEETS 55 SHEET NO. 43 CONTRACT NO. 91445 ILLINOIS FED. AID PROJECT
SCALE: 1" = 20' SHEET NO. OF SHEETS STA. 22+00 TO STA. 24+00						