

F.A.S. RTE.	SECTION	COUNTY	TOTAL SHEETS	SHEET NO.
732	07-00090-00-BR	MACOUPIN	77	1
FED. ROAD DIST. NO. 7		ILLINOIS	CONTRACT NO. 93538	

 


STATE OF ILLINOIS
DEPARTMENT OF TRANSPORTATION
PLANS FOR PROPOSED
HIGHWAY BRIDGE PROGRAM
MACOUPIN COUNTY
SECTION 07-00090-00-BR
F.A.S. 732 (CH 12) OVER HICKS CREEK
AND JOES CREEK
PROJECT NO. BRS-0732(148)
JOB NUMBER C-96-238-09

INDEX OF SHEETS

SHEET NO.	DESCRIPTION
1.	COVER SHEET
2.	GENERAL NOTES, TYPICAL SECTIONS
3.	SUMMARY OF QUANTITIES, DETAILS
4.-5.	SCHEDULES OF QUANTITIES
6.	TRAFFIC CONTROL PLAN
7.-8.	STORM WATER POLLUTION PREVENTION PLAN
9.-10.	PLAN AND PROFILE
11.-29.	HICKS CREEK STRUCTURE PLANS
30.-51.	JOES CREEK STRUCTURE PLANS
52.-77.	CROSS SECTIONS

REQUIRED HIGHWAY STANDARDS

- 000001-06
- 280001-05
- 420401-08
- 515001-03
- 601101-01
- 630001-09
- 630301-05
- 631011-07
- 631032-06
- 635006-03
- 635011-02
- 701006-03
- 701901-01
- 780001-02
- BLR 21-8

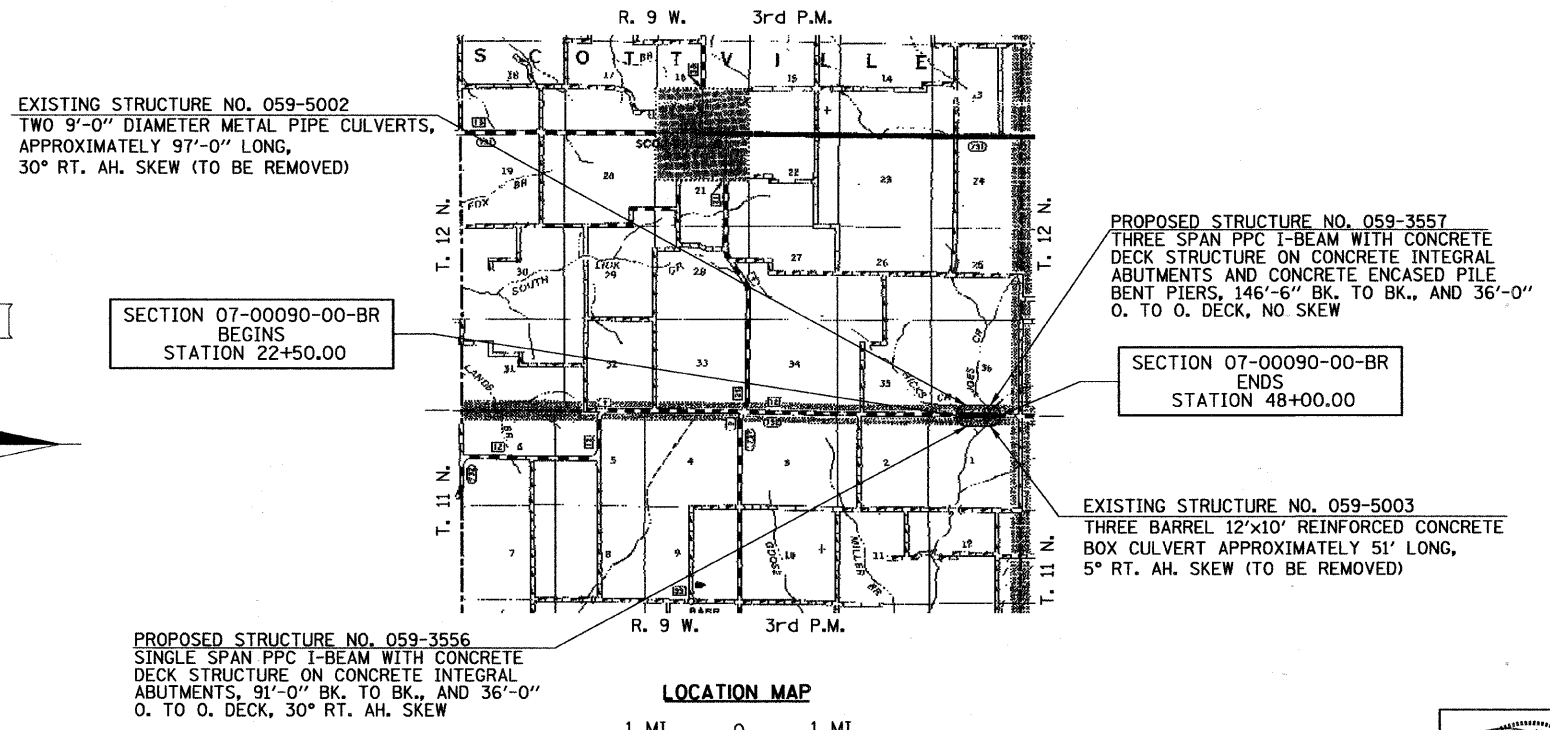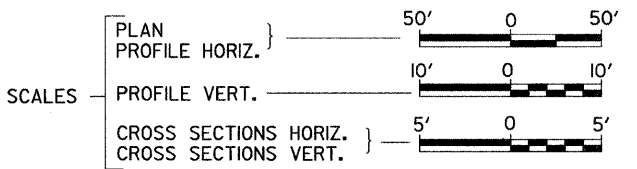

UTILITY COMPANIES

- MJM ELECTRIC
CARLINVILLE, ILLINOIS
- SCOTTVILLE RURAL WATER CO.
SCOTTVILLE, ILLINOIS
- VERIZON
JACKSONVILLE, ILLINOIS

J.U.L.I.E.
JOINT UTILITY LOCATION INFORMATION FOR EXCAVATION
1-800-892-0123
OR 811

NET LENGTH OF PROJECT = 2550.00 FEET = 0.483 MILES
 DESIGN CLASSIFICATION: MAJOR COLLECTOR (NON-URBAN)
 DESIGN ADT = 635 (2029)
 DESIGN SPEED = 50 MPH

Hutchison Engineering, Inc.
JACKSONVILLE ILLINOIS

Lianna E. Hutchison
 REGISTERED PROFESSIONAL ENGINEER OF ILLINOIS
 SIGNATURE
 ENGINEER'S SEAL

APPROVED	<u>March 4</u>	2010
	<i>Thomas A. Reinhart</i>	MACOUPIN COUNTY ENGINEER
PASSED	<u>APRIL 21</u>	2010
	<i>Thomas A. Reinhart</i>	DISTRICT SIX ENGINEER OF LOCAL ROADS & STREETS
PASSED	<u>April 21</u>	2010
	<i>Ron Buchanan</i>	DISTRICT SIX ENGINEER OF CONSTRUCTION
Released For Bid Based on Limited Review	<u>APRIL 21</u>	2010
	<i>Roger S. Driskell</i>	DEPUTY DIRECTOR OF HIGHWAYS, REGION FOUR ENGINEER
STATE OF ILLINOIS DEPARTMENT OF TRANSPORTATION		

CONTRACT NO. 93538

2576E001