

ROUTE NO.	SECTION	COUNTY	TOTAL SHEETS	SHEET NO.
F.A.S. 1897	08-00073-00-BR	GALLATIN	14	1
FED. ROAD DIST. NO.	ILLINOIS	CONTRACT NO.		

**STATE OF ILLINOIS**  
**DEPARTMENT OF TRANSPORTATION**  
**DIVISION OF HIGHWAYS**

**PLANS FOR PROPOSED  
HIGHWAY BRIDGE PROGRAM**

**PROJECT BRS-1897(107)**  
**SECTION 08-00073-00-BR**  
**GALLATIN COUNTY**  
**F.A.S. 1897 / COTTONWOOD ROAD**  
**PROPOSED STRUCTURE NO. 030-3128**  
**C-99-500-09**

**INDEX OF SHEETS**

SHEET NO.	DESCRIPTION
1.	COVER SHEET
2.	SUMMARY OF QUANTITIES AND TYPICAL SECTIONS
3.	PLAN AND PROFILE
4.-6.	CROSS SECTIONS
7.-13.	BRIDGE PLANS
14.	BORINGS

HIGHWAY STANDARDS:



000001-06	STANDARD SYMBOLS, ABBREVIATIONS, AND PATTERNS
515001-03	NAME PLATE FOR BRIDGES
635006-03	REFLECTOR AND TERMINAL MARKER PLACEMENT
701901-01	TRAFFIC CONTROL DEVICES
BLR 21-8	TYPICAL APPLICATION OF TRAFFIC CONTROL DEVICES FOR CONSTRUCTION ON RURAL LOCAL HIGHWAYS

**UTILITIES**

VERIZON NORTH  
110 EAST MONROE  
P.O. BOX 2675  
BLOOMINGTON, IL 61701-2675



FUNCTIONAL CLASSIFICATION: MAJOR COLLECTOR (NON-URBAN < 400 ADT)  
DESIGN SPEED: 30 MPH  
DESIGN TRAFFIC: 75 ADT

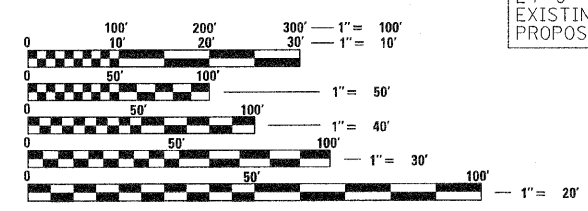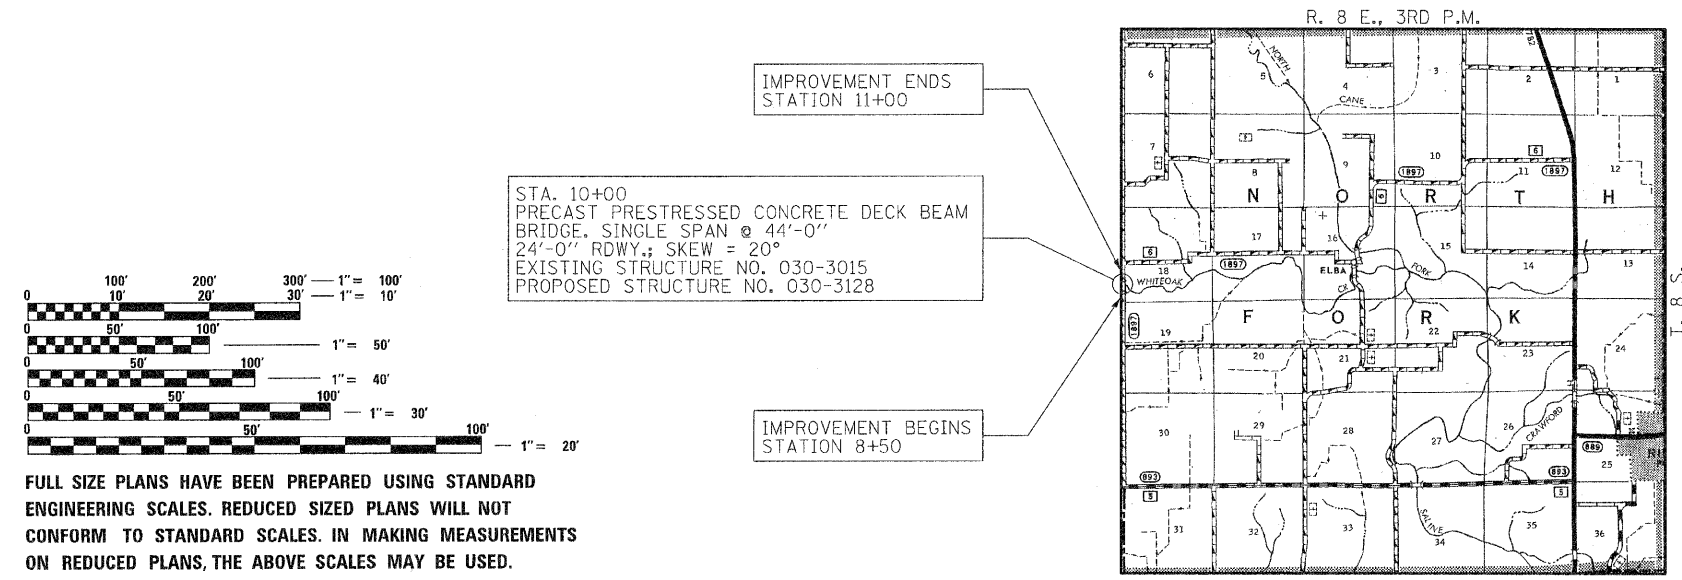

FULL SIZE PLANS HAVE BEEN PREPARED USING STANDARD ENGINEERING SCALES. REDUCED SIZED PLANS WILL NOT CONFORM TO STANDARD SCALES. IN MAKING MEASUREMENTS ON REDUCED PLANS, THE ABOVE SCALES MAY BE USED.

**LOCATION MAP**  
APPROXIMATE SCALE: 0 1 MILE  
NET LENGTH OF SECTION = 250 FEET = 0.0473 MILES



**ILLINOIS DEPARTMENT OF TRANSPORTATION**

APPROVED SEPT 13 2010  
*Jim W. P... County Engineer*

PASSED Oct. 27 2010  
*Dennis W. Hill... District Nine Engineer of Local Roads & Streets*

Releasing For Bid Based on Limited Review Oct. 28 2010  
*Warry C. Lammie Deputy/Director of Highways Region Five Engineer State of Illinois Department of Transportation*

**CONTRACT NO. 99422**

DATE: 08/27/2010

**HAMPTON, LENZINI AND RENWICK, INC.**  
CIVIL ENGINEERS • STRUCTURAL ENGINEERS • LAND SURVEYORS  
3085 STEVENSON DRIVE, SUITE 201  
SPRINGFIELD, ILLINOIS 62703  
217.546.3400 www.hlrengineering.com

184.000959  
ILLINOIS PROFESSIONAL DESIGN FIRM LS / PE / SE CORPORATION

EXPIRES: 11/30/2011 PROJECT NUMBER: 09.0121.130 DATE: 08/27/10