


SECTION	2424.15-D	COC	32	7
F.A.I. RTE.	290	(2525, ETC., 2727) RS-8	COOK	201 155

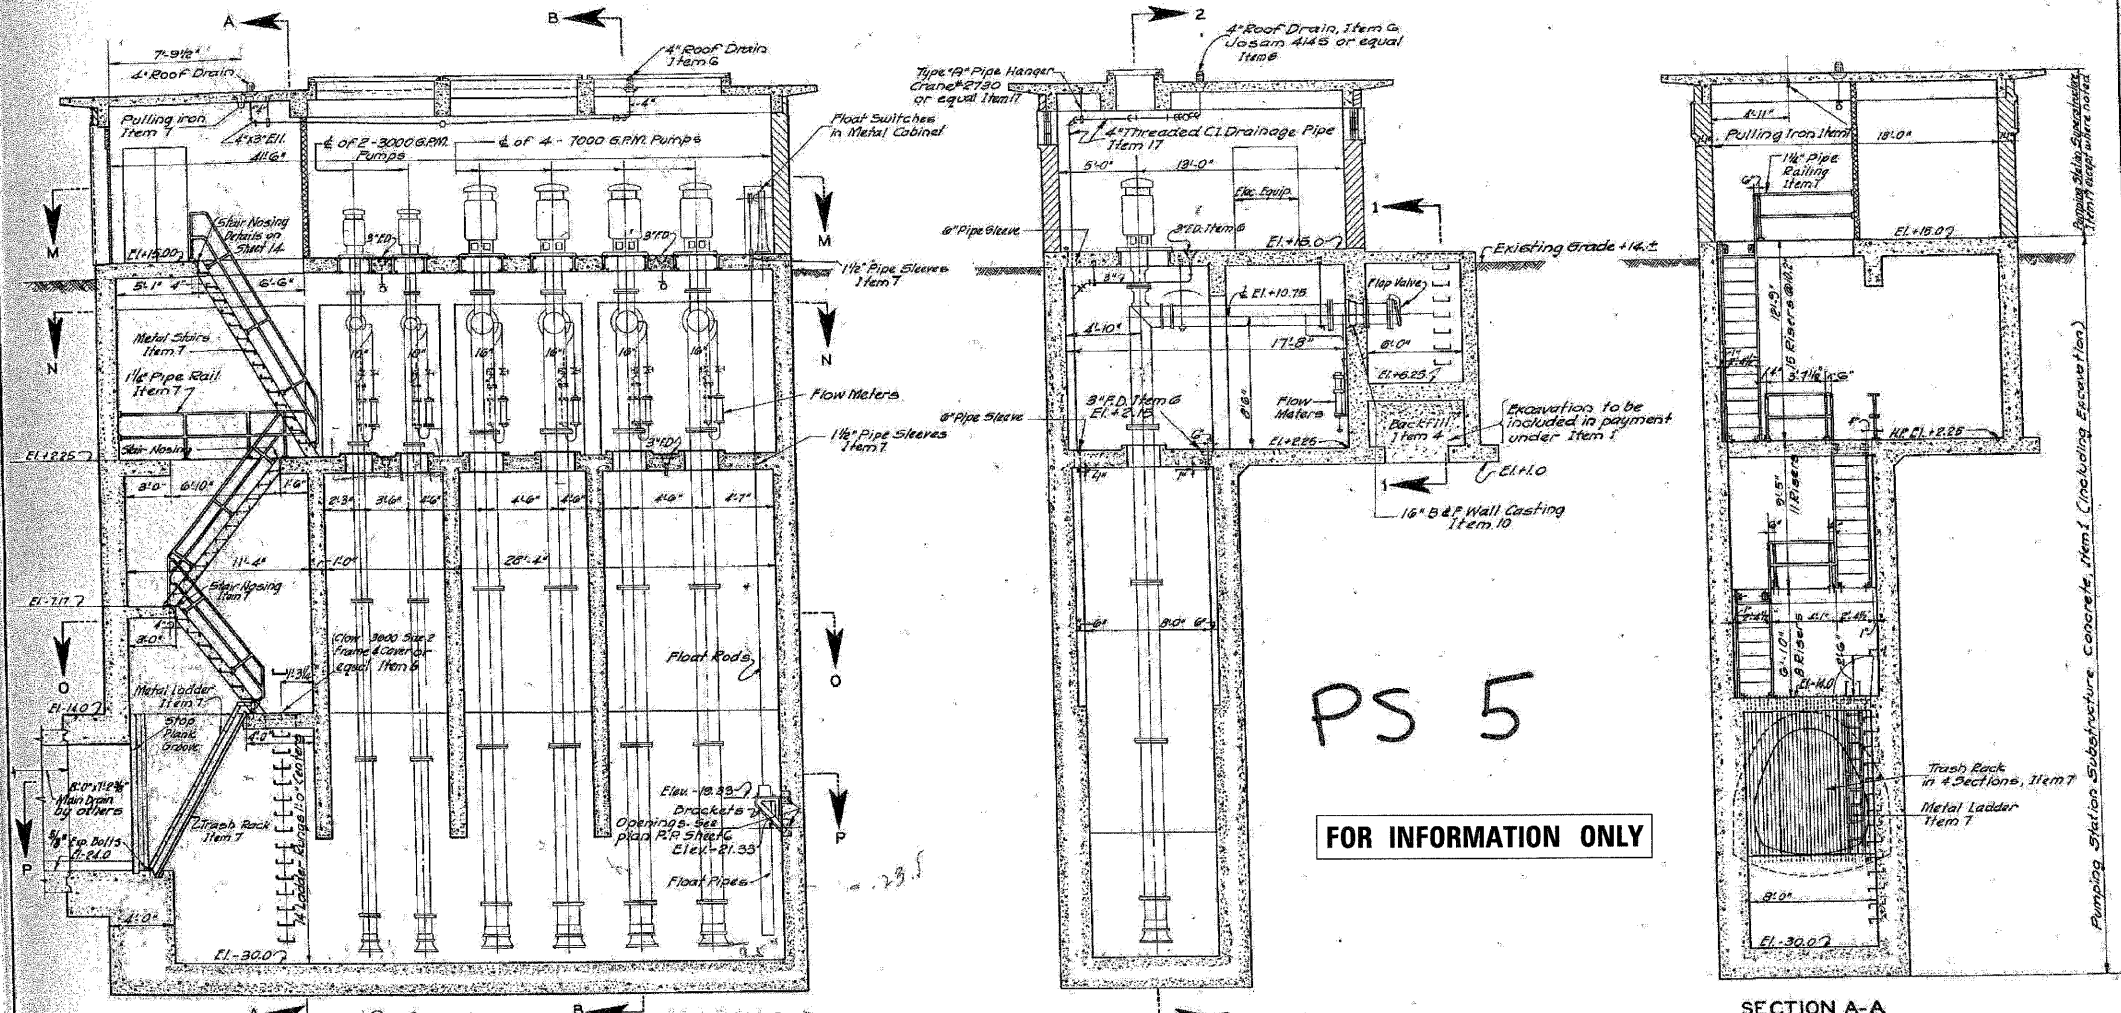

PS 5  
FOR INFORMATION ONLY

Notes:  
All pumping electrical and metering equipment and gas heater shown in light lines, to be furnished by others under a future contract.  
For detail drawings of superstructure, see sheets 15, 16, 17 and 18.  
For electrical details see sheets 21 and 22.  
For details of metal stairs, pump supports, wall castings, trash rack and ladder, see sheet 14.  
For details of ladder rungs and pulling iron, see sheet 23.  
For general plans M-M, N-N, O-O and P-P see sheet 6.

Drawn By: H.F. Reynolds  
Checked By: E. L. L. L.  
Approved By: [Signature]  
Supply Pkg. Engineer

CITY OF CHICAGO  
DEPARTMENT OF SUBWAYS AND SUPERHIGHWAYS  
WEST ROUTE SUPERHIGHWAY  
SECTION 2424.15-D  
PUMPING STATION AND DISCHARGE CONDUIT  
S. DESPLAINES ST. TO S. BRANCH OF CHICAGO RIVER  
PUMPING STATION  
GENERAL SECTIONS  
SCALE: AS NOTED  
SHEET NO. 7  
FEBRUARY 1951  
OF 32 SHEETS

FILE NAME =	DESIGNED - SGL	REVISED -
#FILE#	DRAWN - SGL	REVISED -
USER NAME = #USER#	CHECKED - FML	REVISED -
PLOT DATE = #DATE#	DATE - 1/25/10	REVISED -



STATE OF ILLINOIS  
DEPARTMENT OF TRANSPORTATION

PUMP STATION NO. 5  
RECORD DRAWINGS

SCALE: SHEET NO. 1 OF 4 SHEETS STA. TO STA.

F.A.I. RTE.	SECTION	COUNTY	TOTAL SHEETS	SHEET NO.
290	(2525, ETC., 2727) RS-8	COOK	201	155
CONTRACT NO. 60K11				
[ILLINOIS] FED. AID PROJECT				