


SIGN DETAIL  
1:75

WB-TR-62  
STA. 505+00

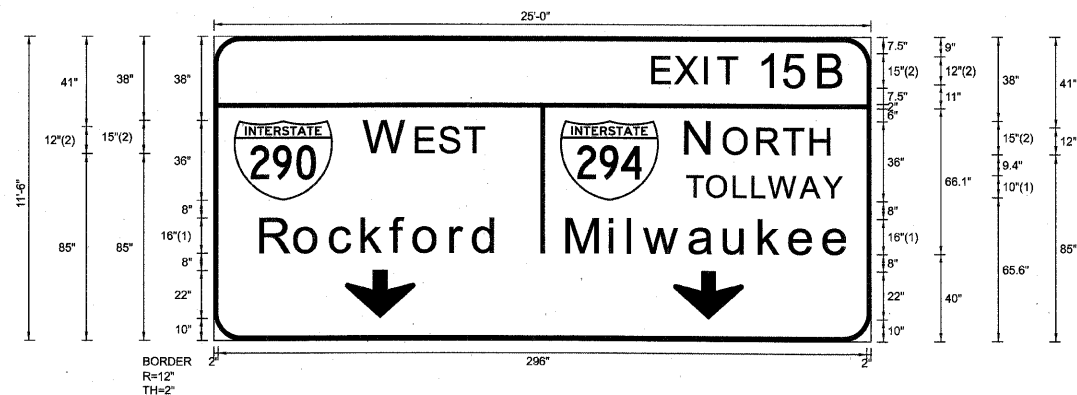

FONT:  
(1) ClearviewHwy-5-W-R  
(2) ClearviewHwy-5-W

Panel Style: sign\_default.ssi  
Dimensions are in inches.tenths

Letter locations are panel edge to lower left corner

|               |                    |
|---------------|--------------------|
| SIGN NUMBER   | name               |
| WIDTH x HGT.  | 25'-0" x 11'-6"    |
| BORDER WIDTH  | 2"                 |
| CORNER RADIUS | 12"                |
| MOUNTING      | Overhead           |
| BACKGROUND    | TYPE: Reflective   |
|               | COLOR: Green       |
| LEGEND/BORDER | TYPE: Reflective   |
|               | COLOR: White/White |

| SYMBOL | ROT | X     | Y  | WID | HT |
|--------|-----|-------|----|-----|----|
| M1_1   | 0   | 9.2   | 64 | 45  | 36 |
| M1_1   | 0   | 158.2 | 64 | 45  | 36 |
| ARDOWN | 0   | 60    | 10 | 32  | 22 |
| ARDOWN | 0   | 210   | 10 | 32  | 22 |

LETTER POSITIONS (X)

| LETTER | POSITION (X) | LENGTH | SERIES/SIZE        |
|--------|--------------|--------|--------------------|
| E      | 200.9        | 87.5   | ClearviewHwy-5-W   |
| X      | 211.2        | 12,15  |                    |
| I      | 224.8        |        |                    |
| T      | 230.8        |        |                    |
| 1      | 249.4        |        |                    |
| 5      | 261.4        |        |                    |
| B      | 277.1        |        |                    |
| W      | 69.2         | 54.5   | ClearviewHwy-5-W   |
| E      | 92.9         | 15,12  |                    |
| S      | 103.7        |        |                    |
| T      | 115.1        |        |                    |
| N      | 216.3        | 65.9   | ClearviewHwy-5-W   |
| O      | 233.5        | 15,12  |                    |
| R      | 248.9        |        |                    |
| T      | 260.8        |        |                    |
| H      | 273.1        |        |                    |
| T      | 216.3        | 70.9   | ClearviewHwy-5-W-R |
| O      | 225.5        | 10     |                    |
| L      | 237.8        |        |                    |
| L      | 246.2        |        |                    |
| W      | 253.6        |        |                    |
| A      | 268.1        |        |                    |
| Y      | 278.5        |        |                    |
| R      | 21.8         | 108.9  | ClearviewHwy-5-W-R |
| o      | 37.5         | 16/13  |                    |
| c      | 53.6         |        |                    |
| k      | 68.1         |        |                    |
| f      | 81.3         |        |                    |
| o      | 92           |        |                    |
| r      | 108.8        |        |                    |
| d      | 119.1        |        |                    |
| M      | 161.7        | 129.1  | ClearviewHwy-5-W-R |
| i      | 181.3        | 16/13  |                    |
| l      | 189.7        |        |                    |
| w      | 196.9        |        |                    |
| a      | 217.7        |        |                    |
| u      | 233.7        |        |                    |
| k      | 249.6        |        |                    |
| e      | 263.5        |        |                    |
| e      | 279          |        |                    |

|                    |                |           |
|--------------------|----------------|-----------|
| FILE NAME =        | DESIGNED - SEW | REVISED - |
| *FILEL#            | DRAWN - SEW    | REVISED - |
| USER NAME = #USER# | CHECKED - FML  | REVISED - |
| PLOT DATE = #DATE# | DATE - 1/25/10 | REVISED - |



STATE OF ILLINOIS  
DEPARTMENT OF TRANSPORTATION

SIGNING DETAILS

SCALE: N.T.S. SHEET NO. 21 OF 43 SHEETS STA. TO STA.

|   |                         |        |                    |           |
|---|-------------------------|--------|--------------------|-----------|
| F.A.I. RTE.                                     | SECTION                 | COUNTY | TOTAL SHEETS       | SHEET NO. |
| 290   | (3435, ETC., 3838)/RS-5 | COOK   | 264                | 176       |
| FED. ROAD DIST. NO. [ILLINOIS] FED. AID PROJECT |                         |        | CONTRACT NO. 60652 |           |