


SIGN DETAIL
1:75

WB-TR-69
STA. 546+40

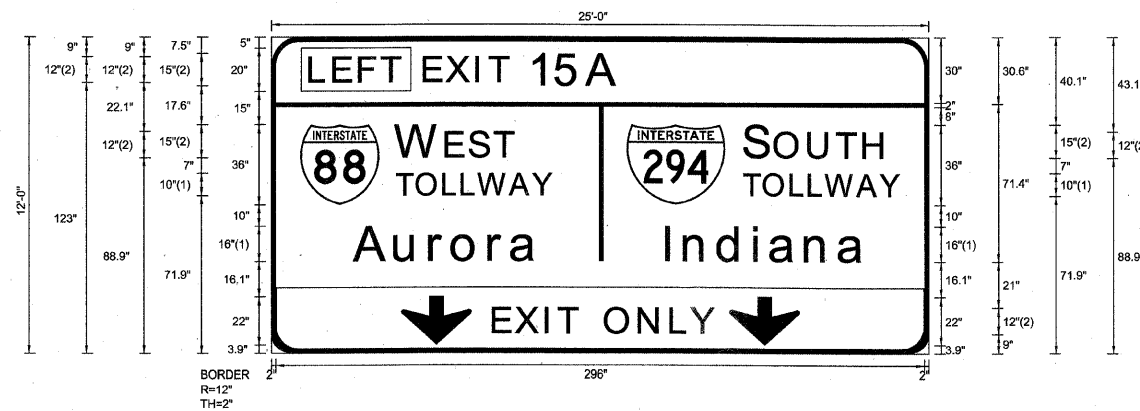

FONT:
(1) ClearviewHwy-5-W-R
(2) ClearviewHwy-5-W

Panel Style: sign_default.ssi
Dimensions are in inches.tenths

Letter locations are panel edge to lower left corner

SIGN NUMBER	name
WIDTH x HGHT.	25'-0" x 12'-0"
BORDER WIDTH	2"
CORNER RADIUS	12"
MOUNTING	Overhead
BACKGROUND	TYPE: Reflective COLOR: Green
LEGEND/BORDER	TYPE: Reflective COLOR: White,BlackWhite

SYMBOL	ROT	X	Y	WID	HT
M1_1	0	13.2	68	36	36
M1_1	0	162.2	68	45	36
AROUND	0	59.3	3.9	32	22
AROUND	0	209.3	3.9	32	22

LETTER POSITIONS (X)

										LENGTH	SERIES/SIZE
L	E	F	T							41.2	ClearviewHwy-5-W 12
18	28.8	40.5	50.6								
E	X	I	T	1	5	A				88.6	ClearviewHwy-5-W 12,15
70.1	80.4	94.1	100	118.6	130.6	144.7					
W	E	S	T							53.7	ClearviewHwy-5-W 15,12
57.2	80.1	90.9	102.3								
S	O	U	T	H						63.6	ClearviewHwy-5-W 15,12
216.5	230.4	245.8	258.7	270.9							
T	O	L	L	W	A	Y				70.9	ClearviewHwy-5-W-R 10
57.2	66.4	78.7	87.1	94.6	109.1	119.4					
J	O	L	L	W	A	Y				70.9	ClearviewHwy-5-W-R 10
215.9	225	237.3	245.7	253.2	267.7	278					
A	u	r	o	r	a					83.5	ClearviewHwy-5-W-R 16/13
38.1	56.6	72.6	83	99.7	109.8						
i	n	d	i	a	n	a				90.8	ClearviewHwy-5-W-R 16/13
180.5	188.9	204.4	220.7	228.2	244.2	259.4					
E	X	I	T		O	N	L	Y		101	ClearviewHwy-5-W 12
101.7	112	125.6	131.6	140.2	152.9	168.3	182.9	192.2			

FILE NAME =	DESIGNED - SEW	REVISED -
#FILEL#	DRAWN - SEW	REVISED -
USER NAME = #USER#	CHECKED - FML	REVISED -
PLOT DATE = #DATE#	DATE - 1/25/10	REVISED -



STATE OF ILLINOIS
DEPARTMENT OF TRANSPORTATION

SIGNING DETAILS

SCALE: N.T.S. SHEET NO. 27 OF 43 SHEETS STA. TO STA.

F.A.I. RTE.	SECTION	COUNTY	TOTAL SHEETS	SHEET NO.
290	(3435, ETC., 3838)RS-5	COOK	264	182
FED. ROAD DIST. NO.		ILLINOIS FED. AID PROJECT		
		CONTRACT NO. 60G52		