


SIGN DETAIL
1:75

WB-TR-70
STA. 546+40

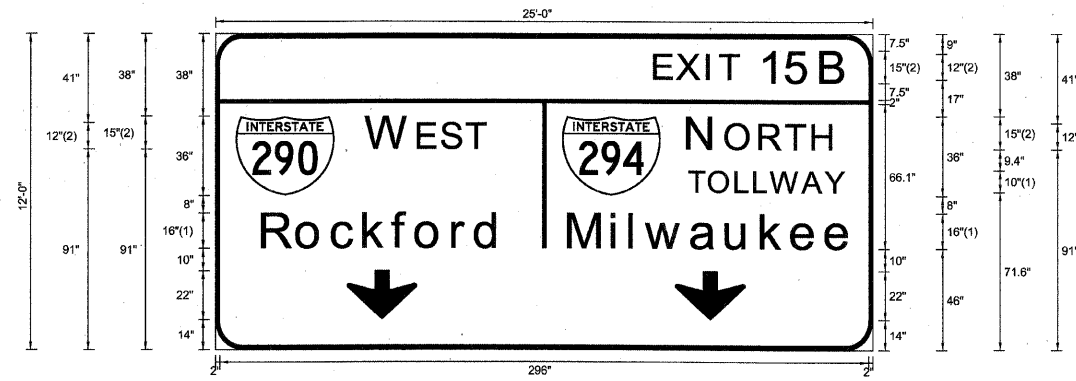

FONT:
(1) ClearviewHwy-5-W-R
(2) ClearviewHwy-5-W

Panel Style: sign_default.ssi
Dimensions are in inches.tenths

Letter locations are panel edge to lower left corner

SIGN NUMBER	name
WIDTH x HGHT.	25'-0" x 12'-0"
BORDER WIDTH	2"
CORNER RADIUS	12"
MOUNTING	Overhead
BACKGROUND	TYPE: Reflective
	COLOR: Green
LEGEND/BORDER	TYPE: Reflective
	COLOR: White/White

SYMBOL	ROT	X	Y	WID	HT
M1_1	0	9.2	70	45	36
M1_1	0	158.2	70	45	36
ARDOWN	0	60	14	32	22
ARDOWN	0	210	14	32	22

LETTER POSITIONS (X)

										LENGTH	SERIES/SIZE
E	X	I	T	1	5	B				87.5	ClearviewHwy-5-W 12,15
200.9	211.2	224.8	230.8	249.4	261.4	277.1					
W	E	S	T							54.5	ClearviewHwy-5-W 15,12
69.2	92.9	103.7	115.1								
N	O	R	T	H						65.9	ClearviewHwy-5-W 15,12
216.3	233.5	248.9	260.8	273.1							
T	O	L	L	W	A	Y				70.9	ClearviewHwy-5-W-R 10
216.3	225.5	237.7	246.2	253.6	268.1	278.5					
R	o	c	k	f	o	r	d			108.9	ClearviewHwy-5-W-R 16/13
21.8	37.5	53.6	68.1	81.3	92	108.8	119.1				
M	i	l	w	a	u	k	e	e		129.1	ClearviewHwy-5-W-R 16/13
161.7	181.3	189.7	196.9	217.7	233.7	249.6	263.5	279			

FILE NAME =	DESIGNED - SEW	REVISED -
FILEL	DRAWN - SEW	REVISED -
USER NAME = #USER#	CHECKED - FML	REVISED -
PLOT DATE = #DATE#	DATE - 1/25/10	REVISED -



STATE OF ILLINOIS
DEPARTMENT OF TRANSPORTATION

SIGNING DETAILS

SCALE: N.T.S. SHEET NO. 28 OF 43 SHEETS STA. TO STA.

F.A.I. RTE.	SECTION	COUNTY	TOTAL SHEETS	SHEET NO.
290	(3435, ETC., 3838)RS-5	COOK	264	183
FED. ROAD DIST. NO. ILLINOIS FED. AID PROJECT			CONTRACT NO. 60652	