


SIGN DETAIL
1:75

WB-TR-75
STA. 582+85

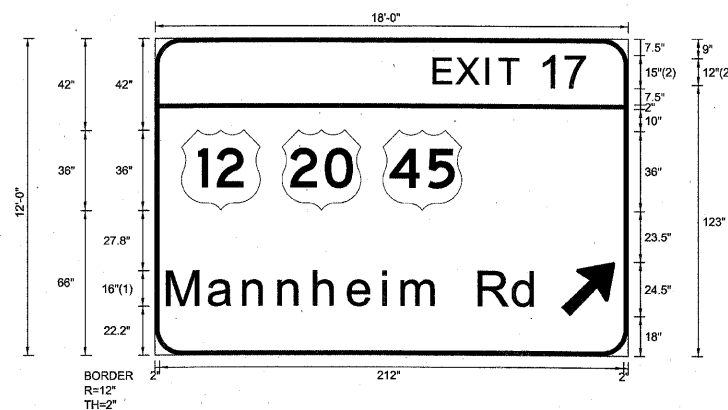

FONT:
(1) ClearviewHwy-5-W-R
(2) ClearviewHwy-5-W

Panel Style: sign_default.ssi
Dimensions are in inches.tenths

Letter locations are panel edge to lower left corner

SIGN NUMBER	name
WIDTH x HGHT.	18'-0" x 12'-0"
BORDER WIDTH	2"
CORNER RADIUS	12"
MOUNTING	Overhead
BACKGROUND	TYPE: Reflective
	COLOR: Green
LEGEND/BORDER	TYPE: Reflective
	COLOR: White/White

SYMBOL	ROT	X	Y	WID	HT
M1_4	0	12	66	36	36
M1_4	0	58	66	36	36
M1_4	0	104	66	36	36
ARMED	45	185.6	18	20	31.5

LETTER POSITIONS (X)

											LENGTH	SERIESSIZE
E	X	I	T	1	7							ClearviewHwy-5-W
127.8	138	151.7	157.6	176.2	187.5						70.3	12,15
M	a	n	n	h	e	i	m	R	d			ClearviewHwy-5-W-R
5.9	24.8	40.8	57	73.1	88.7	104.5	113	131.1	148.3	164	169.7	16,13

FILE NAME =	DESIGNED - SEW	REVISED -
*FILE#	DRAWN - SEW	REVISED -
USER NAME = *USER#	CHECKED - FML	REVISED -
PLOT DATE = *DATE#	DATE - 1/25/10	REVISED -



STATE OF ILLINOIS
DEPARTMENT OF TRANSPORTATION

SIGNING DETAILS

SCALE: N.T.S. SHEET NO. 32 OF 43 SHEETS STA. TO STA.

F.A.I. RTE.	SECTION	COUNTY	TOTAL SHEETS	SHEET NO.
290	(3435, ETC., 3838)RS-5	COOK	264	187
FED. ROAD DIST. NO.			ILLINOIS FED. AID PROJECT	
CONTRACT NO. 60G52				